



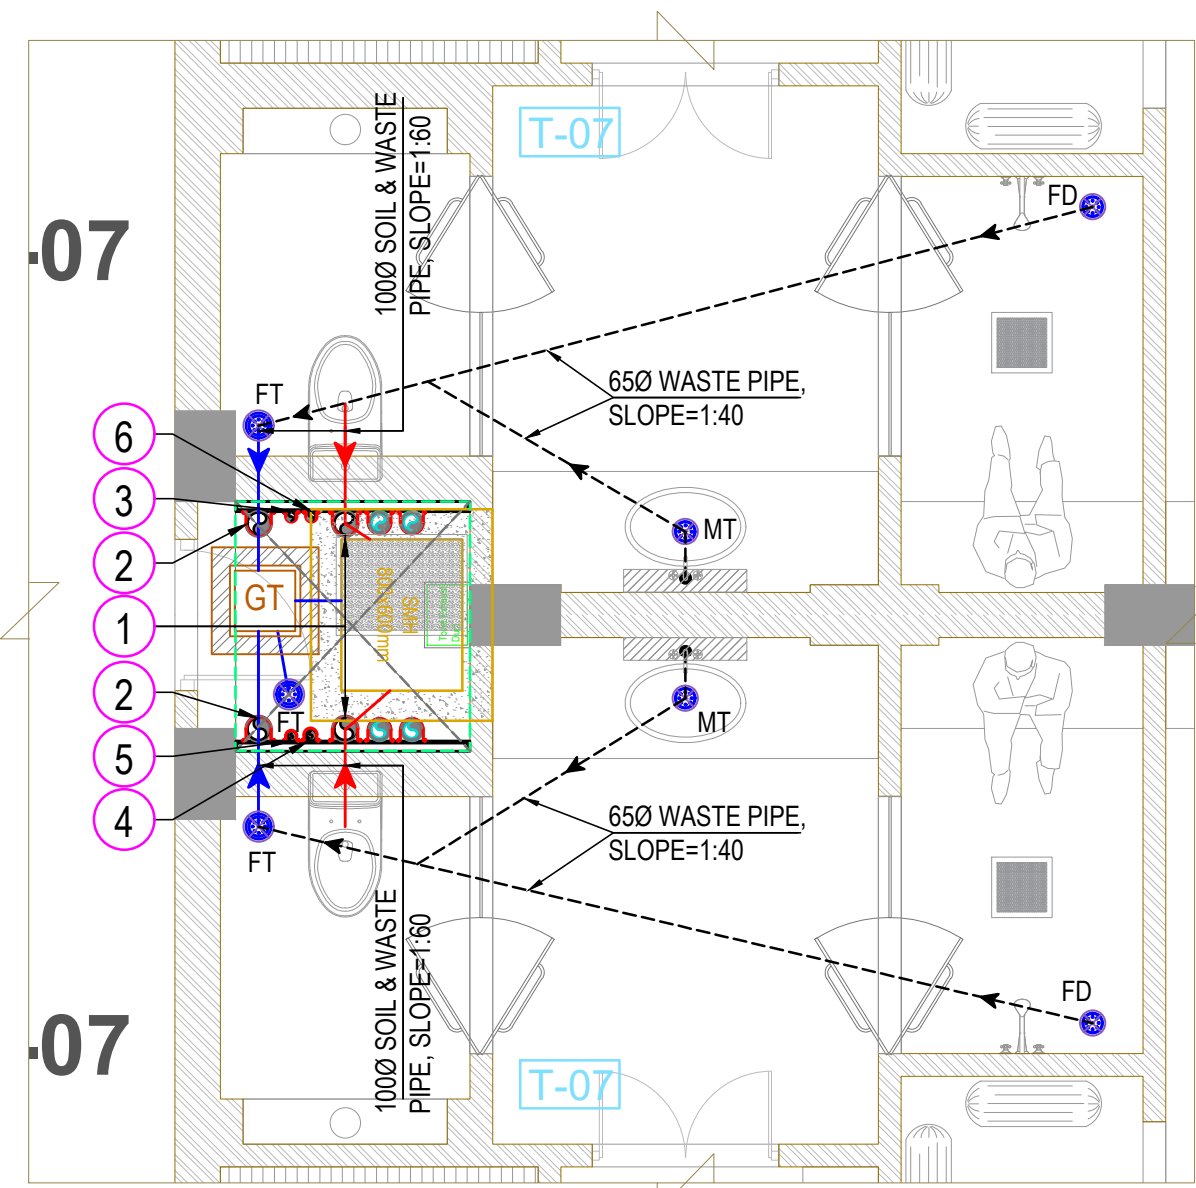


TOILET-07 FOR GROUND FLOOR
(WATER SUPPLY LAYOUT)

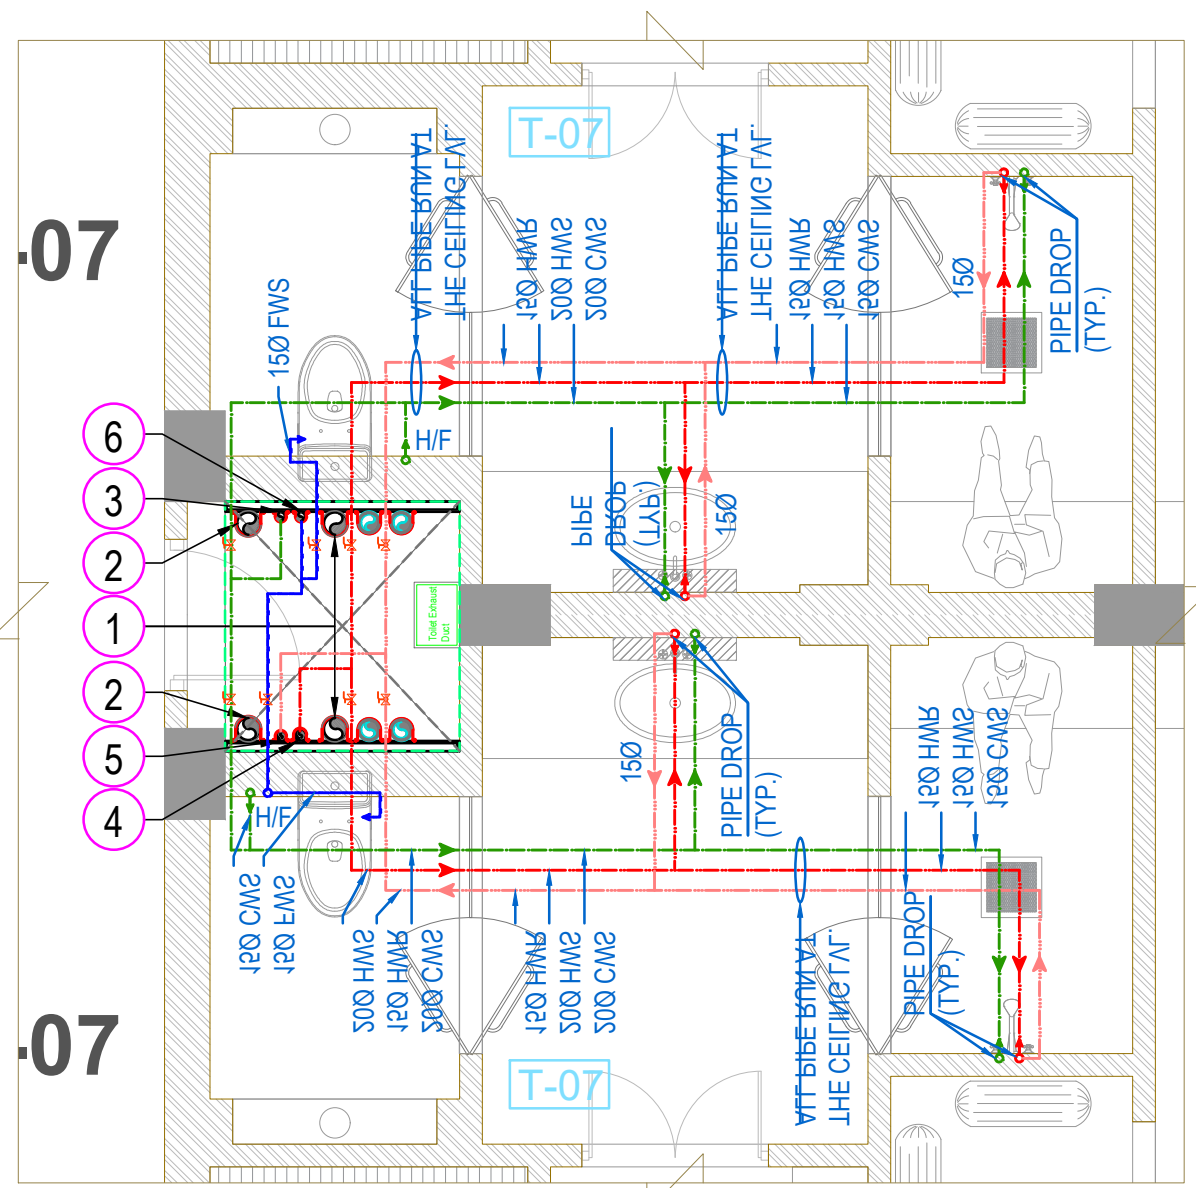


TOILET-07 FOR GROUND FLOOR
(WATER SUPPLY LAYOUT)

PLUMBING LEGEND	
CWS	COLD WATER SUPPLY
FWS	FLUSHING WATER SUPPLY
HWS	HOT WATER SUPPLY
HWR	HOT WATER RETURN
	BALL VALVE
	GLOBE VALVE
	COLD WATER SUPPLY PIPE
	FLUSHING WATER SUPPLY PIPE
	HOT WATER SUPPLY PIPE
	HOT WATER RETURN PIPE

PLUMBING LEGEND	
①	1000 SOIL VERTICAL & VENT PIPE
②	1000 WASTE VERTICAL & VENT PIPE
③	COLD WATER SUPPLY PIPE FROM W.T.P. PLANT ROOM (HYDRO-PNEUMATIC SYSTEM) FOR GR. & 1ST FLOOR
③a	COLD WATER SUPPLY PIPE FROM W.T.P. PLANT ROOM (HYDRO-PNEUMATIC SYSTEM) FOR 2ND & 3RD FLOOR
③b	COLD WATER SUPPLY PIPE TO PUBLIC TOILETS FROM O.H. TANK (BY GRAVITY)
④	HOT WATER SUPPLY PIPE FROM CENTRALISED HOT WATER SYSTEM FOR GR. & 1ST FLOOR
④a	HOT WATER SUPPLY PIPE FROM CENTRALISED HOT WATER SYSTEM FOR 2ND & 3RD FLOOR
⑤	HOT WATER RETURN PIPE TO CENTRALISED HOT WATER SYSTEM FOR GR. & 1ST FLOOR
⑤a	HOT WATER RETURN PIPE TO CENTRALISED HOT WATER SYSTEM FOR 2ND & 3RD FLOOR
⑥	FLUSHING WATER SUPPLY PIPE FROM O.H. TANK FOR GR. & 1ST FLOOR
⑥a	FLUSHING WATER SUPPLY PIPE FROM O.H. TANK FOR 2ND & 3RD FLOOR
⑥b	FLUSHING WATER SUPPLY PIPE TO PUBLIC TOILETS FROM O.H. TANK (BY GRAVITY)
⑦	COLD RISER PIPE FOR O.H. TANK FILLING
⑧	FLUSHING RISER PIPE FOR O.H. TANK FILLING
⑨	1500 RAIN WATER VERTICAL PIPE
⑩	1000 RAIN WATER VERTICAL PIPE
	SOIL PIPE (RUN IN SUNKEN / CEILING)
	WASTE PIPE (RUN IN SUNKEN / CEILING)
	FLOOR TRAP 100X100MM ('P' TRAP) WITH S.S GRATING
	FLOOR DRAIN (100X50MM) WITH S.S GRATING
	MULTI TRAP (75X50MM) WITH S.S GRATING
WB TO FT	320 WASTE PIPE
FD TO FT	500 / 650 WASTE PIPE
FT TO MAIN PIPE	1000 WASTE PIPE
UT TO MAIN PIPE	1000 SOIL PIPE
WC TO MAIN PIPE	1000 SOIL PIPE

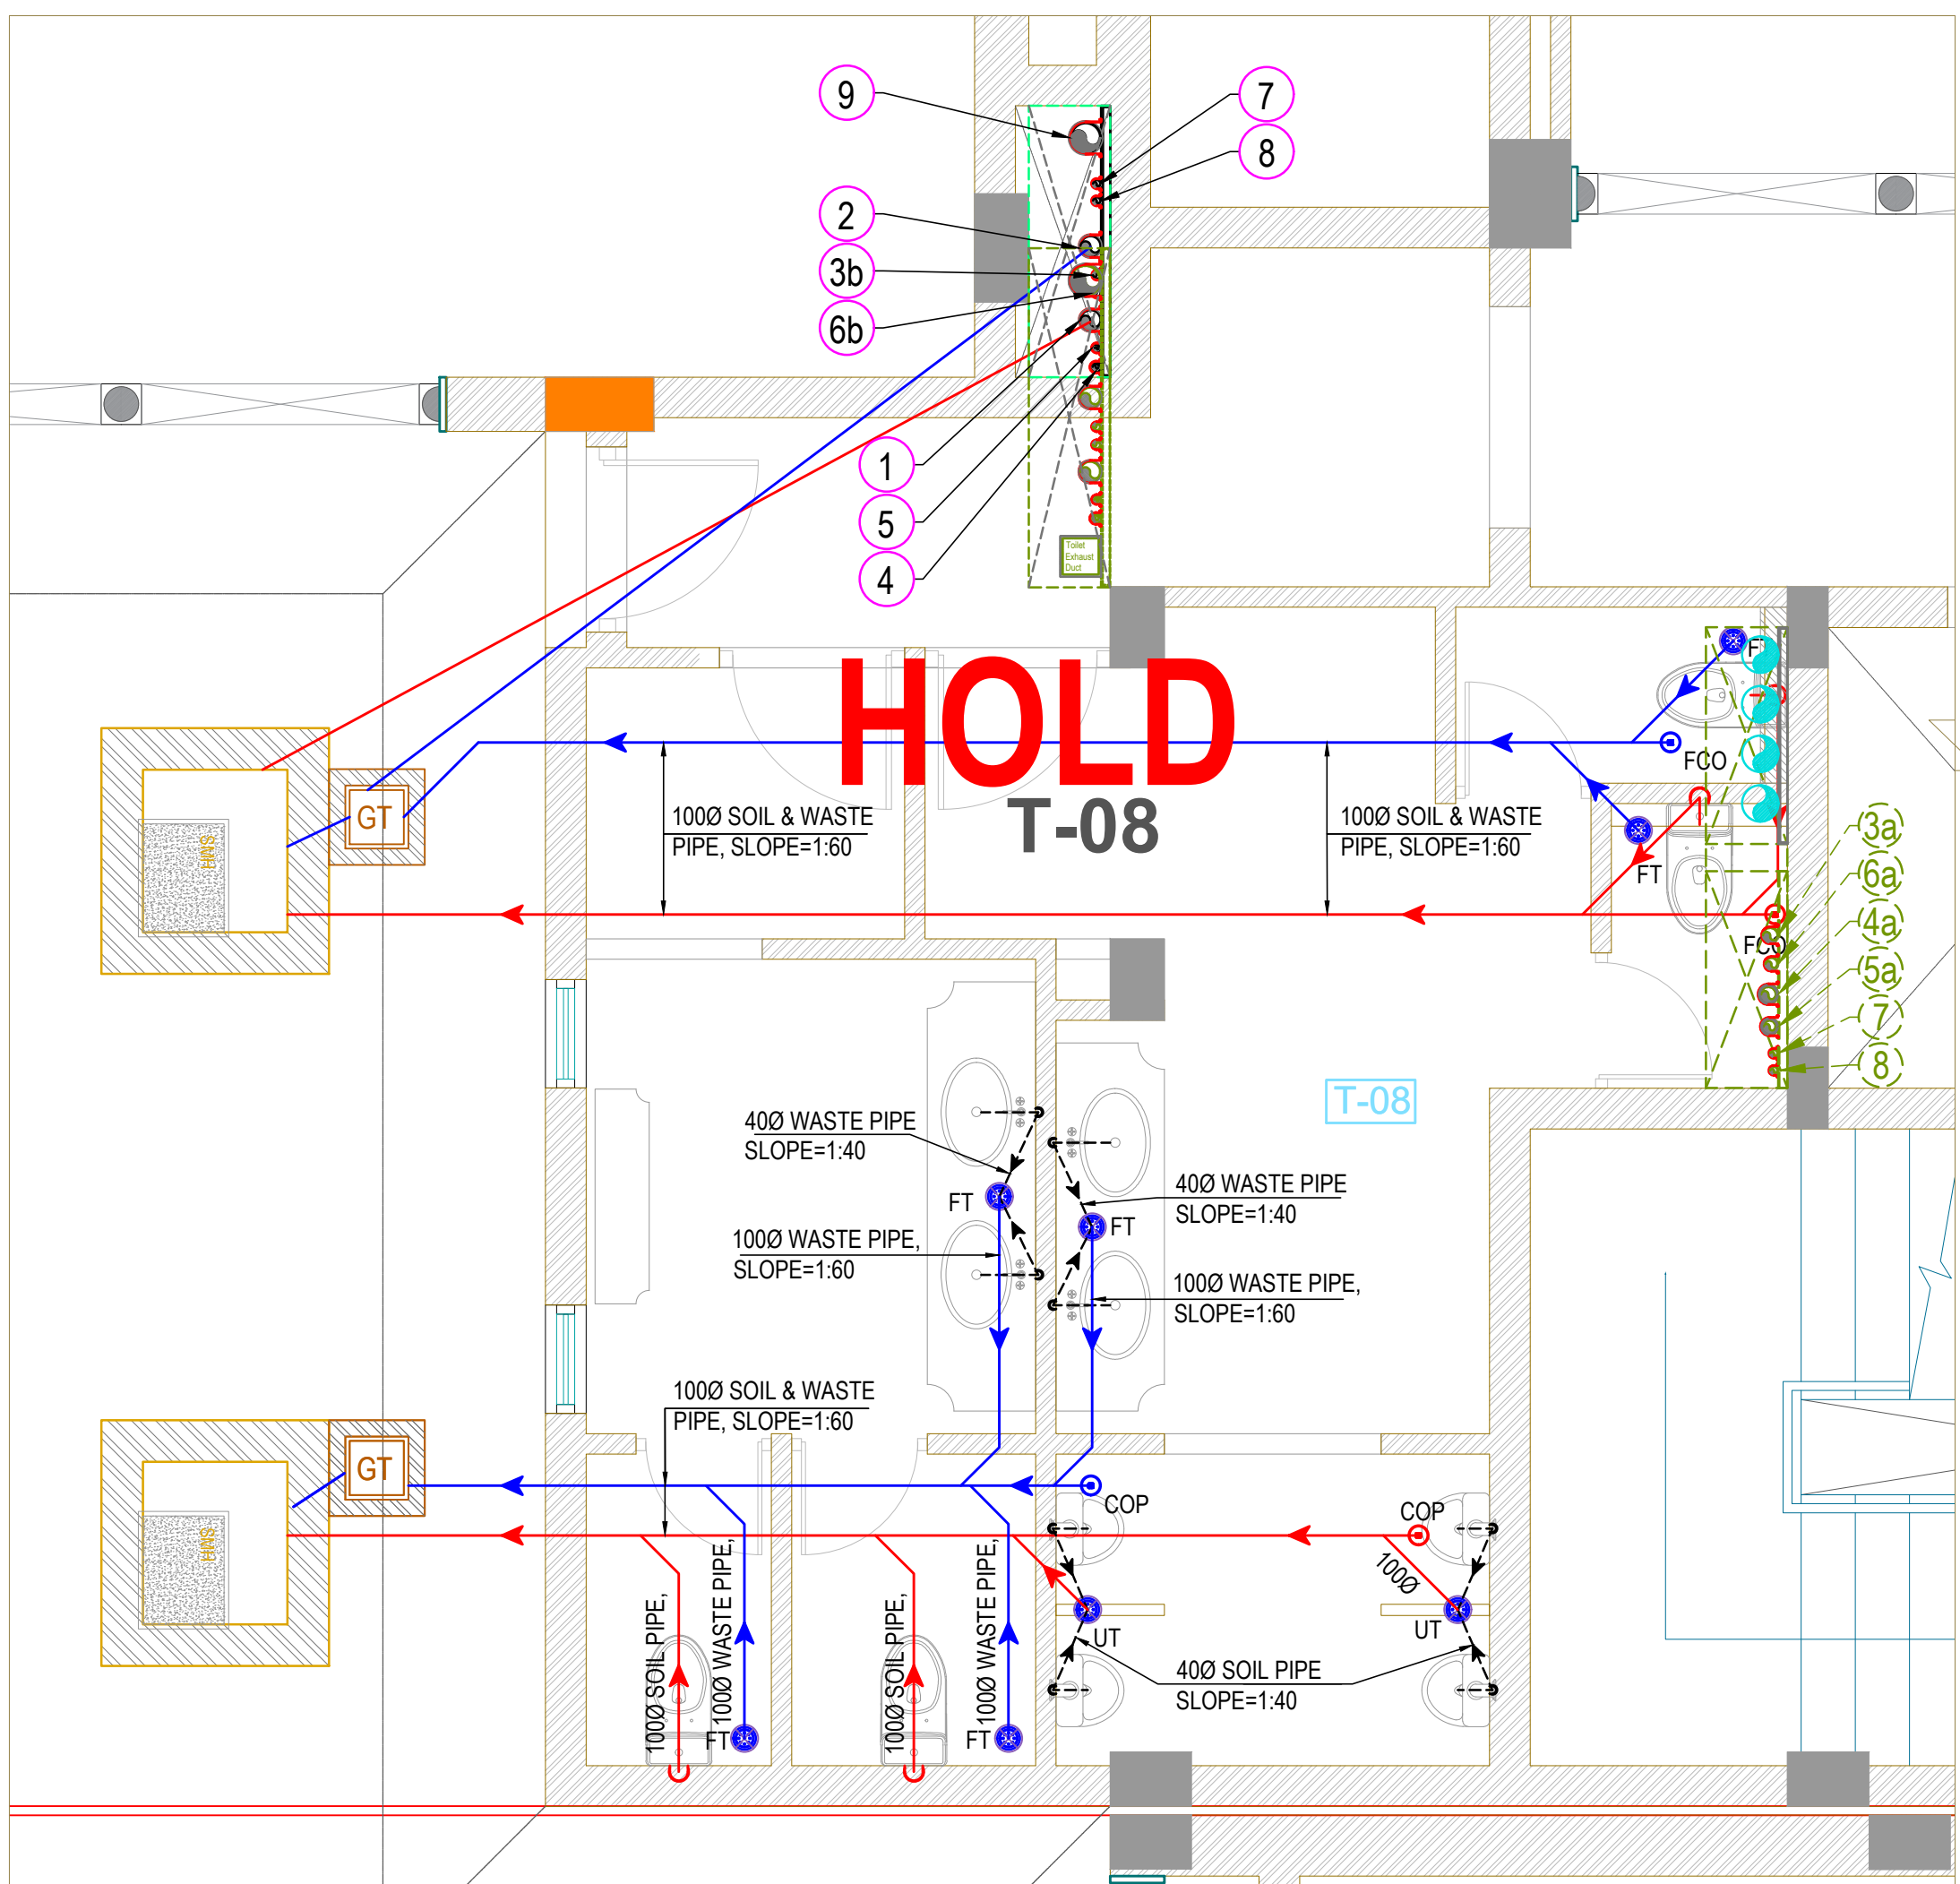

TOILET-08 FOR GROUND FLOOR (DRAINAGE LAYOUT)

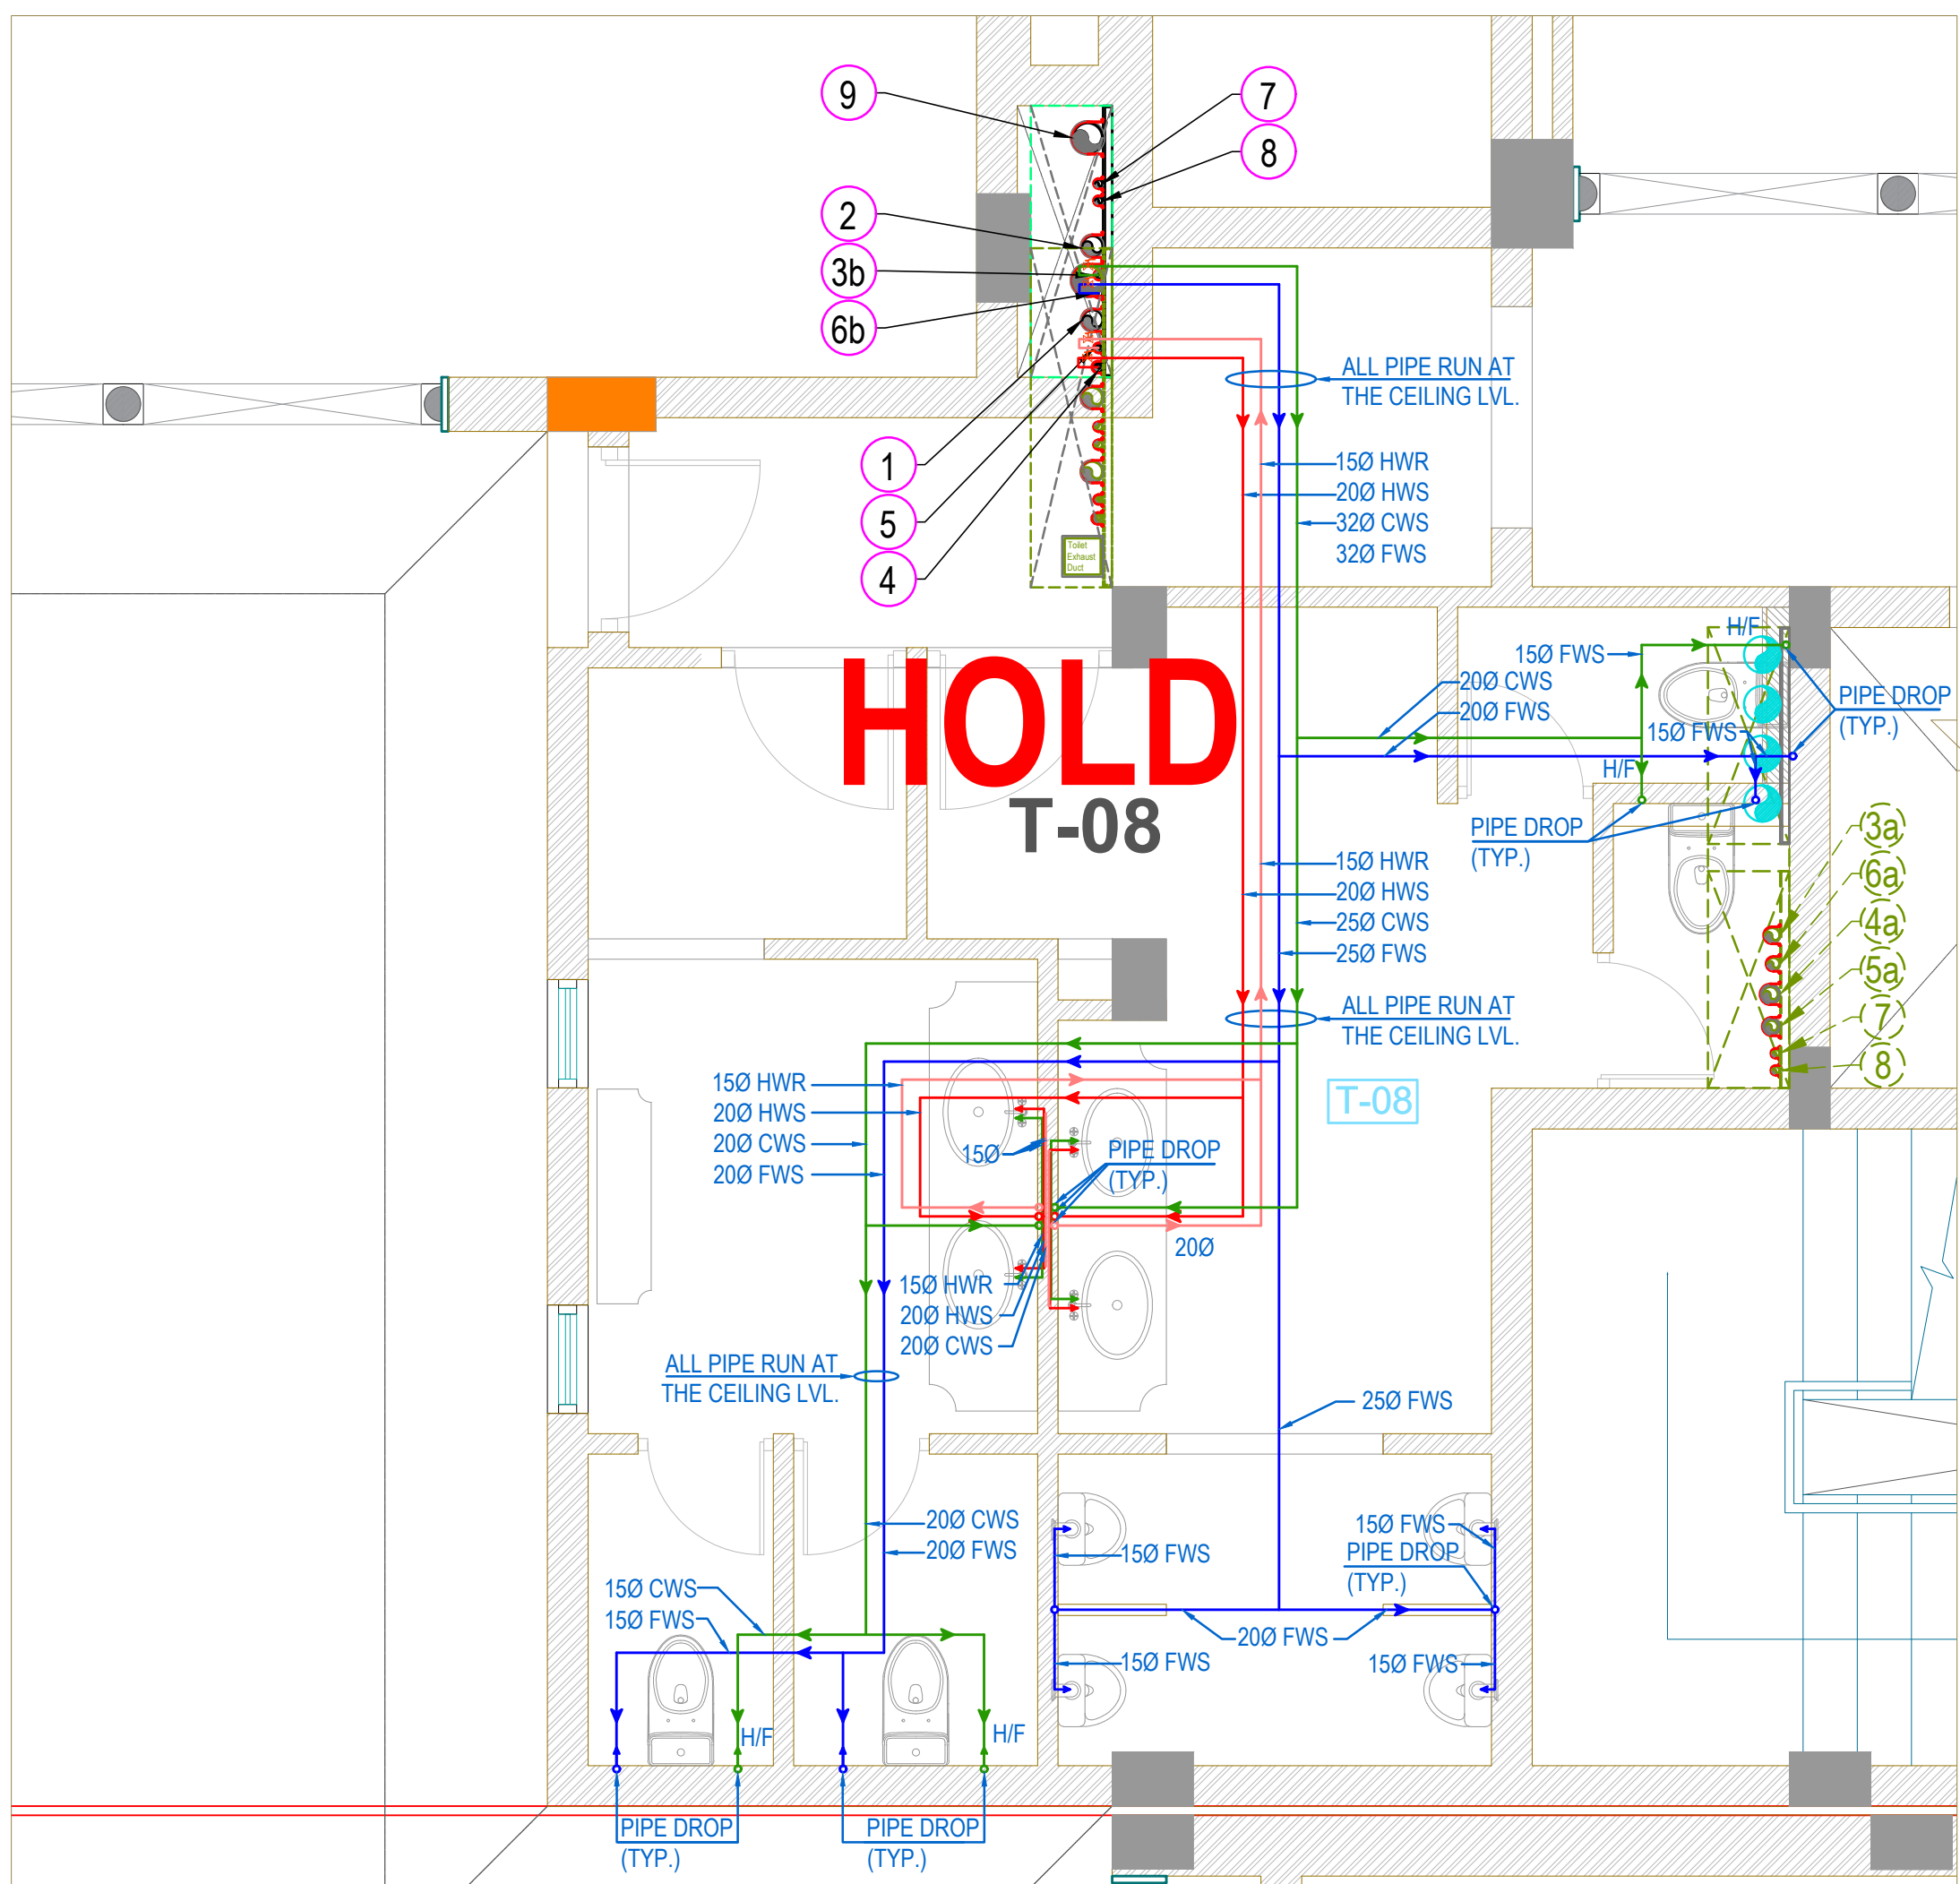

TOILET-08 FOR GROUND FLOOR (WATER SUPPLY LAYOUT)

G.F.C (ADVANCE COPY)		
REVISION NO.- R0		
MEPF CONSULTANT: NEWTECH CONSULTING ENGINEERS C-137/1, 3rd Floor, Vijay Vihar Phase - II (Rohini Sec.-1), New Delhi - 110085, (India)		
ARCHITECT: RAVI KUMAR GUPTA CA/837739 L-1, KRISHNA MARG, C- SCHEME, JAIPUR (302001), RAJASTHAN. PH.0141-2360825 E-Mail-ravigupta_15@yahoo.com		
DRAWING TITLE: TOILET DETAILS FOR GROUND FLOOR (DRAINAGE & WATER SUPPLY LAYOUT)		
PROJECT: LAXMI PALACE AT JAIPUR		
DRAWN BY: SONU KUMAR	NORTH:	DATE: 19-02-2024
CHECKED BY: VIJAY KUMAR	DRAWING NO.: PL-TD-GF-02	SCALE: 1:50
NOTES: THE COPYRIGHT AND PROPERTY OF THIS DESIGN AND DRAWING BELONGS TO RAVI KUMAR GUPTA. IT MUST NOT BE COPIED OR REPRODUCED IN ANY MANNER WITHOUT THEIR WRITTEN CONSENT. A LEGAL ACTION AS PER LAW MAY BE INITIATED AGAINST THE OFFENDER.		
STRUCTURE CO. : SANRACHANA		