


LEGEND - ELECTRICAL

| S.NO. | SYMBOL | DESCRIPTION OF ITEM     |
|-------|--------|-------------------------|
| 1     |        | CEILING FAN             |
| 2     |        | SWITCH BOARD            |
| 3     |        | MASTER SWITCH           |
| 4     |        | CEILING LIGHT           |
| 6     |        | SWITCH SOCKET 6A.       |
| 7     |        | SWITCH SOCKET 16A.      |
| 9     |        | TELEPHONE               |
| 10    |        | DISTRIBUTION BOX        |
| 11    |        | TUBE LIGHT              |
| 12    |        | AC POINTS               |
| 13    |        | UPLIGHTER (FLOOR LIGHT) |
| 14    |        | SPRINKLER               |
| 15    |        | SMOKE DETECTOR          |
| 16    |        | AC                      |
| 17    |        | speakers                |

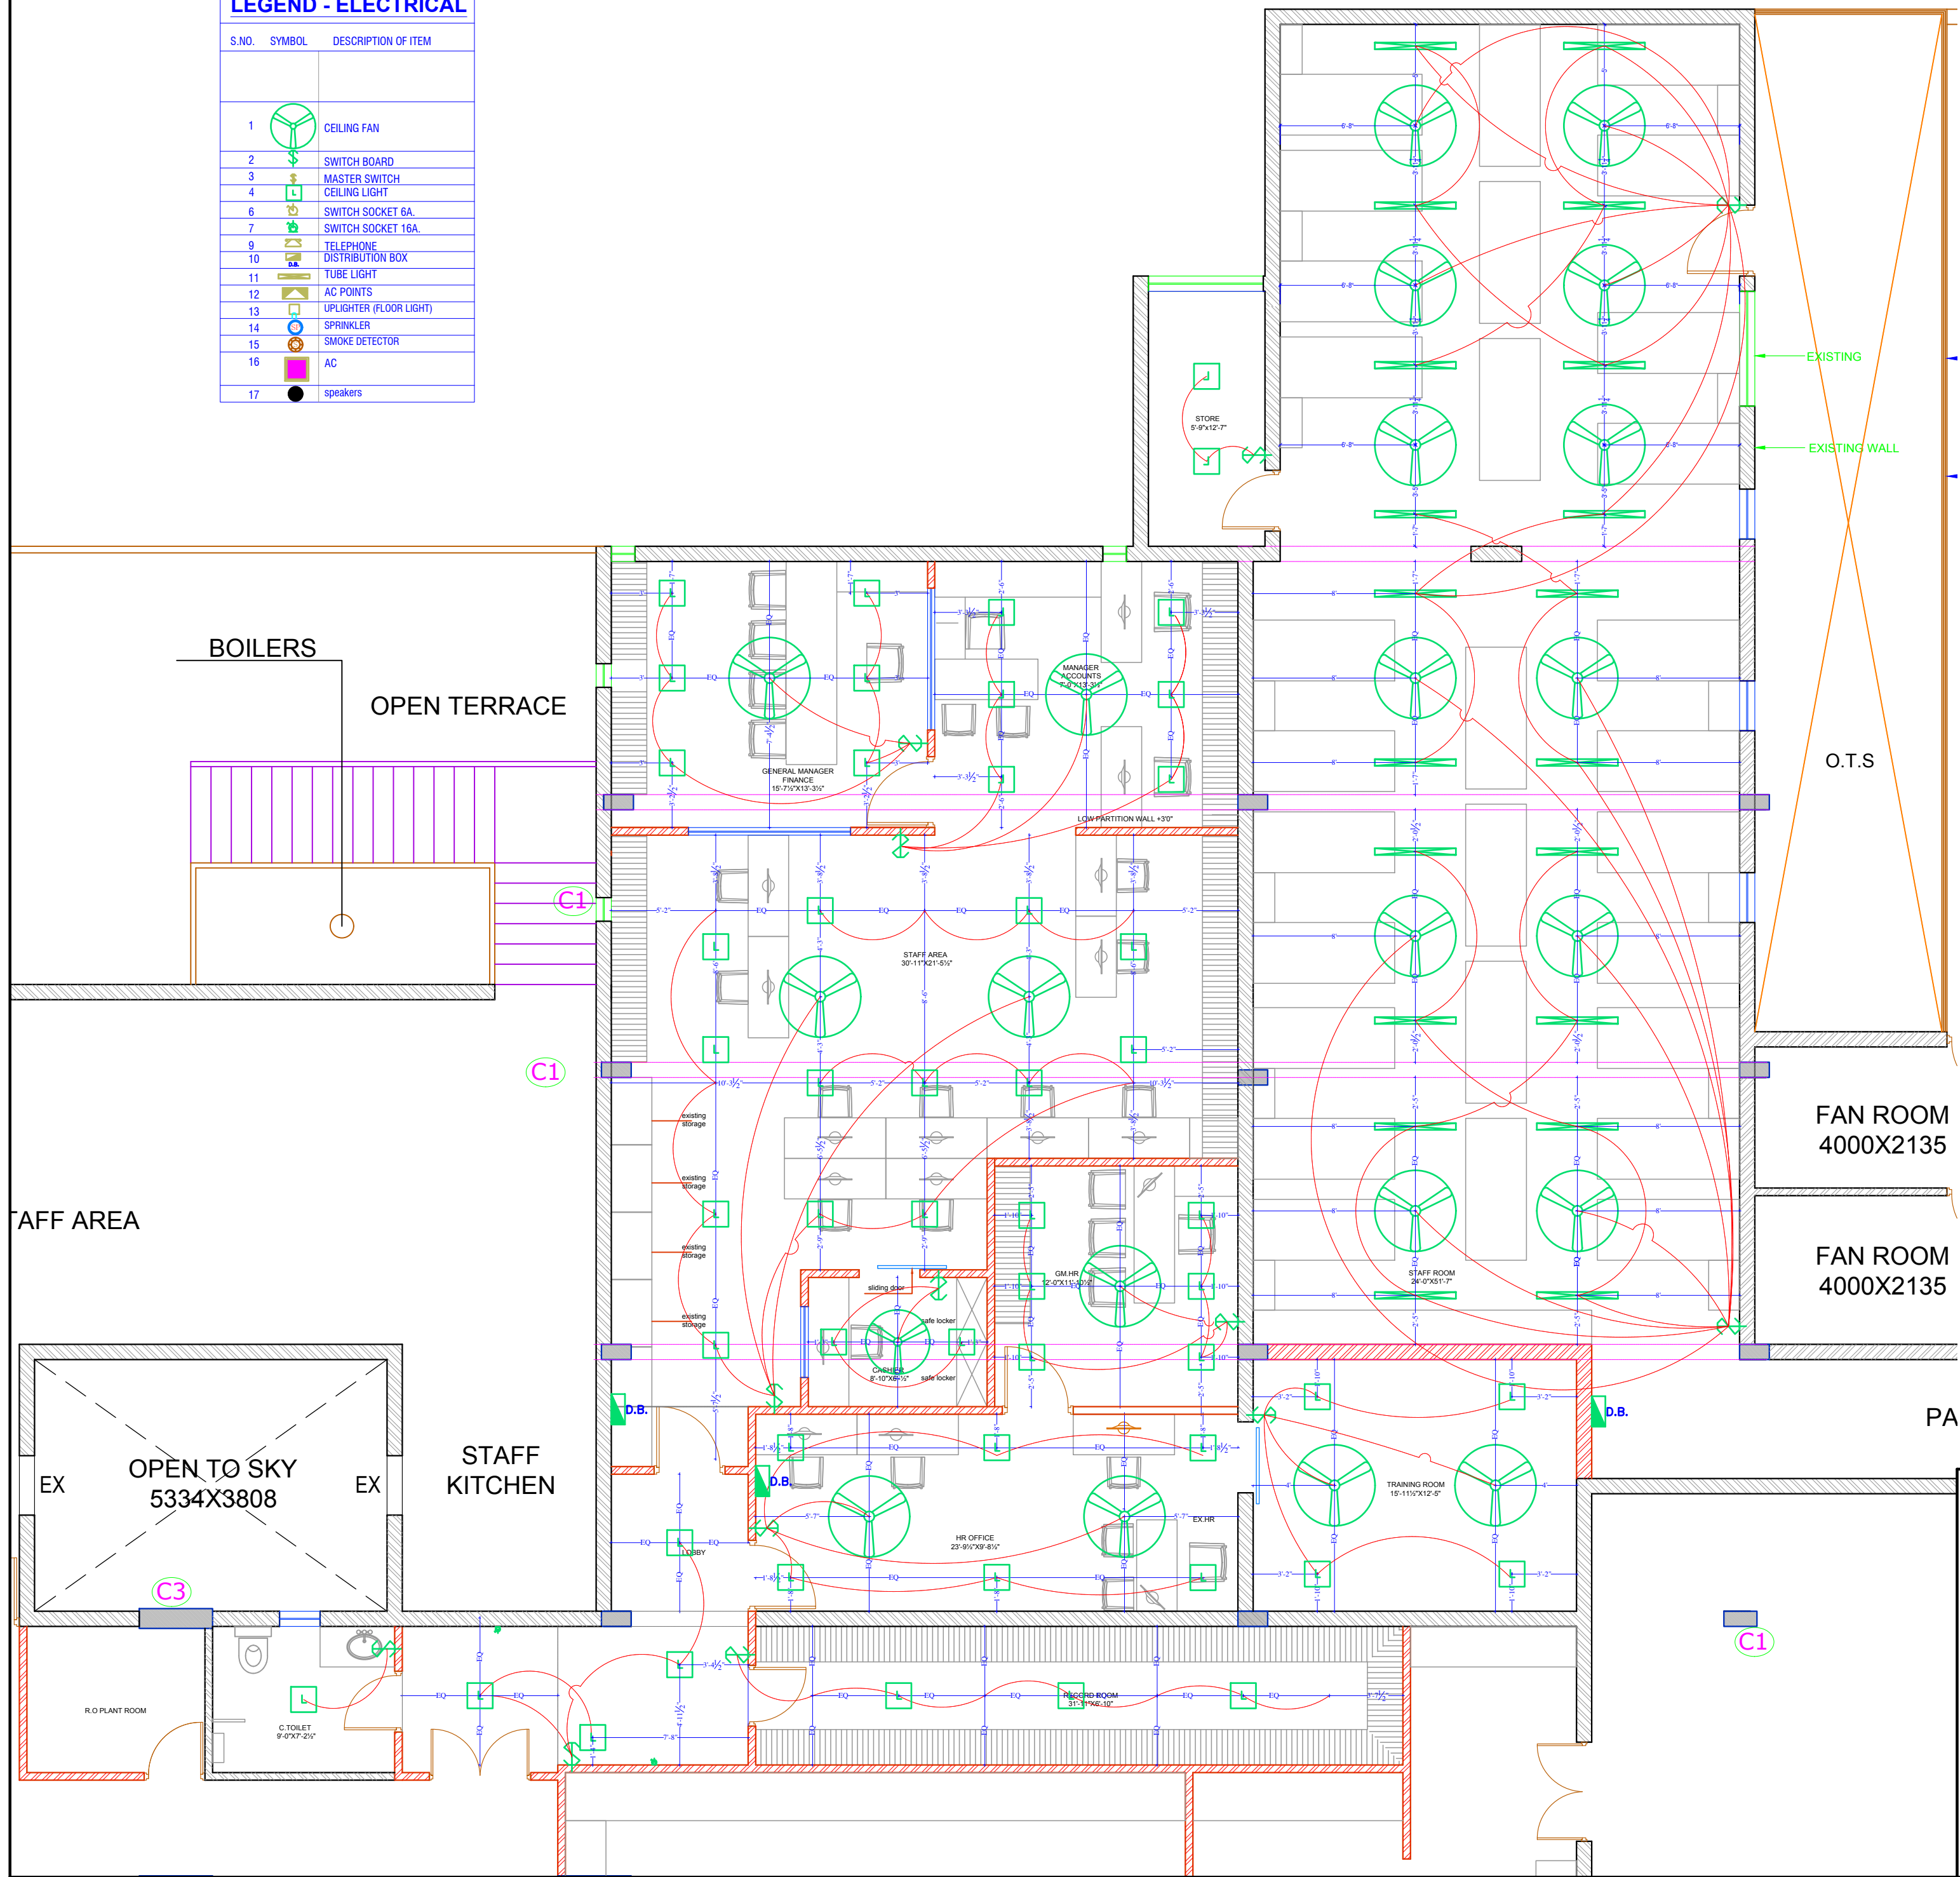

ARCHITECT:  
**NEERAV GUPTA**  
L-1, KRISHNA MARG, C-SCHEME,  
JAIPUR (302001), RAJASTHAN.  
PH 0141-2360825  
E-Mail-architect\_neeravgupta@yahoo.com

PROJECT:  
**CLARKS**

DRAWING TITLE:  
ACCOUNTS AND HR  
CEILING ELECTRICAL PLAN

DRAWN BY: RAHUL  
SCALE: N.T.S.  
DATE: 6-10-2018

CHECKED BY: NEERAV GUPTA  
SHEET NO.: C/AV/AC/EL/01

NOTES:  
THE COPYRIGHT AND PROPERTY OF THIS DESIGN AND DRAWING  
BELONGS TO NEERAV GUPTA. IT MUST NOT BE COPIED OR  
REPRODUCED IN ANY MANNER WITHOUT THEIR WRITTEN  
CONSENT. A LEGAL ACTION AS PER LAW MAY BE INITIATED  
AGAINST THE OFFENDER.