


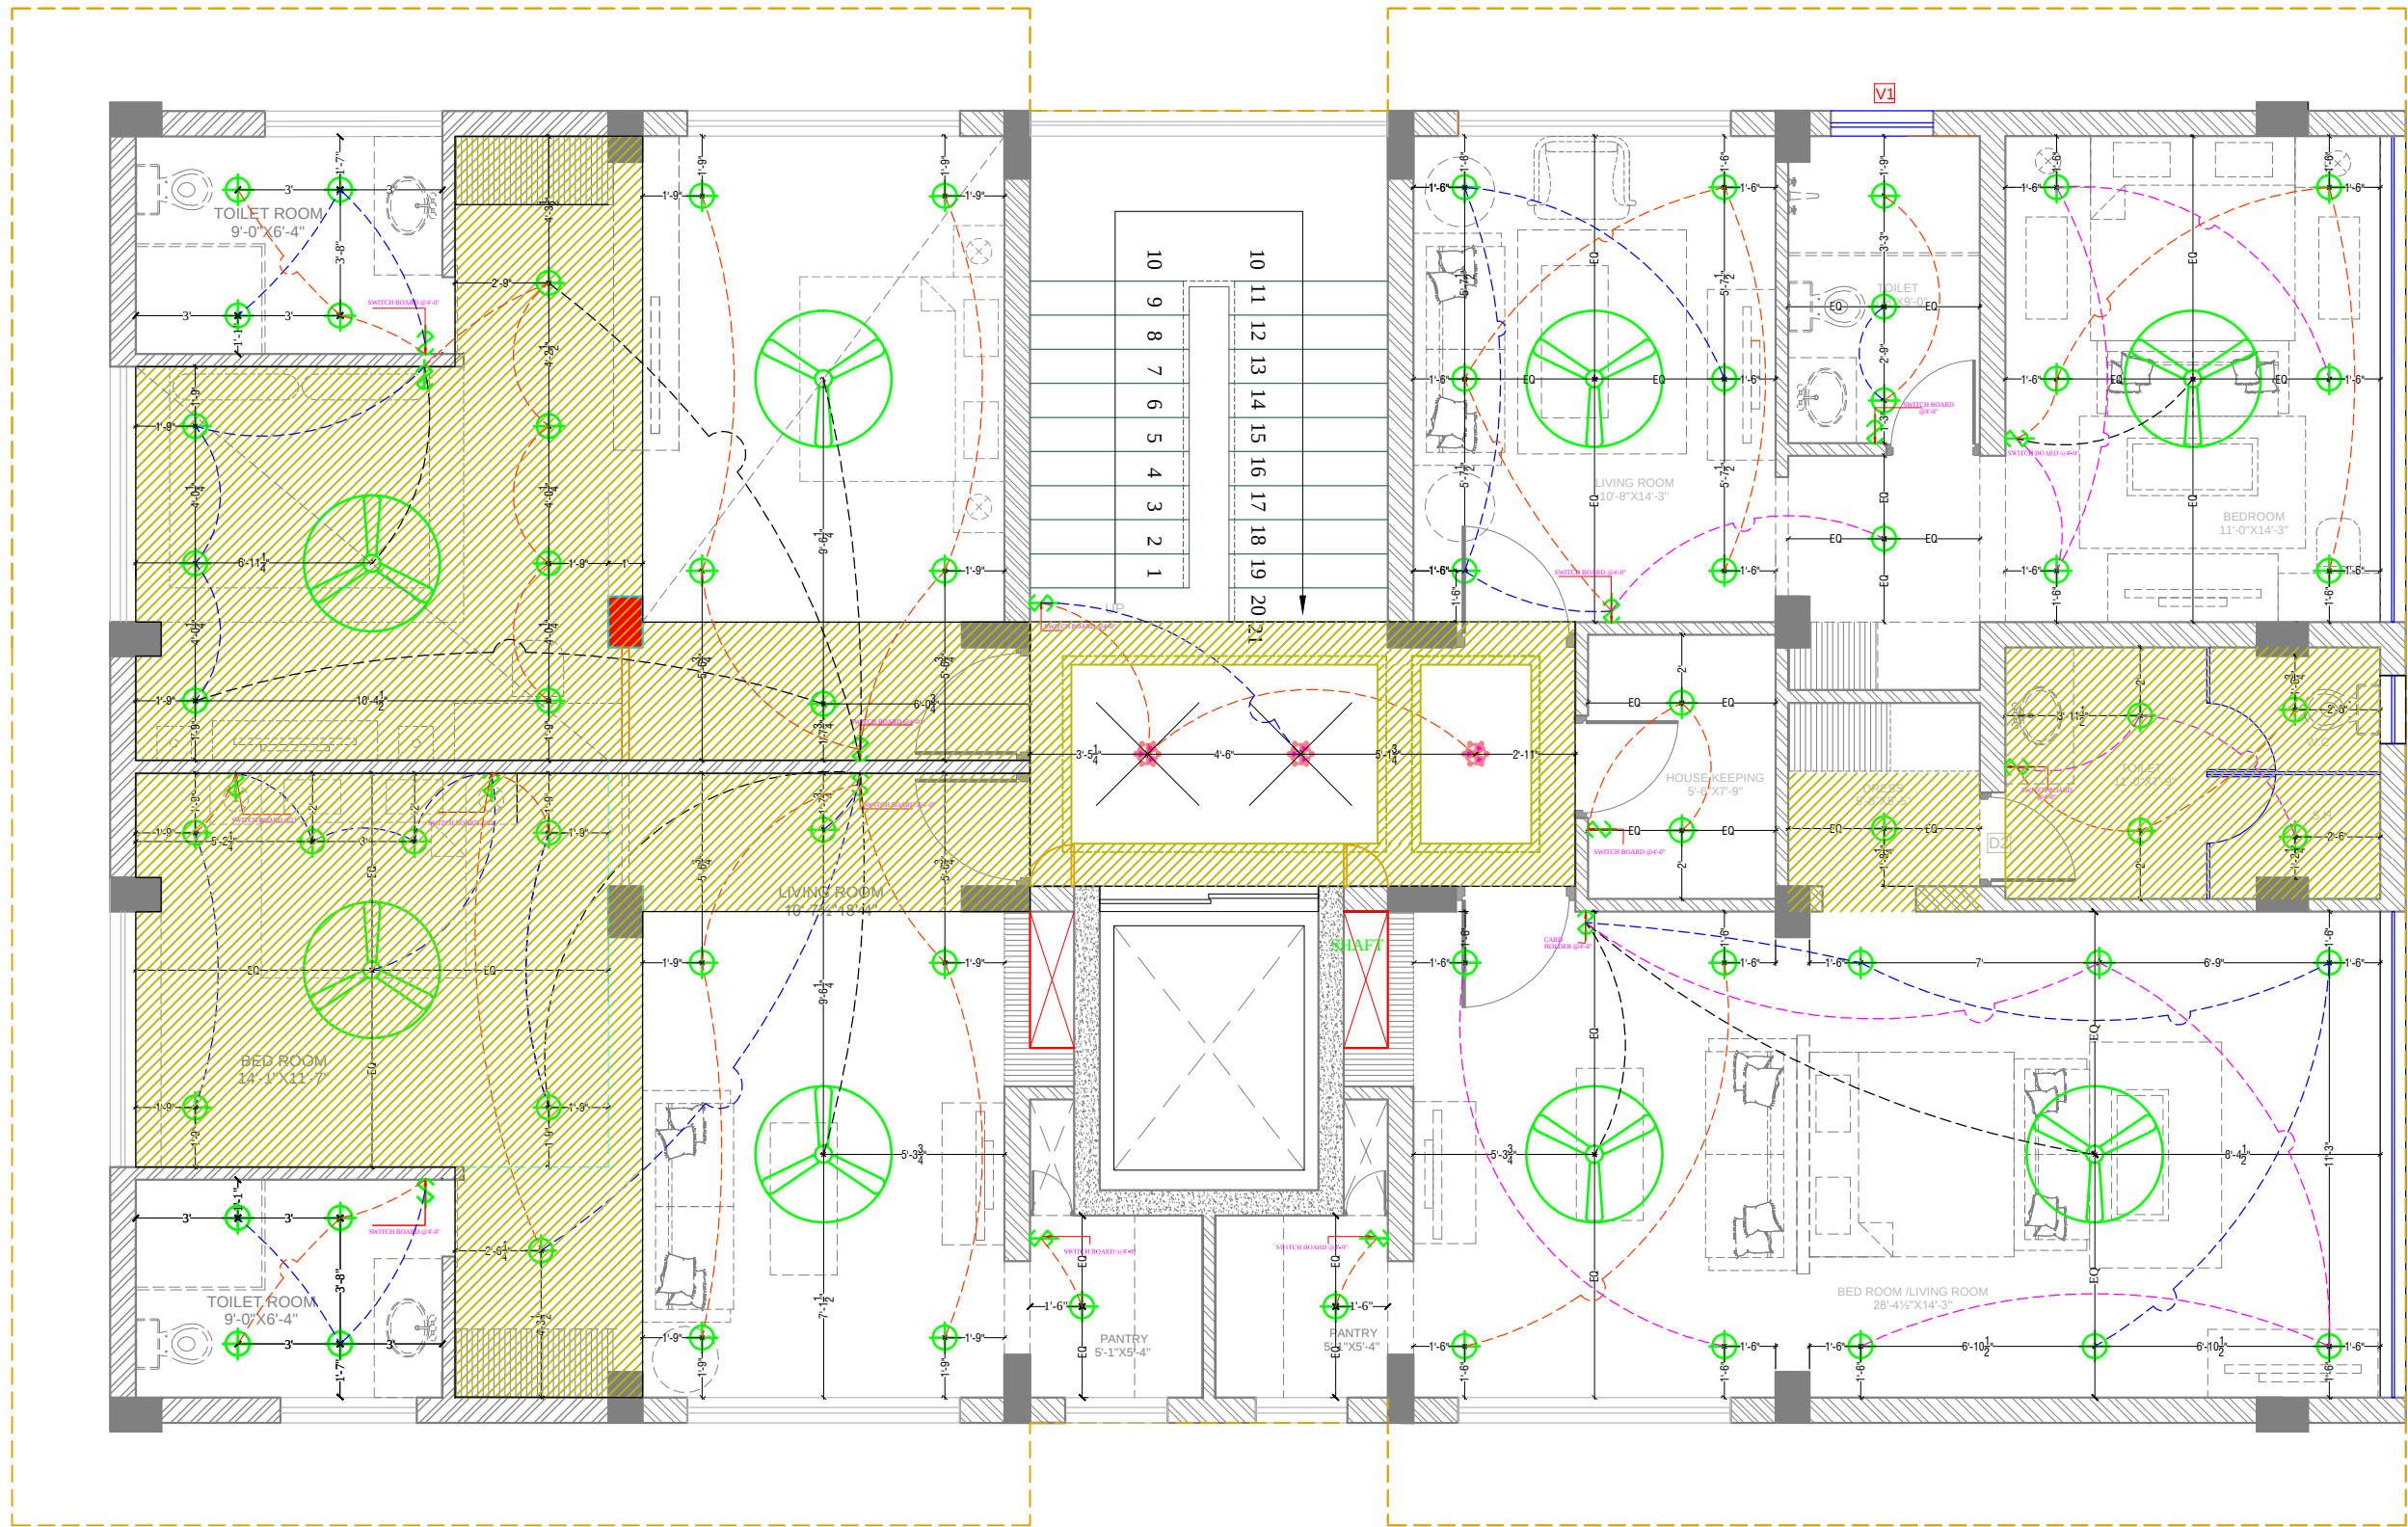

LEGEND - ELECTRICAL

S.NO.	SYMBOL	DESCRIPTION OF ITEM	HT.
1		CEILING FAN	
2		SWITCH BOARD	
3		BRACKET LIGHT	7'-0"
4		RETROFIT CFL INTEGRATED	
5		SWITCH SOCKET 6A.	
6		SWITCH SOCKET 16A.	
7		ANTENNA	
8		TELEPHONE	
9		CHANDELLIER	
10		DISTRIBUTION BOX	
11		PICTURE LIGHT	7'-0"
12		HANGING LIGHT	
13		CHANDELLIER	
14		UPLIGHTERS	
15		DOWNLIGHTERS	
16		DONOT DISTURB (DND)	
17		CARD HOLDER	
18		AIR CONDITIONER	
19		FOOT LIGHT	

GROUND FLOOR CEILING ELECTRICAL PLAN

ARCHITECT:
NEERAV GUPTA
CA/2009/44766
L-1, KRISHNA MARG, C- SCHEME,
JAIPUR (302001), RAJASTHAN PH:0141-2368825
E-Mail:architect_neeravgupta@yahoo.com

PROJECT:
HOTEL CLARKS

DRAWING TITLE:
**ARCHITECTURAL
GROUND CEILING
ELECTRICAL PLAN**

DRAWN BY: RAHUL SCALE: N.T.S DATE: 24-12-2018

CHECKED BY: NEERAV GUPTA DRAWING NO: 30/C/AR/02

NOTES:
THE COPYRIGHT AND PROPERTY OF THIS DESIGN AND DRAWING BELONGS TO HANU KUMAR GUPTA. IT MUST NOT BE COPIED OR REPRODUCED IN ANY MANNER WITHOUT THEIR WRITTEN CONSENT. A LEGAL ACTION AS PER LAW MAY BE INITIATED AGAINST THE OFFENDER.