


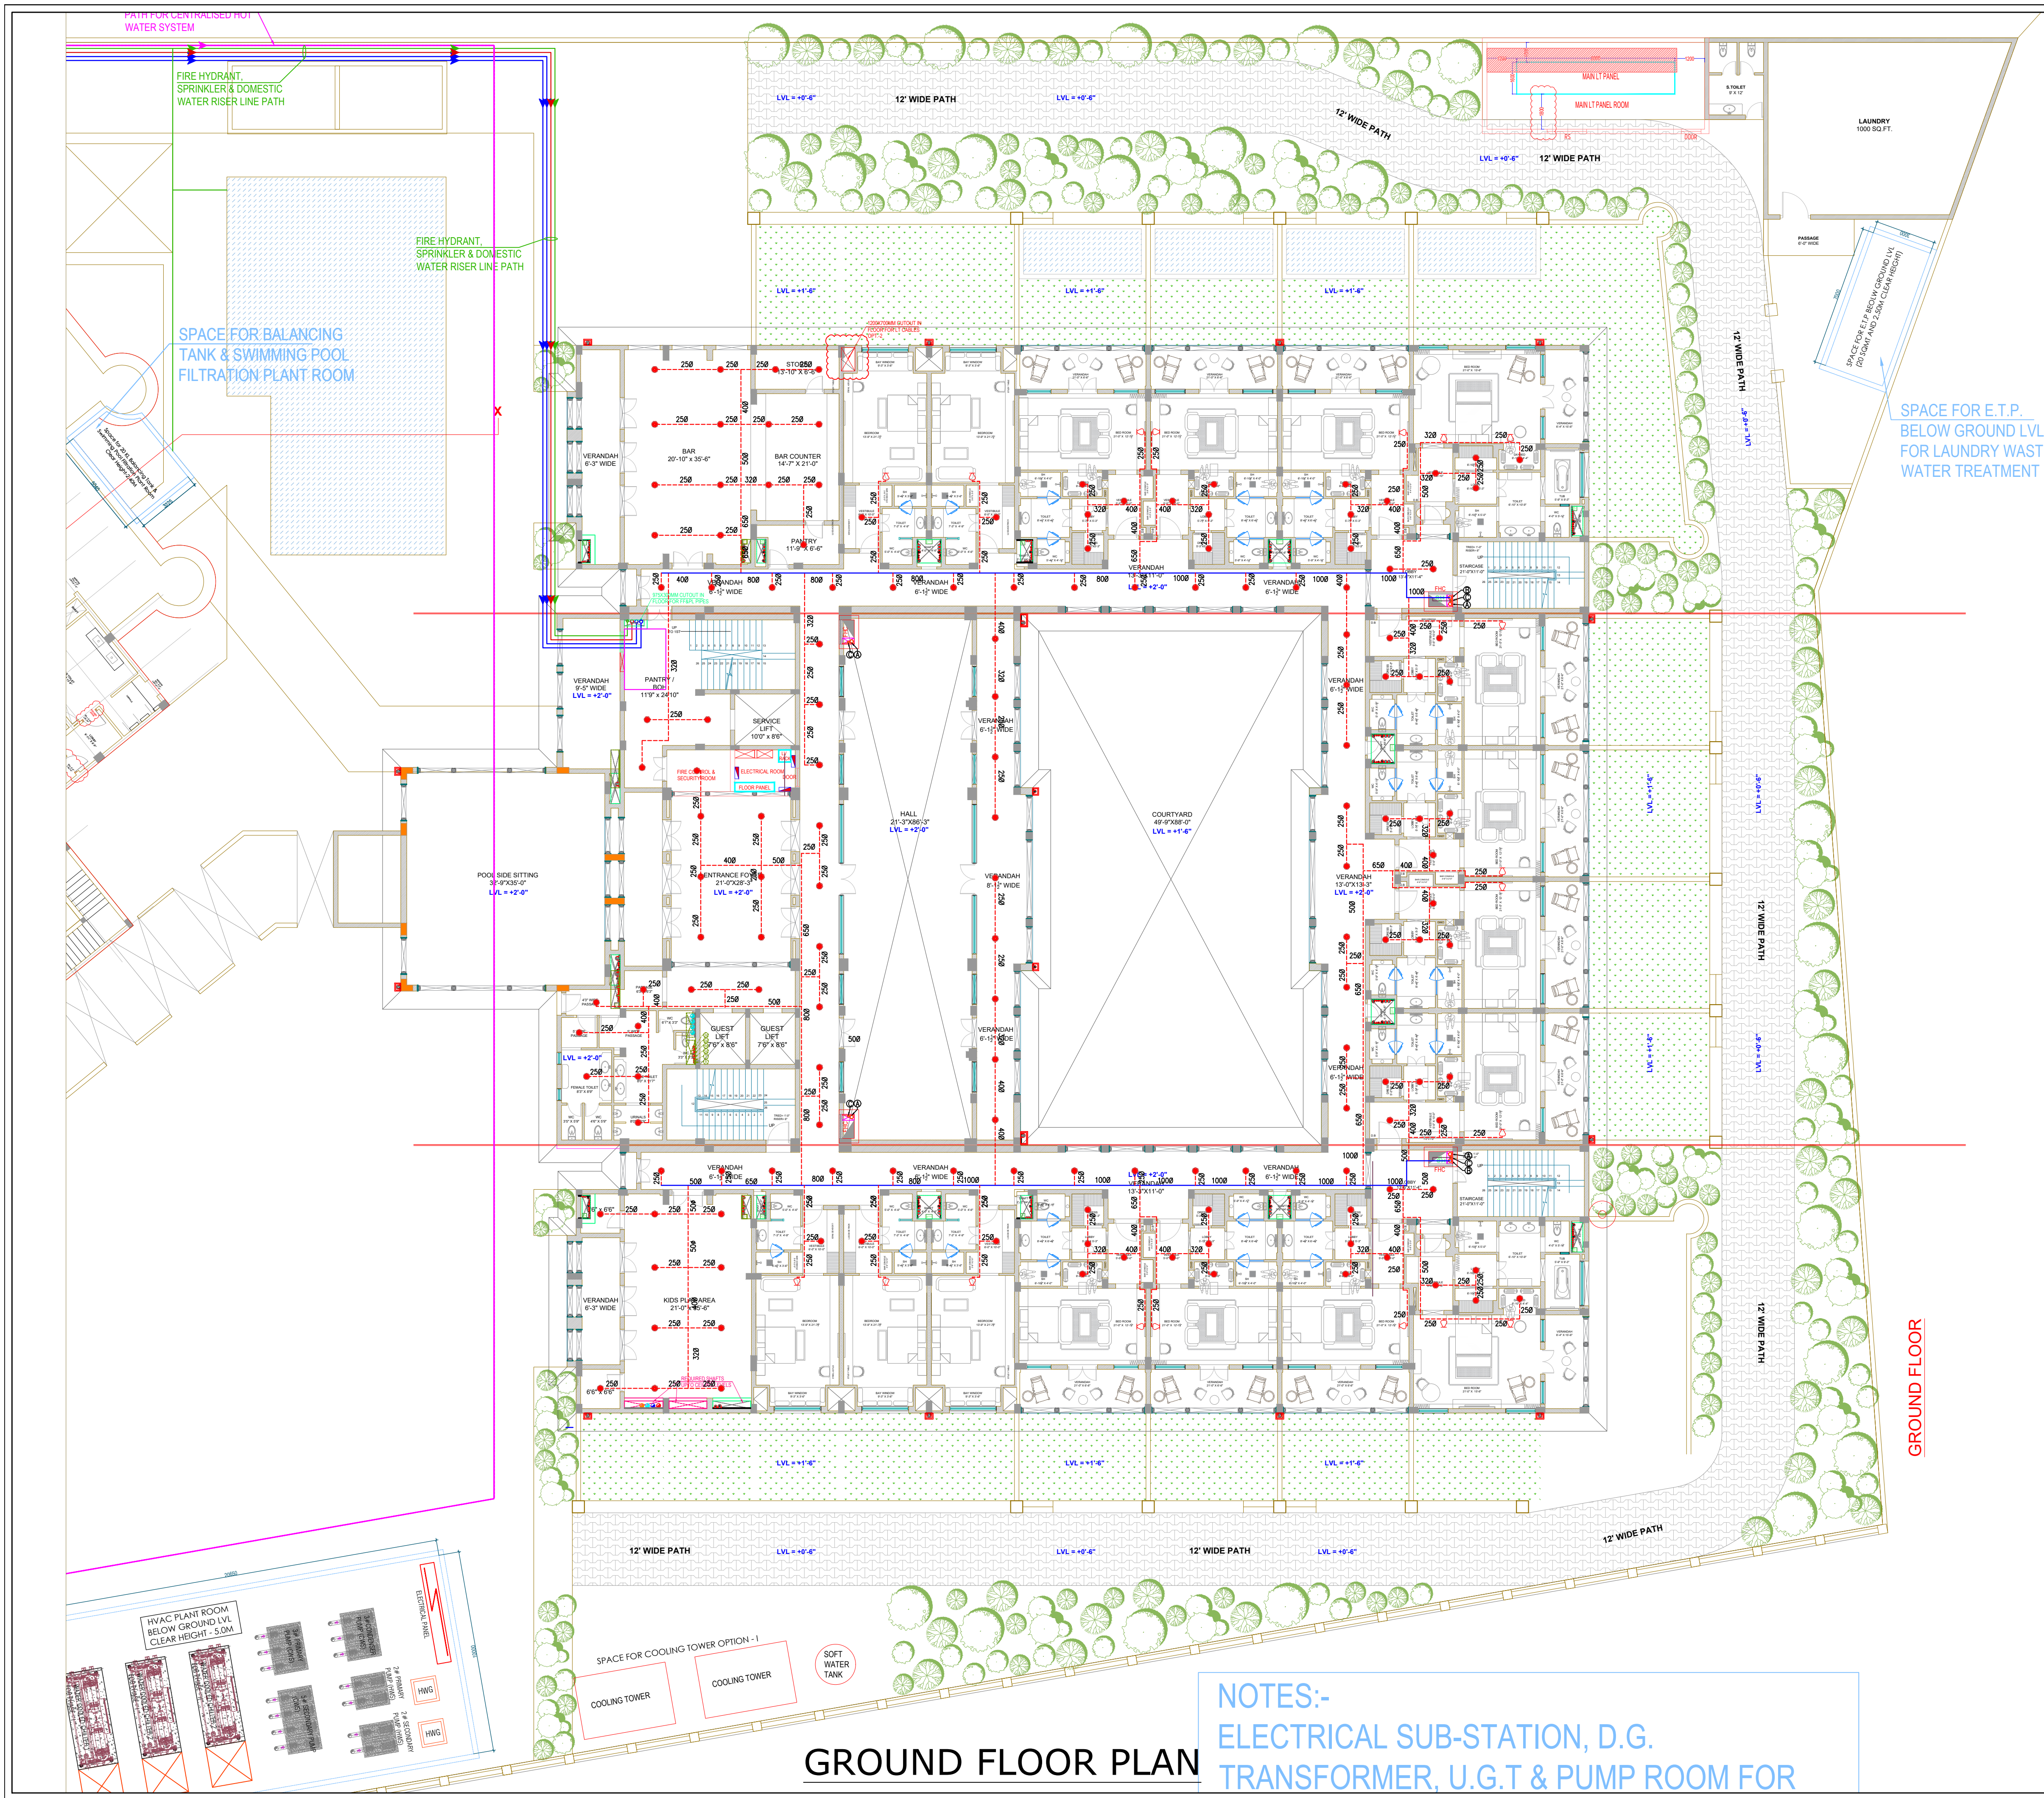

LEGENDS FOR FIRE FIGHTING:-	
(A)	1000 FIRE HYDRANT RISER PIPE
(B)	1500 FIRE SPRINKLER RISER PIPE
(C)	650 SPRINKLER DRAIN PIPE
●	PENDENT SPRINKLER
■	SIDE WALL SPRINKLER
□	FLOW SWITCH
□	ISOLATION VALVE
---	SPRINKLER BRANCH PIPE
---	MAIN SPRINKLER HEADER PIPE
F.H.C FIRE HOSE CABINET CONSISTING:-	
1. 1NO. 63mmØ LANDING VALVE	
2. 1NO. 20mmØ 36.5M LONG HOSE REEL WITH DRUM	
3. 1NO. 63mmØ BRANCH PIPE	
4. 2NOS. 63mmØ R.R.L HOSE PIPE	
5. 1NO. FIRE MEN AXE	
6. 2NO. FIRE EXTINGUISHER	

SCHEMATIC DRAWINGS

REVISION NO.- R0

MEPF CONSULTANT:
NEWTECH CONSULTING ENGINEERS
C-137/1, 3rd Floor, Vijay Vihar Phase - II
(Rohini Sec.-1), New Delhi - 110085. (India)

ARCHITECT:
RAVI KUMAR GUPTA
CA/83/7739
L-1, KRISHNA MARG, C- SCHEME,
JAIPUR (302001), RAJASTHAN.
PH.0141-2360825 E-Mail-ravigupta_15@yahoo.com

DRAWING TITLE:
**GROUND FLOOR PLAN
(FIRE FIGHTING LAYOUT)**

PROJECT:
LAXMI PALACE / HOTEL

DRAWN BY:	NORTH:	DATE:
SONU KUMAR		09-01-2024
CHECKED BY:	DRAWING NO.:	SCALE:
VIJAY KUMAR	FF-01	1:100

NOTES:
THE COPYRIGHT AND PROPERTY OF THIS DESIGN AND DRAWING
BELONGS TO RAVI KUMAR GUPTA. IT MUST NOT BE COPIED OR
REPRODUCED IN ANY MANNER WITHOUT THEIR WRITTEN
CONSENT. A LEGAL ACTION AS PER LAW MAY BE INITIATED
AGAINST THE OFFENDER.

STRUCTURE CO. :
SANRACHANA

NOTES:-
ELECTRICAL SUB-STATION, D.G.
TRANSFORMER, U.G.T & PUMP ROOM FOR

GROUND FLOOR PLAN