


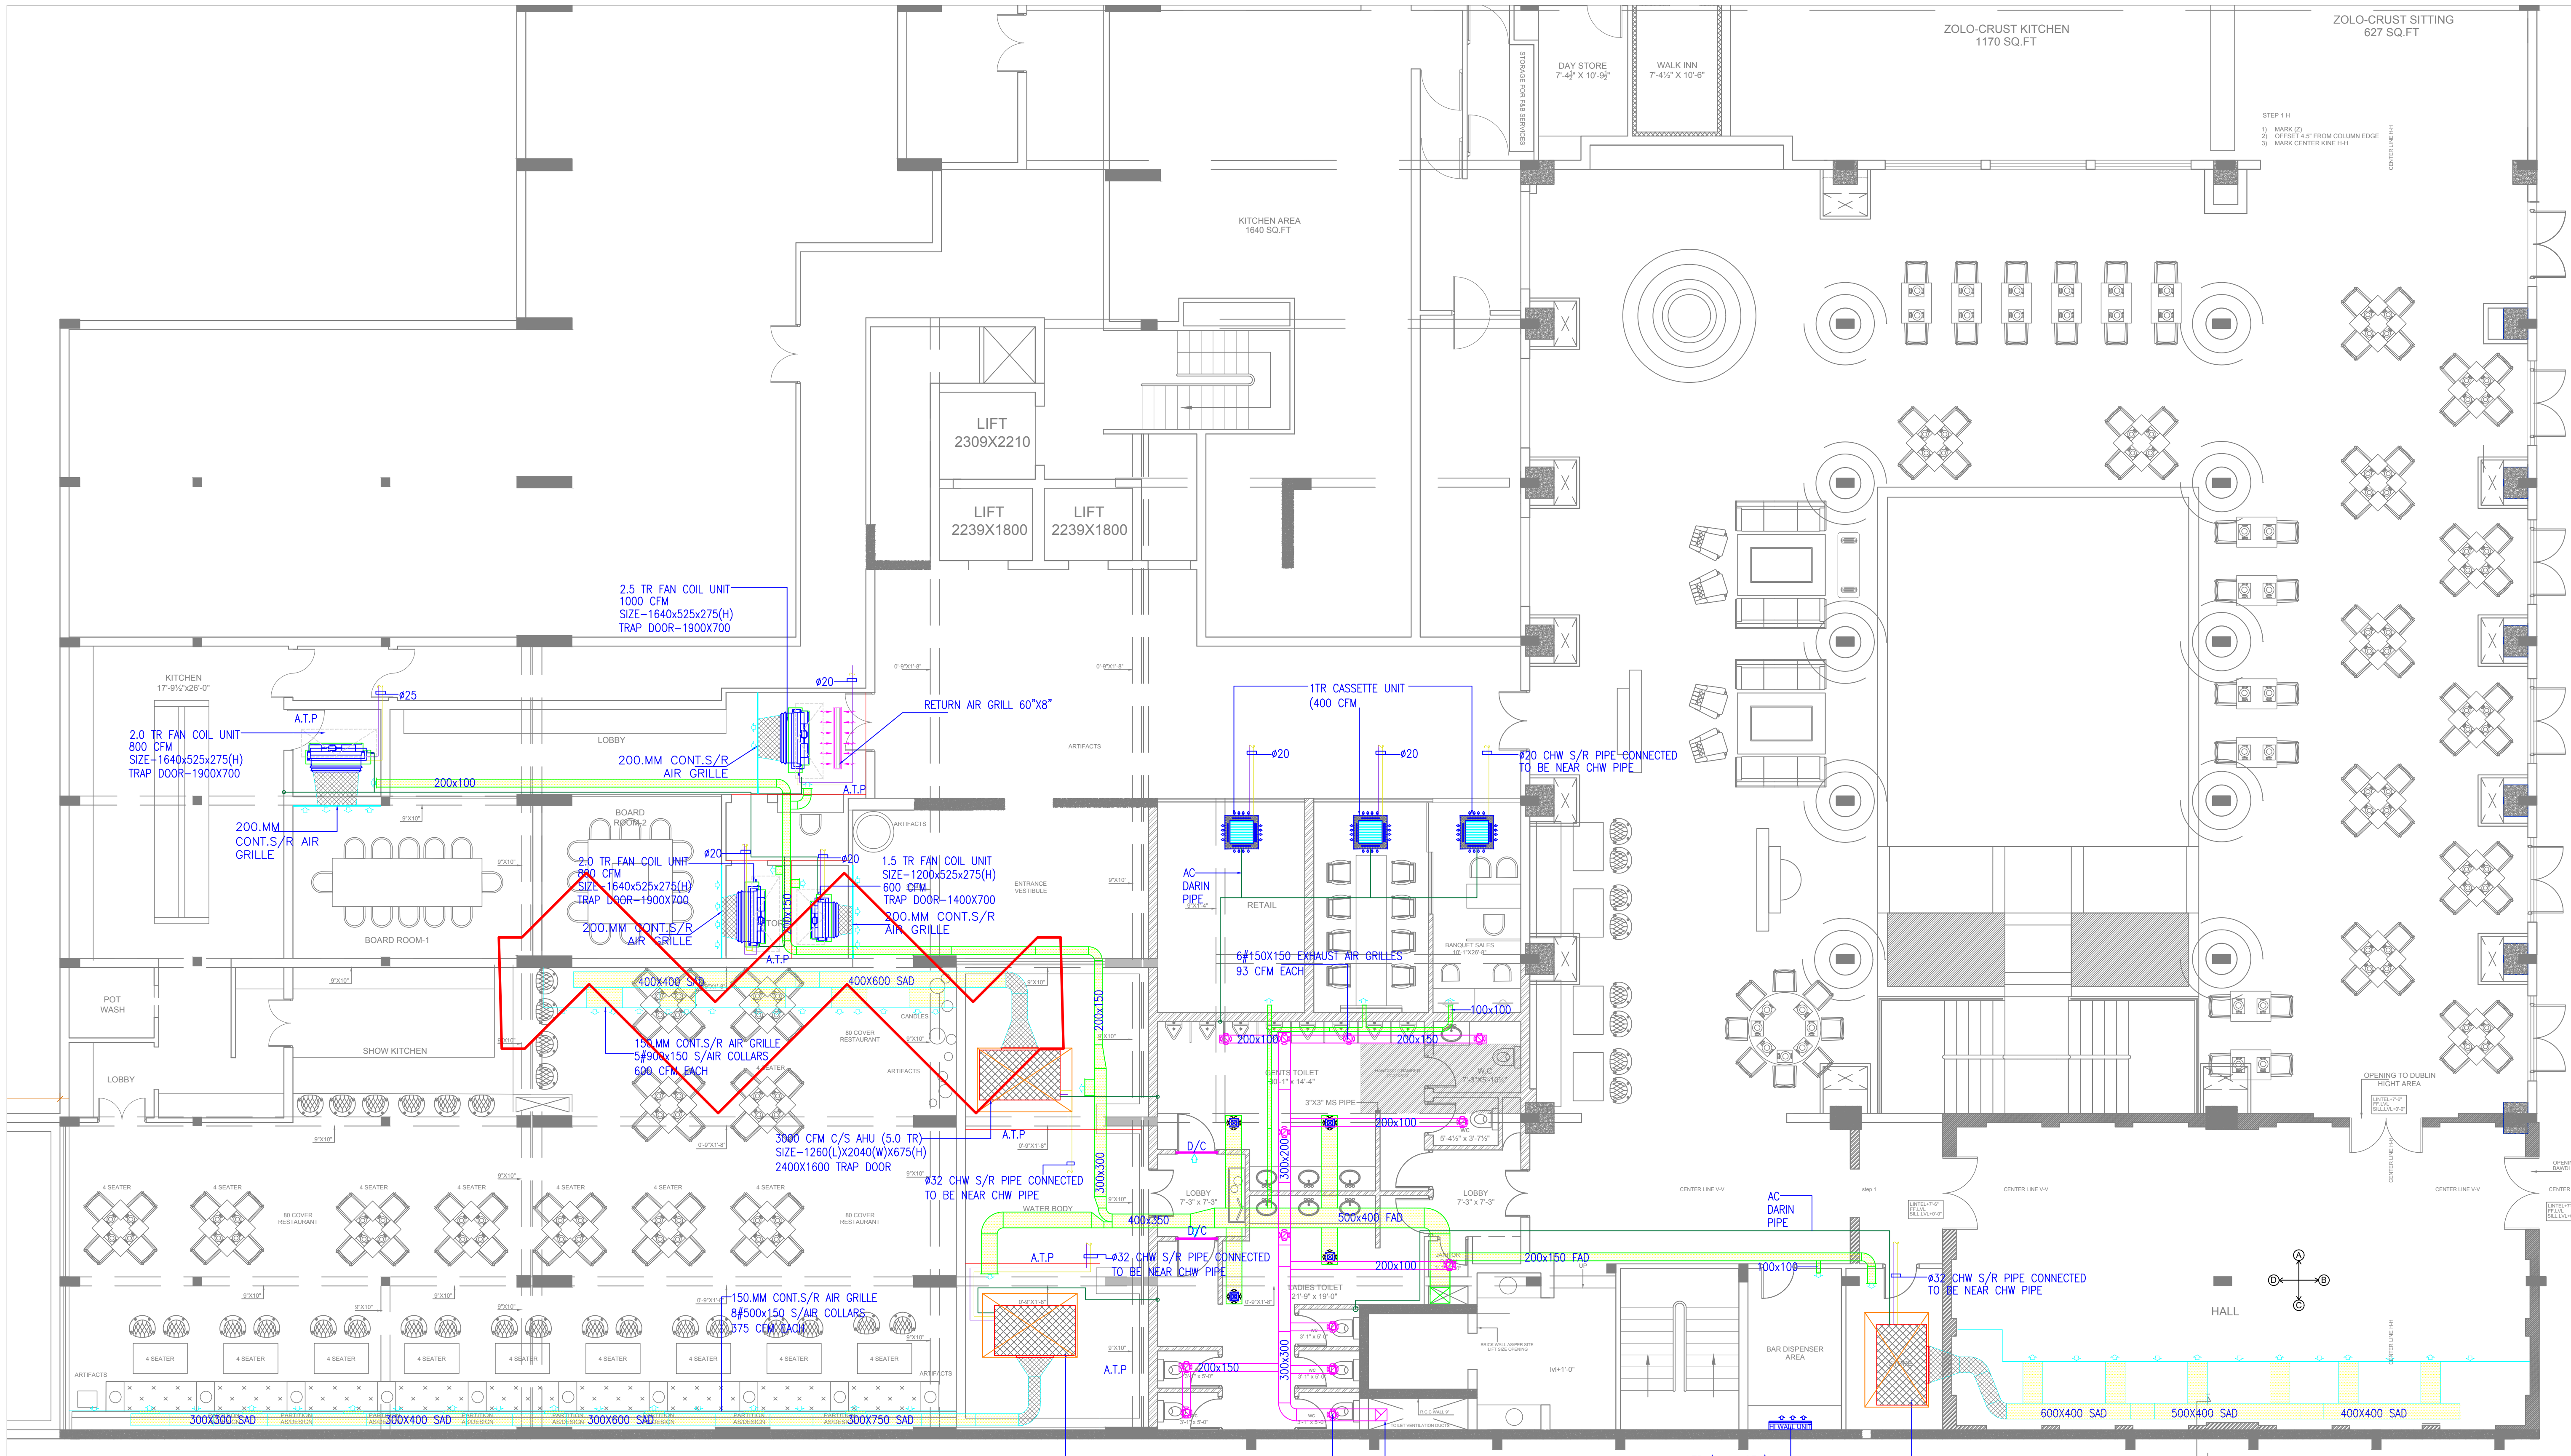

SYMBOL	DESCRIPTION
	SUPPLY AIR DUCT
	EXHAUST AIR DUCT
	FRESH AIR DUCT
	SUPPLY AIR DIFFUSER
	DUCT INSULATION
	DUCT ACOUSTIC
	EXHAUST AIR GRILLE
	RETURN AIR DUCT
	CHW SUPPLY PIPE
	CHW RETURN PIPE
	DRAIN PIPE

HOTEL CLARKS,
LUCKNOW

ARCHITECTS
NEERAV GUPTA
L-1, KRISHNA MARG, C-SCHEME,
JAIPUR (302001), RAJASTHAN.
PH.0141-2360825
E-Mail- architect_neeravgupta@yahoo.com

REVISED BASEMENT FLOOR
HVAC LAYOUT

SCALE: N.T.S.

PROJECT NO-41	REVISION NO:05	02.03.2019
DRAWING NO- NG/HCL/JIV/AC/01		

SAN ENGINEERS & CONSULTANTS
G-2, 1055 CHITRAKOOT SCHEME, NEAR PRATAP STADIUM,
VAISHALI NAGAR JAIPUR
E mail : info@sanexl.com