


TERRACE FLOOR PLAN

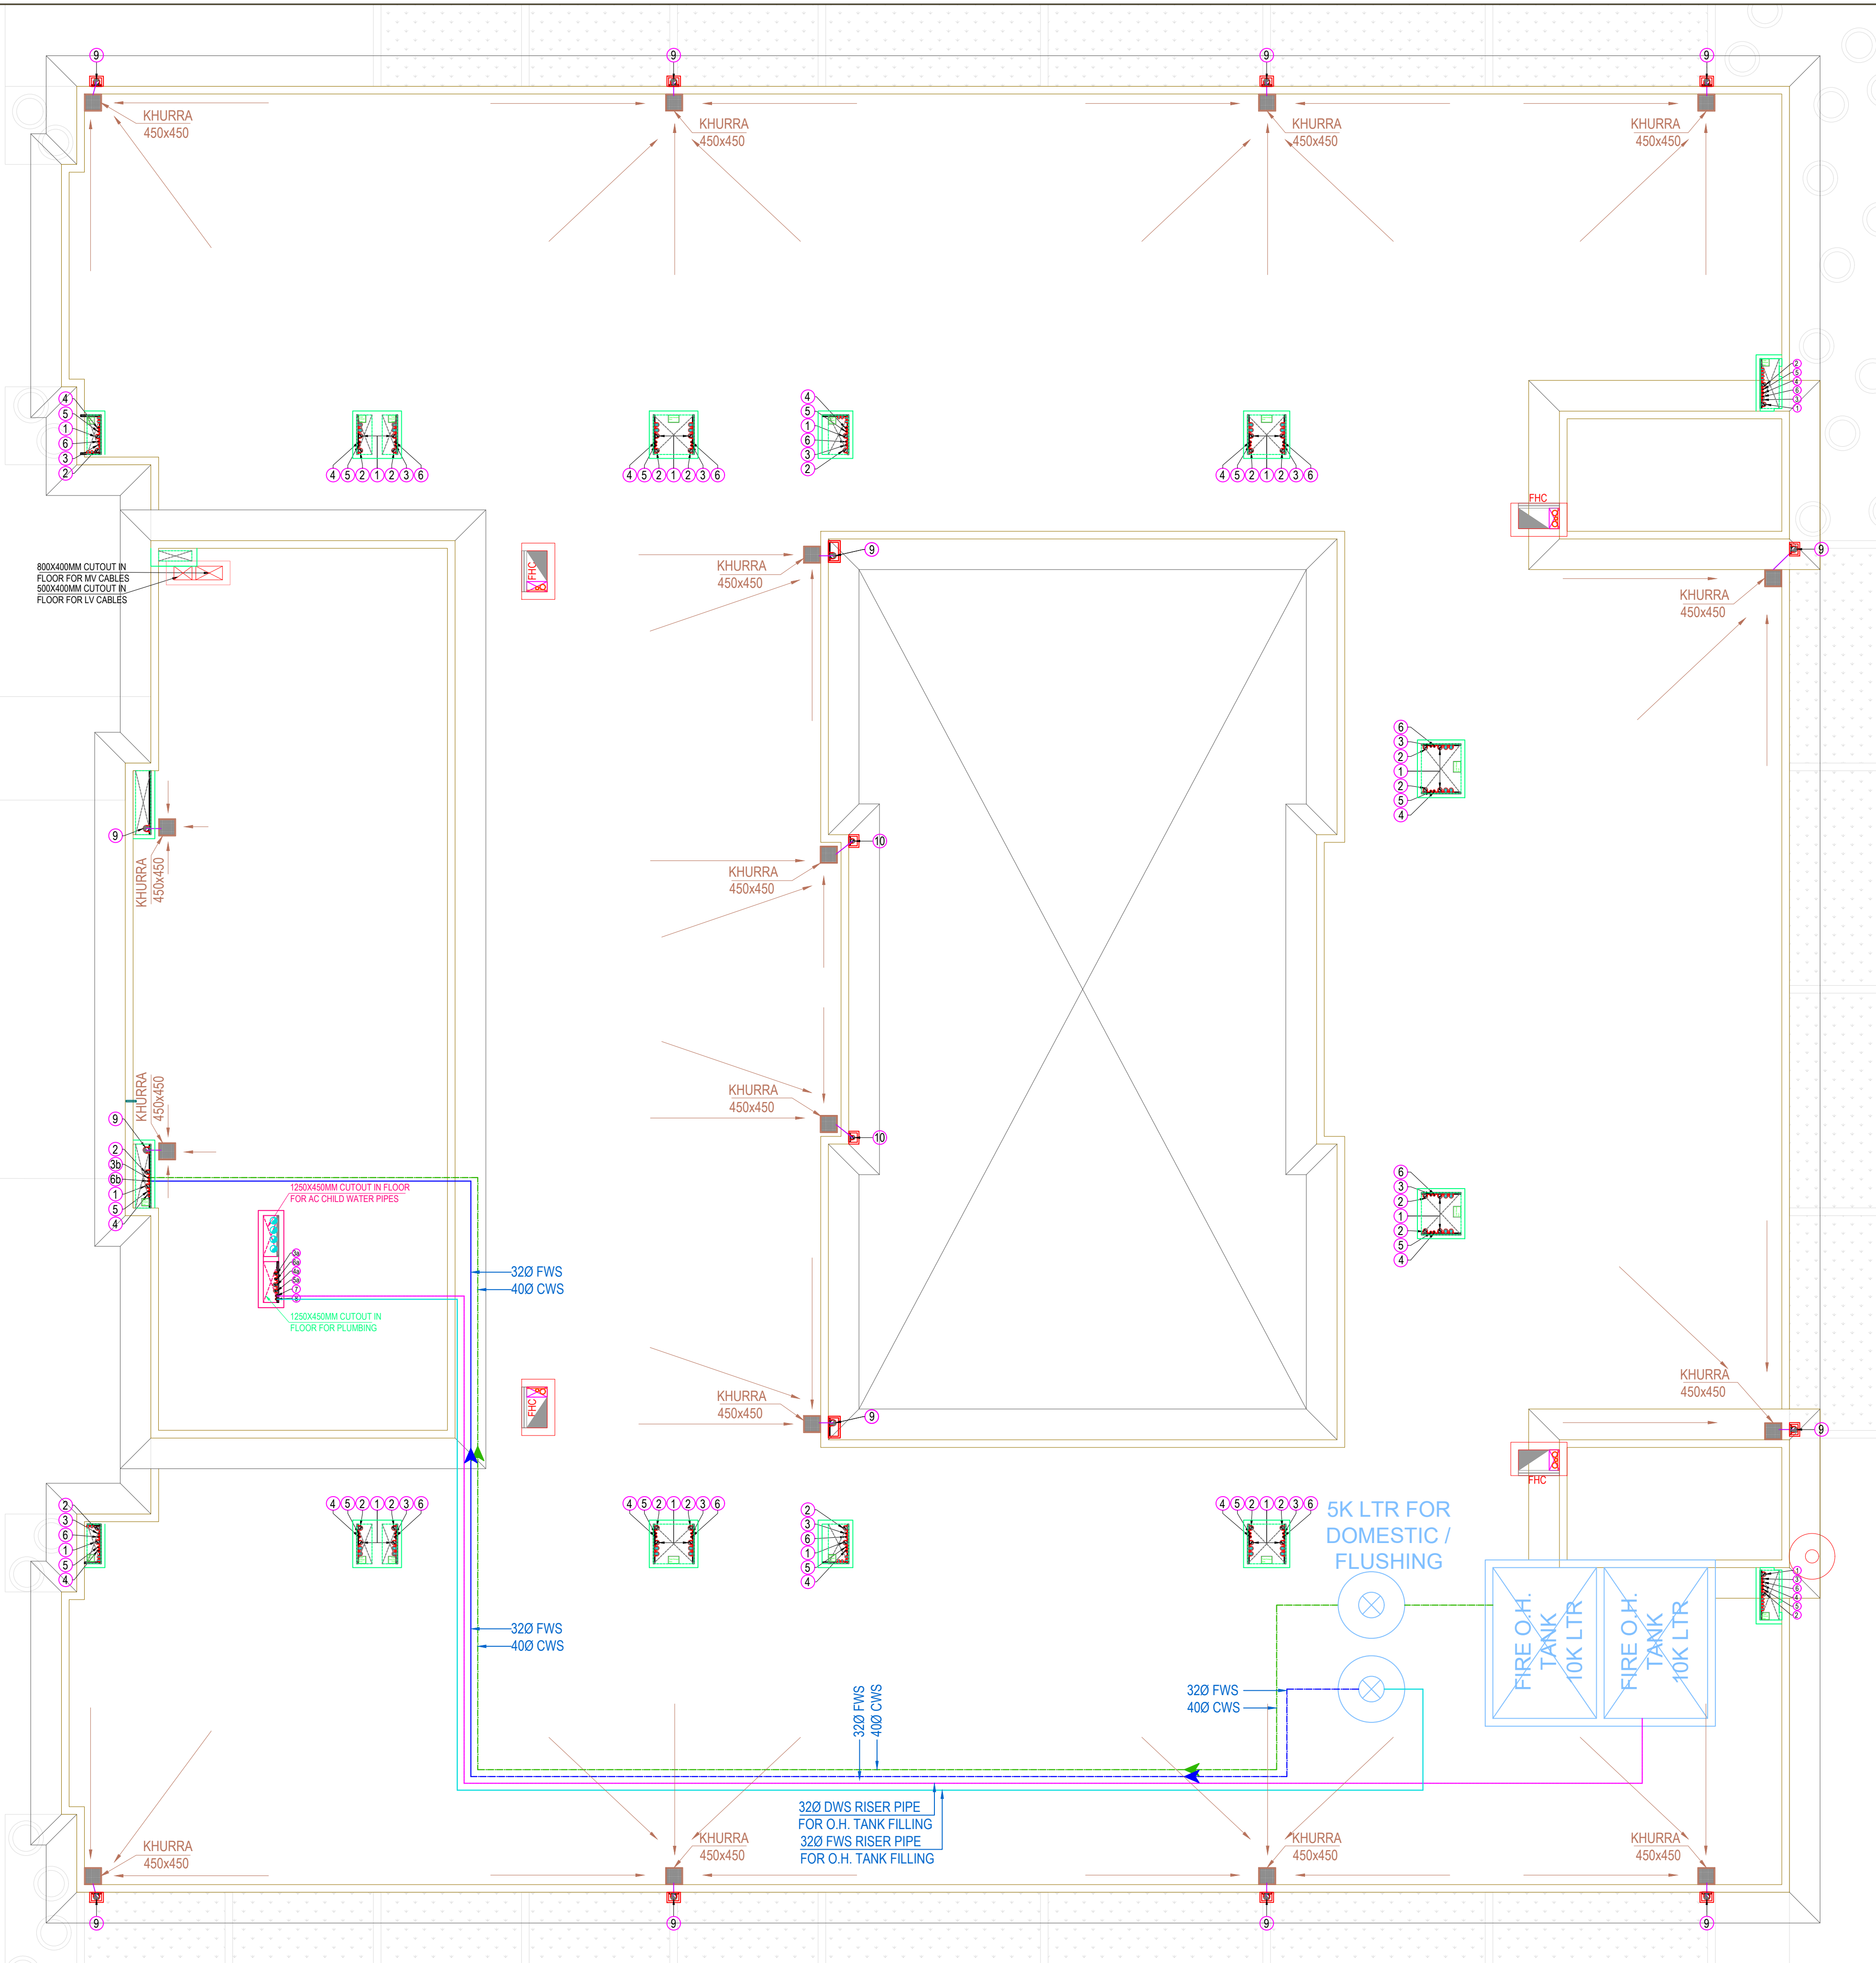

| PLUMBING LEGEND | |
|-----------------|--|
| ① | 1000 SOIL VERTICAL & VENT PIPE |
| ② | 1000 WASTE VERTICAL & VENT PIPE |
| ③ | COLD WATER SUPPLY PIPE FROM W.T.P. PLANT ROOM (HYDRO-PNEUMATIC SYSTEM) FOR GR. & 1ST FLOOR |
| ③a | COLD WATER SUPPLY PIPE FROM W.T.P. PLANT ROOM (HYDRO-PNEUMATIC SYSTEM) FOR 2ND & 3RD FLOOR |
| ③b | COLD WATER SUPPLY PIPE TO PUBLIC TOILETS FROM O.H. TANK (BY GRAVITY) |
| ④ | HOT WATER SUPPLY PIPE FROM CENTRALISED HOT WATER SYSTEM FOR GR. & 1ST FLOOR |
| ④a | HOT WATER SUPPLY PIPE FROM CENTRALISED HOT WATER SYSTEM FOR 2ND & 3RD FLOOR |
| ⑤ | HOT WATER RETURN PIPE TO CENTRALISED HOT WATER SYSTEM FOR GR. & 1ST FLOOR |
| ⑤a | HOT WATER RETURN PIPE TO CENTRALISED HOT WATER SYSTEM FOR 2ND & 3RD FLOOR |
| ⑥ | FLUSHING WATER SUPPLY PIPE FROM O.H. TANK FOR GR. & 1ST FLOOR |
| ⑥a | FLUSHING WATER SUPPLY PIPE FROM O.H. TANK FOR 2ND & 3RD FLOOR |
| ⑥b | FLUSHING WATER SUPPLY PIPE TO PUBLIC TOILETS FROM O.H. TANK (BY GRAVITY) |
| ⑦ | COLD RISER PIPE FOR O.H. TANK FILLING |
| ⑧ | FLUSHING RISER PIPE FOR O.H. TANK FILLING |
| ⑨ | 1500 RAIN WATER VERTICAL PIPE |
| ⑩ | 1000 RAIN WATER VERTICAL PIPE |
| | SOIL PIPE (RUN IN SUNKEN / CEILING) |
| | WASTE PIPE (RUN IN SUNKEN / CEILING) |
| | FLOOR TRAP 100X100MM ('P' TRAP) WITH S.S GRATING |
| | FLOOR DRAIN (100X50MM) WITH S.S GRATING |
| WB TO FT | 320 WASTE PIPE |
| FD TO FT | 500 / 650 WASTE PIPE |
| FT TO MAIN PIPE | 1000 WASTE PIPE |
| UT TO MAIN PIPE | 1000 SOIL PIPE |
| WC TO MAIN PIPE | 1000 SOIL PIPE |

SCHEMATIC DRAWINGS

REVISION NO.- R0

MEPF CONSULTANT:
NEWTECH CONSULTING ENGINEERS
C-137/1, 3rd Floor, Vijay Vihar Phase - II
(Rohini Sec.-1), New Delhi – 110085. (India)

ARCHITECT:
RAVI KUMAR GUPTA
CA/83/7739
L-1, KRISHNA MARG, C- SCHEME,
JAIPUR (302001), RAJASTHAN.
PH.0141-2360825 E-Mail-ravigupta_15@yahoo.com

DRAWING TITLE:

**TERRACE FLOOR PLAN
(PLUMBING LAYOUT)**

PROJECT:
LAXMI PALACE / HOTEL

| | | |
|-------------------|--------|-------------------|
| DRAWN BY: | NORTH: | DATE: |
| SONU KUMAR | | 09-01-2024 |

| | | |
|--------------------|--------------|--------|
| CHECKED BY: | DRAWING NO.: | SCALE: |
| VIJAY KUMAR | PL-03 | 1:100 |

NOTES:
THE COPYRIGHT AND PROPERTY OF THIS DESIGN AND DRAWING BELONGS TO **RAVI KUMAR GUPTA**. IT MUST NOT BE COPIED OR REPRODUCED IN ANY MANNER WITHOUT THEIR WRITTEN CONSENT. A LEGAL ACTION AS PER LAW MAY BE INITIATED AGAINST THE OFFENDER. 02

STRUCTURE CO. :
SANRACHANA