



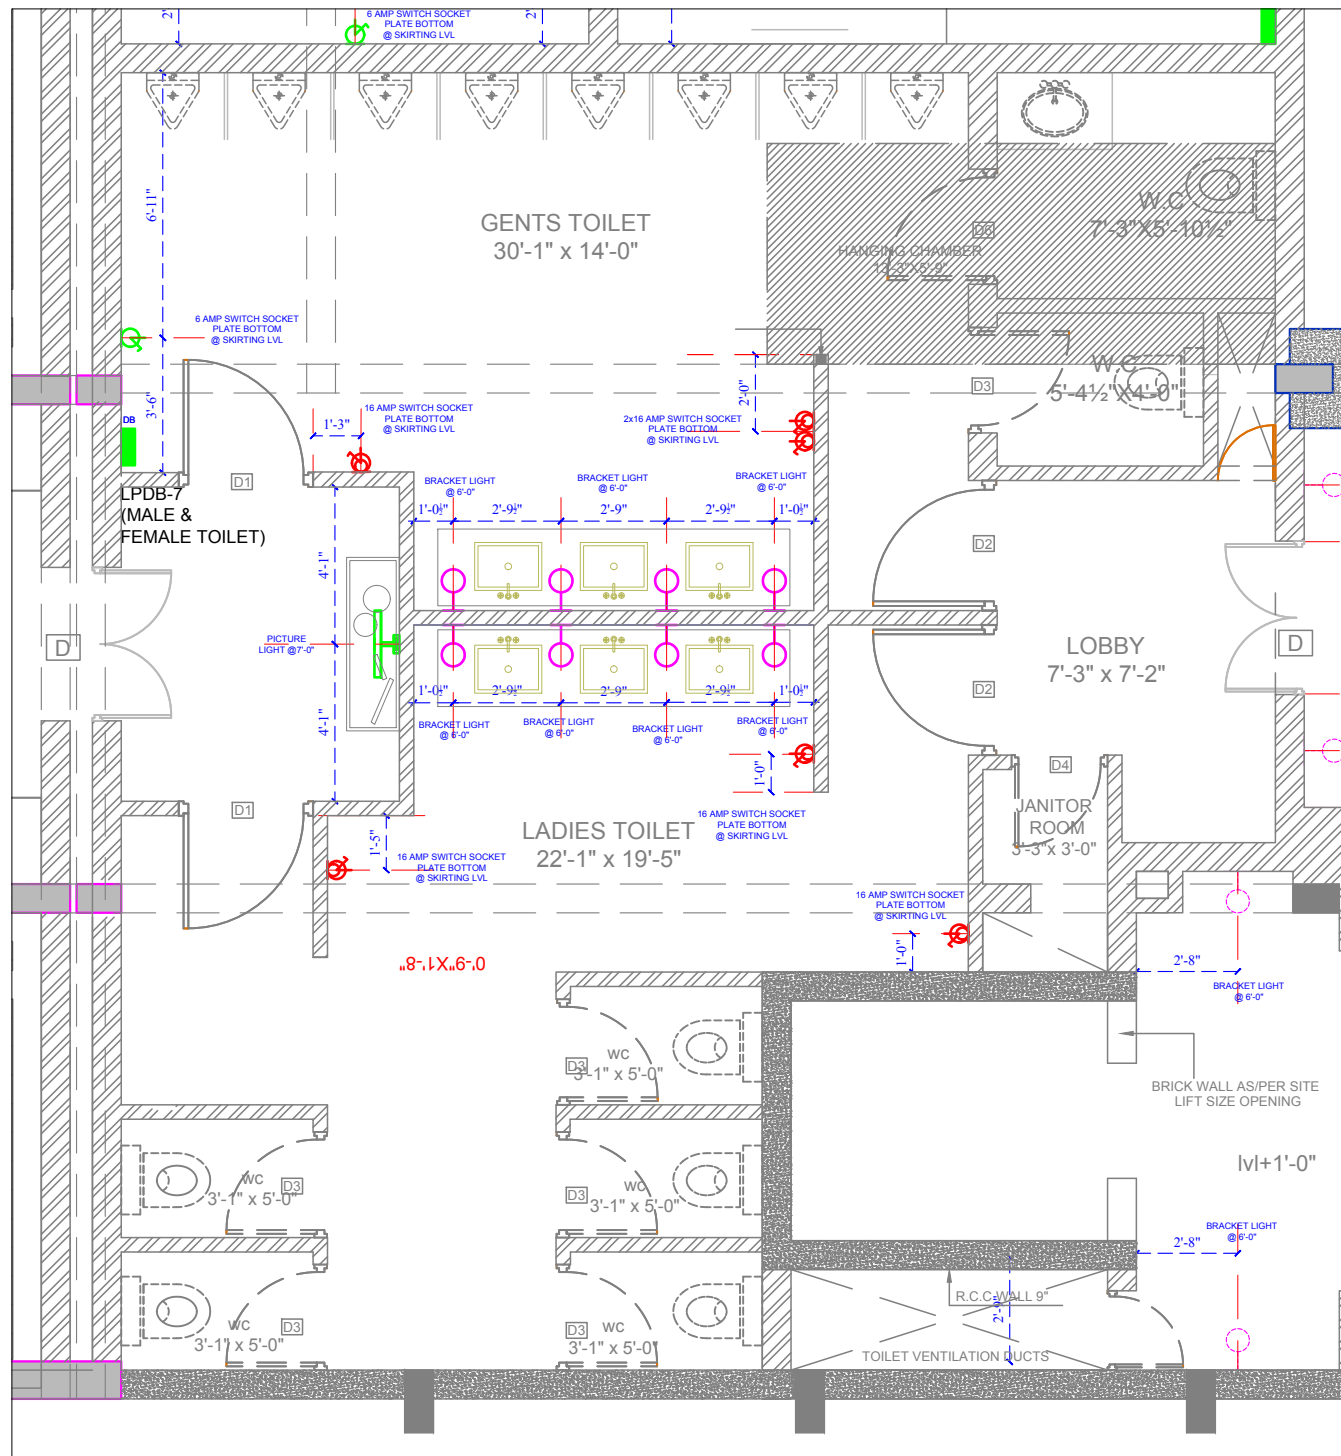

TOILET WALL ELECTRICAL PLAN

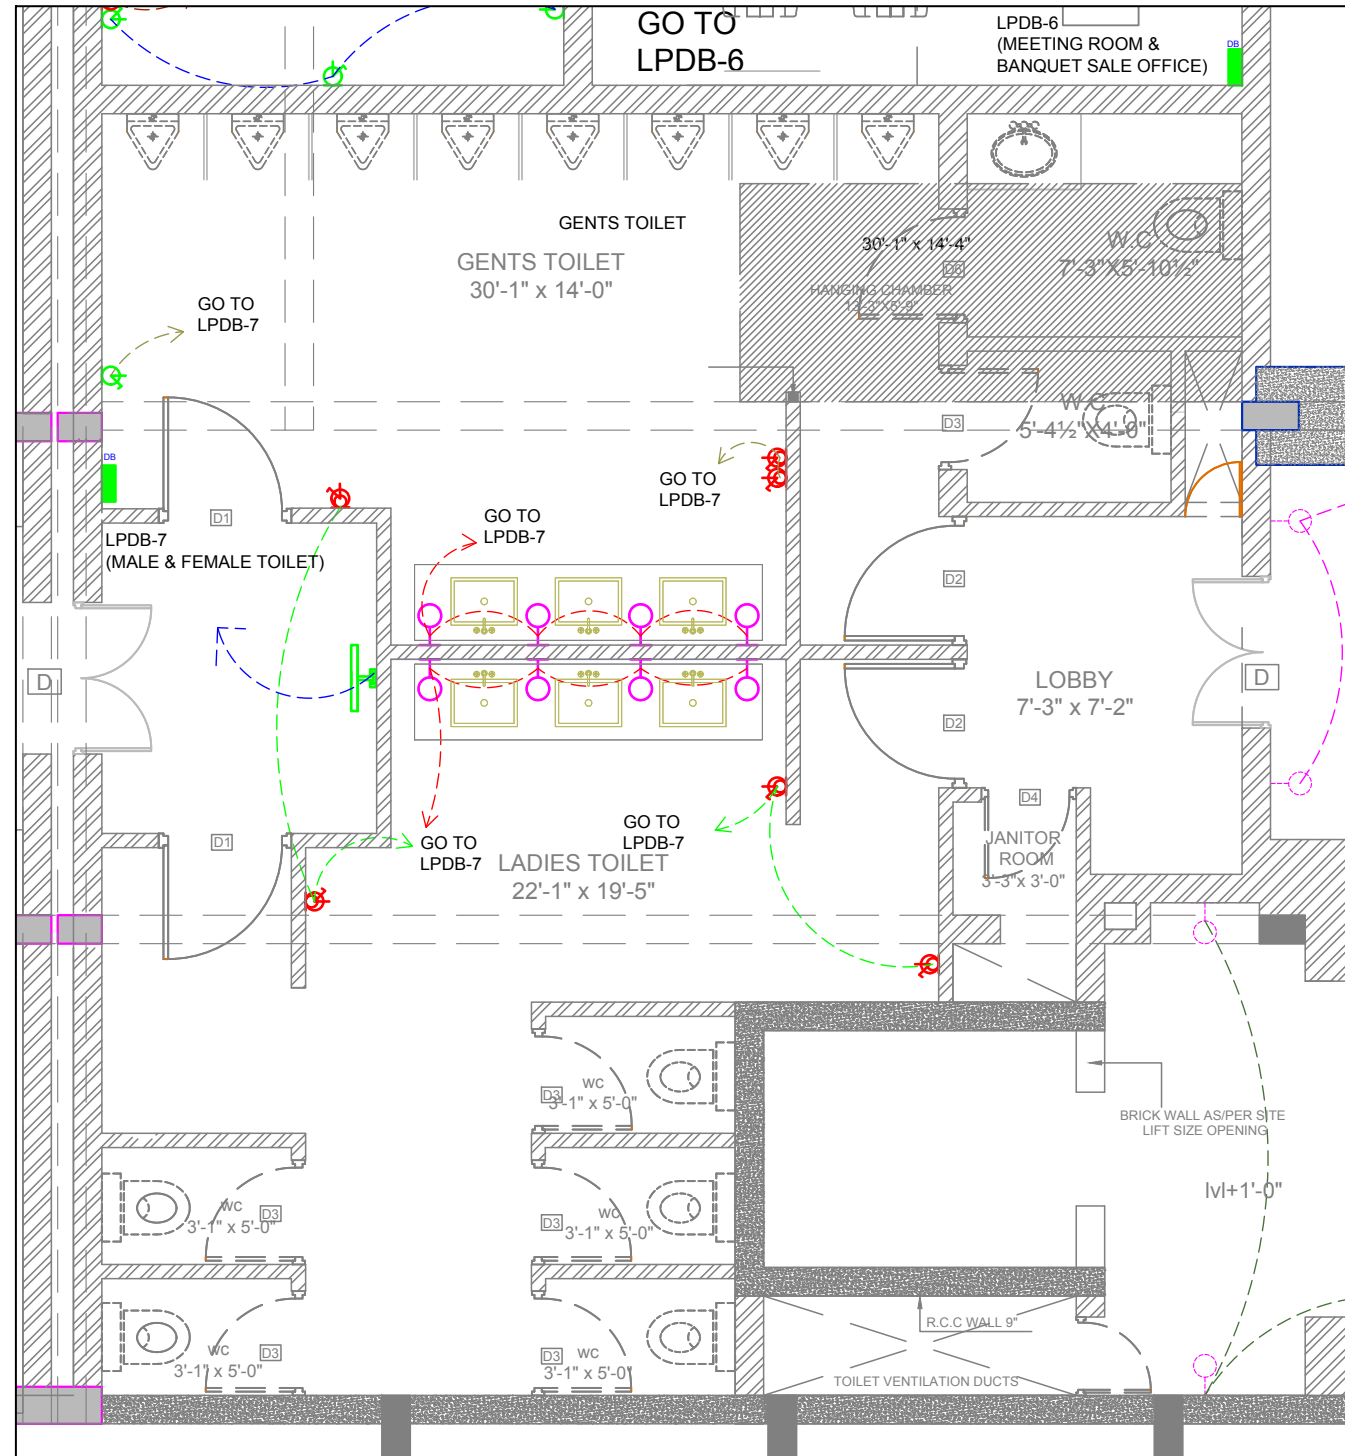

TOILET WALL WIRE DIAGRAM

S.NO	SYMBOL	DESCRIPTION OF ITEM	HT.
1		CEILING FAN	
2		SWITCH BOARD	
3		BRACKET LIGHT	6'-0"
4		RETROFIT CFL INTEGRATED	
5		SWITCH SOCKET 6A	
6		SWITCH SOCKET 16A	
7		ANTENNA	
8		TELEPHONE	
9		CHANDELLIER	
10		DISTRIBUTION BOX	
11		PICTURE LIGHT	
12		HANGING LIGHT	
13		CHANDELLIER	
14		UPLIGHTERS	
15		DOWNLIGHTERS	
16		DONOT DISTURB (DND)	
17		CARD HOLDER	
18		AIR CONDITIONER	
19		FOOT LIGHT	

ARCHITECT:
NEERAV GUPTA
L-1, KRISHNA MARG, C-SCHEME,
JAPUR (202001), RAJASTHAN,
PIN-304123/269625
E-Mail-architect_neeravgupta@yahoo.com

PROJECT:

CLARKS

DRAWING TITLE:
TOILET ELECTRICAL

DRAWN BY:
DEEPIKA

CHECKED BY:
NEERAV GUPTA

SCALE:
N.T.S.

DATE:
13-3-2019

NORTH:
CABA/TOIEL02

NOTES:
THE COPYRIGHT AND PROPERTY OF THIS DESIGN AND DRAWING
BELONGS TO NEERAV GUPTA. IT MUST NOT BE COPIED OR
REPRODUCED IN ANY MANNER WITHOUT THEIR WRITTEN
CONSENT. A LEGAL ACTION AS PER LAW MAY BE INITIATED
AGAINST THE OFFENDER.