


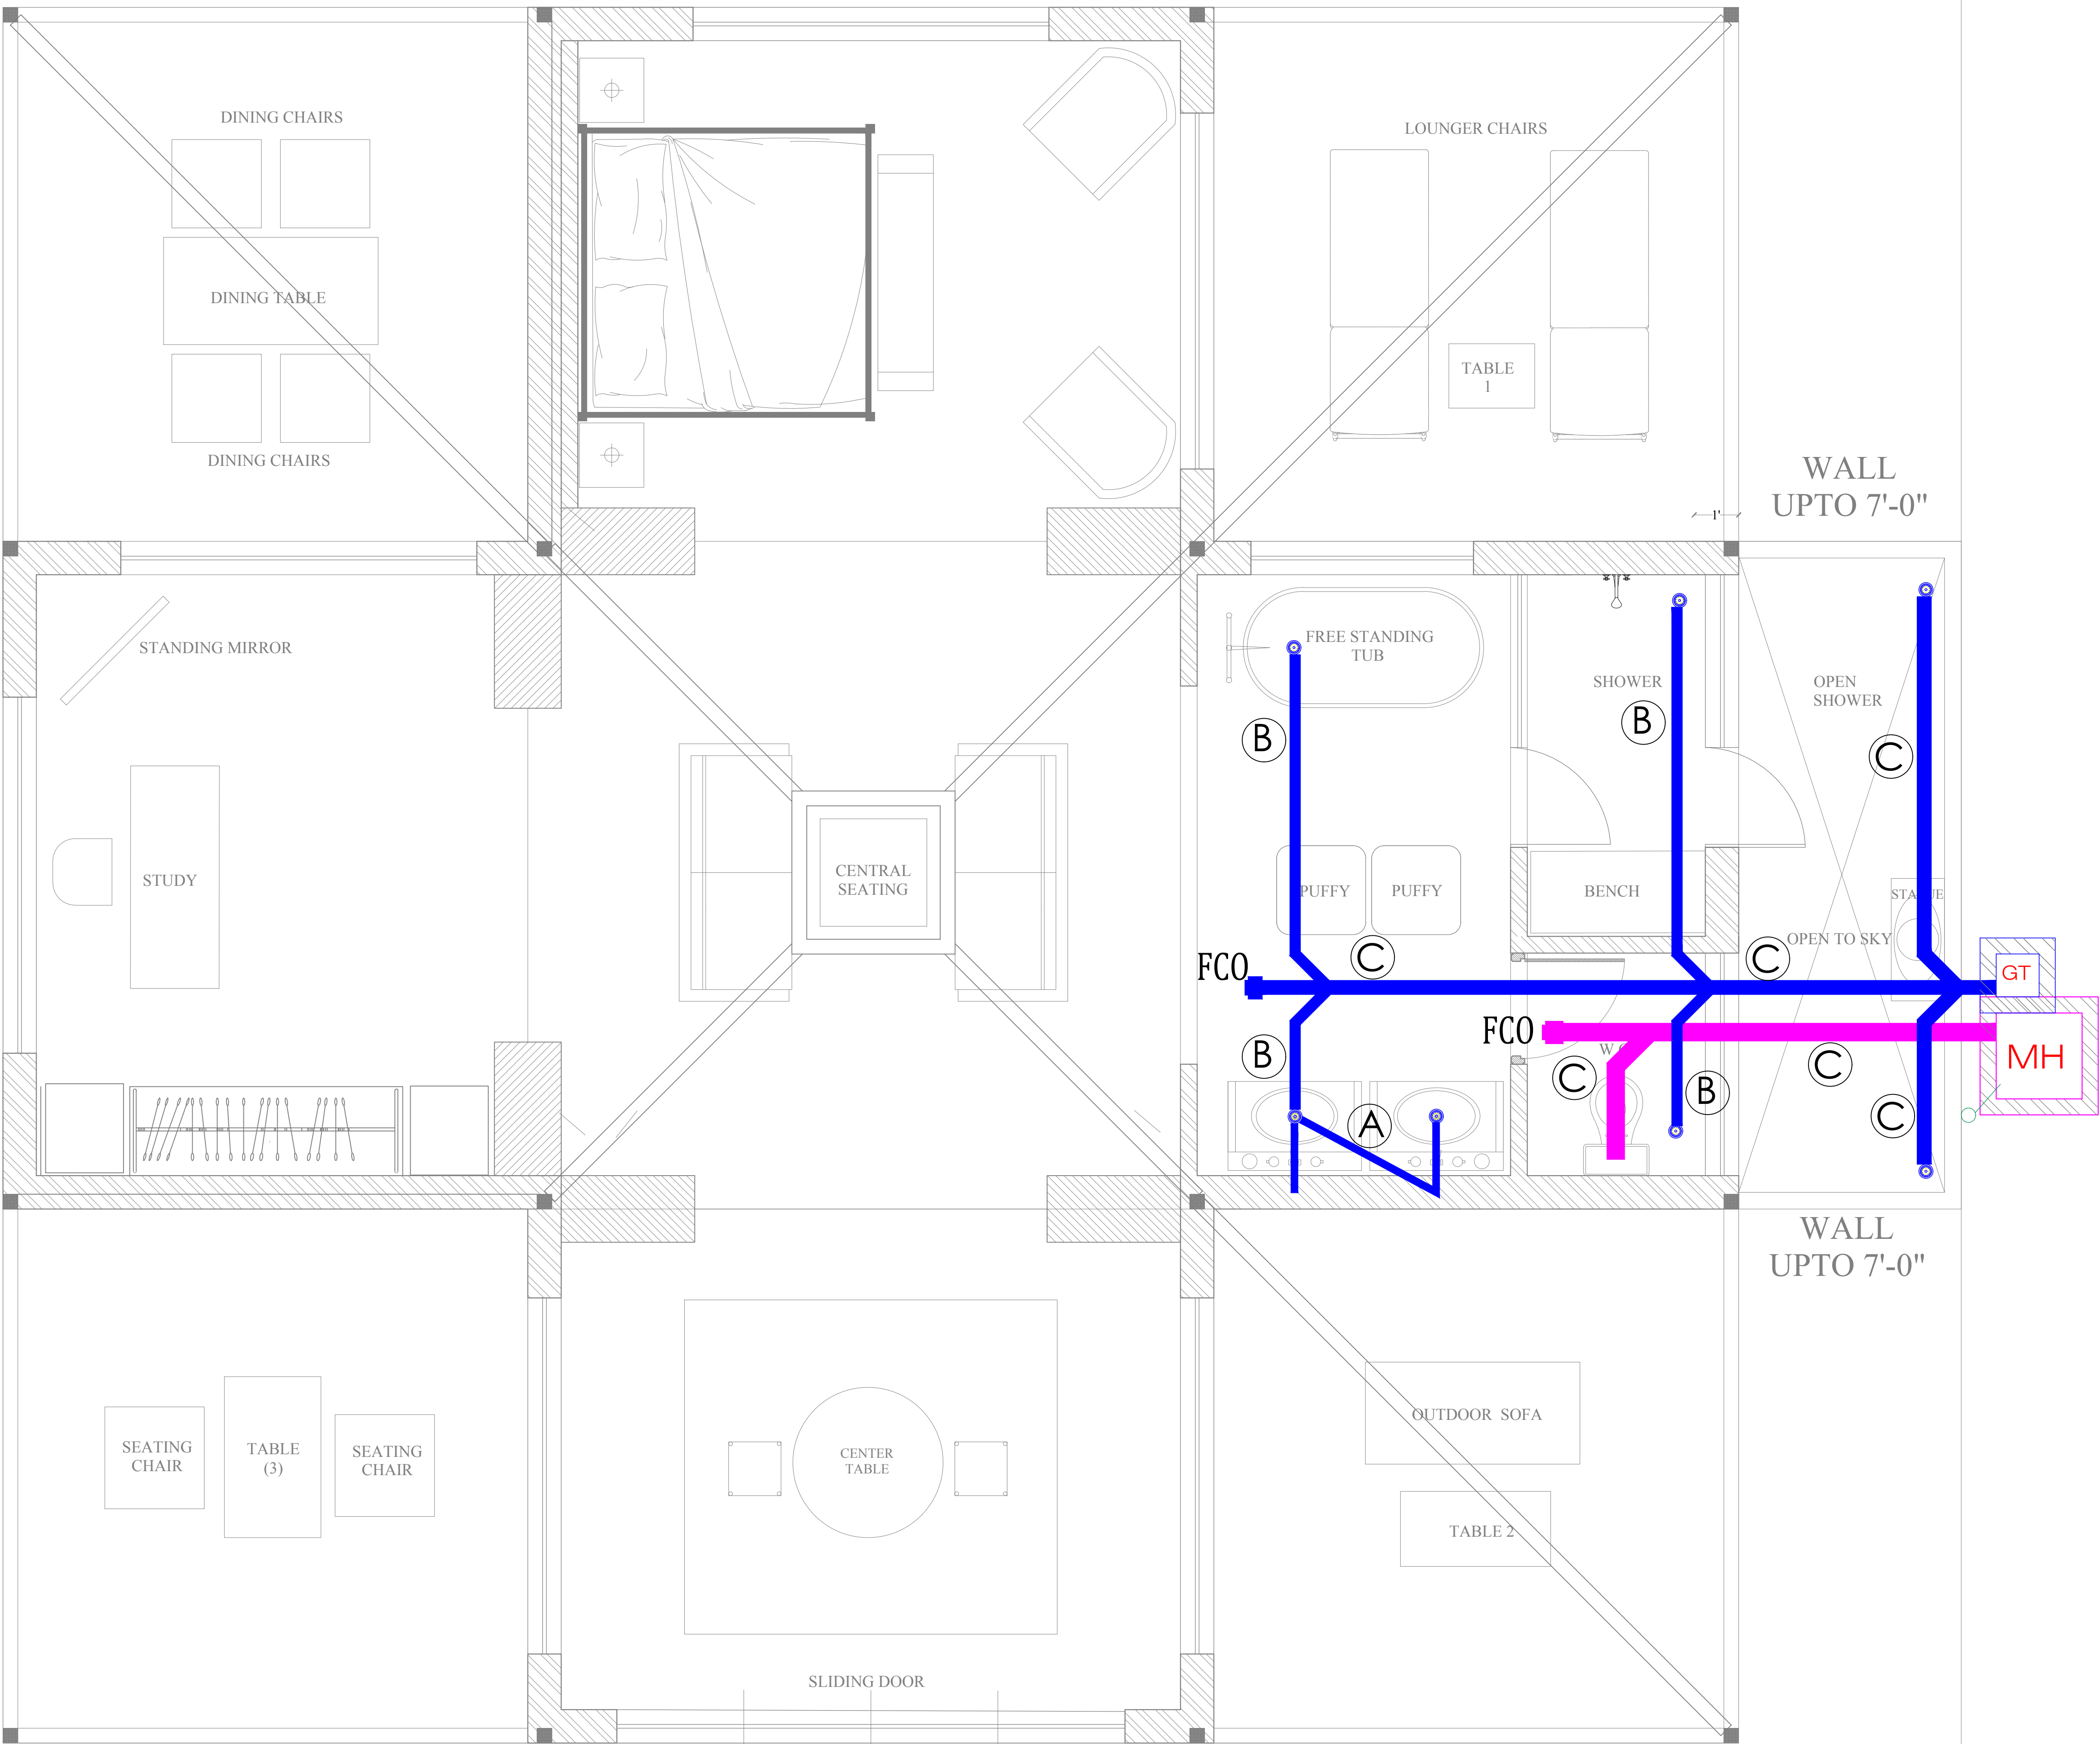

WATER DRAINAGE PIPE SCHEDULE

| PIPE NO. | SIZE | SLOPE |
|----------|------|-------|
| (A)      | 50Ø  | 1:90  |
| (B)      | 75Ø  | 1:110 |
| (C)      | 110Ø | 1:110 |

LEGEND:-

- 1. SOIL PIPE
- 2. WASTE PIPE
- 3. VENT PIPE
- 4. P TRAP DRAIN POINT
- 5. FLOOR CLEAN OUT PLUG (FCO)
- 6. MANHOLE FOR SEWER LINE 2'-0" X 2'-0"
- 7. GULLY TRAP 1'-6" X 1'-6"

CLARKS JAWAI

ARCHITECTS  
NEERAV GUPTA  
L-1, KRISHNA MARG, C- SCHEME,  
JAIPUR (302001), RAJASTHAN.  
PH.0141-2360825  
E-Mail- architect\_neeravgupta@yahoo.com

TENT TYPICAL PLUMBING  
DRAINAGE LAYOUT

SCALE: N.T.S.  
PROJECT NO:45  
DRAWING NO: NG/C/PLU/01  
REVISION NO:  
19.06.2019

SAN ENGINEERS & CONSULTANTS  
G-2, 1035, GURUKRANT SHEME, NEAR PRATAP STADIUM,  
VAISHALI NAGAR, BESIDE TAGORE FOUNDATION SCHOOL,  
JAIPUR-302021, +91-141-402851  
E-mail: info@sanesp.com