


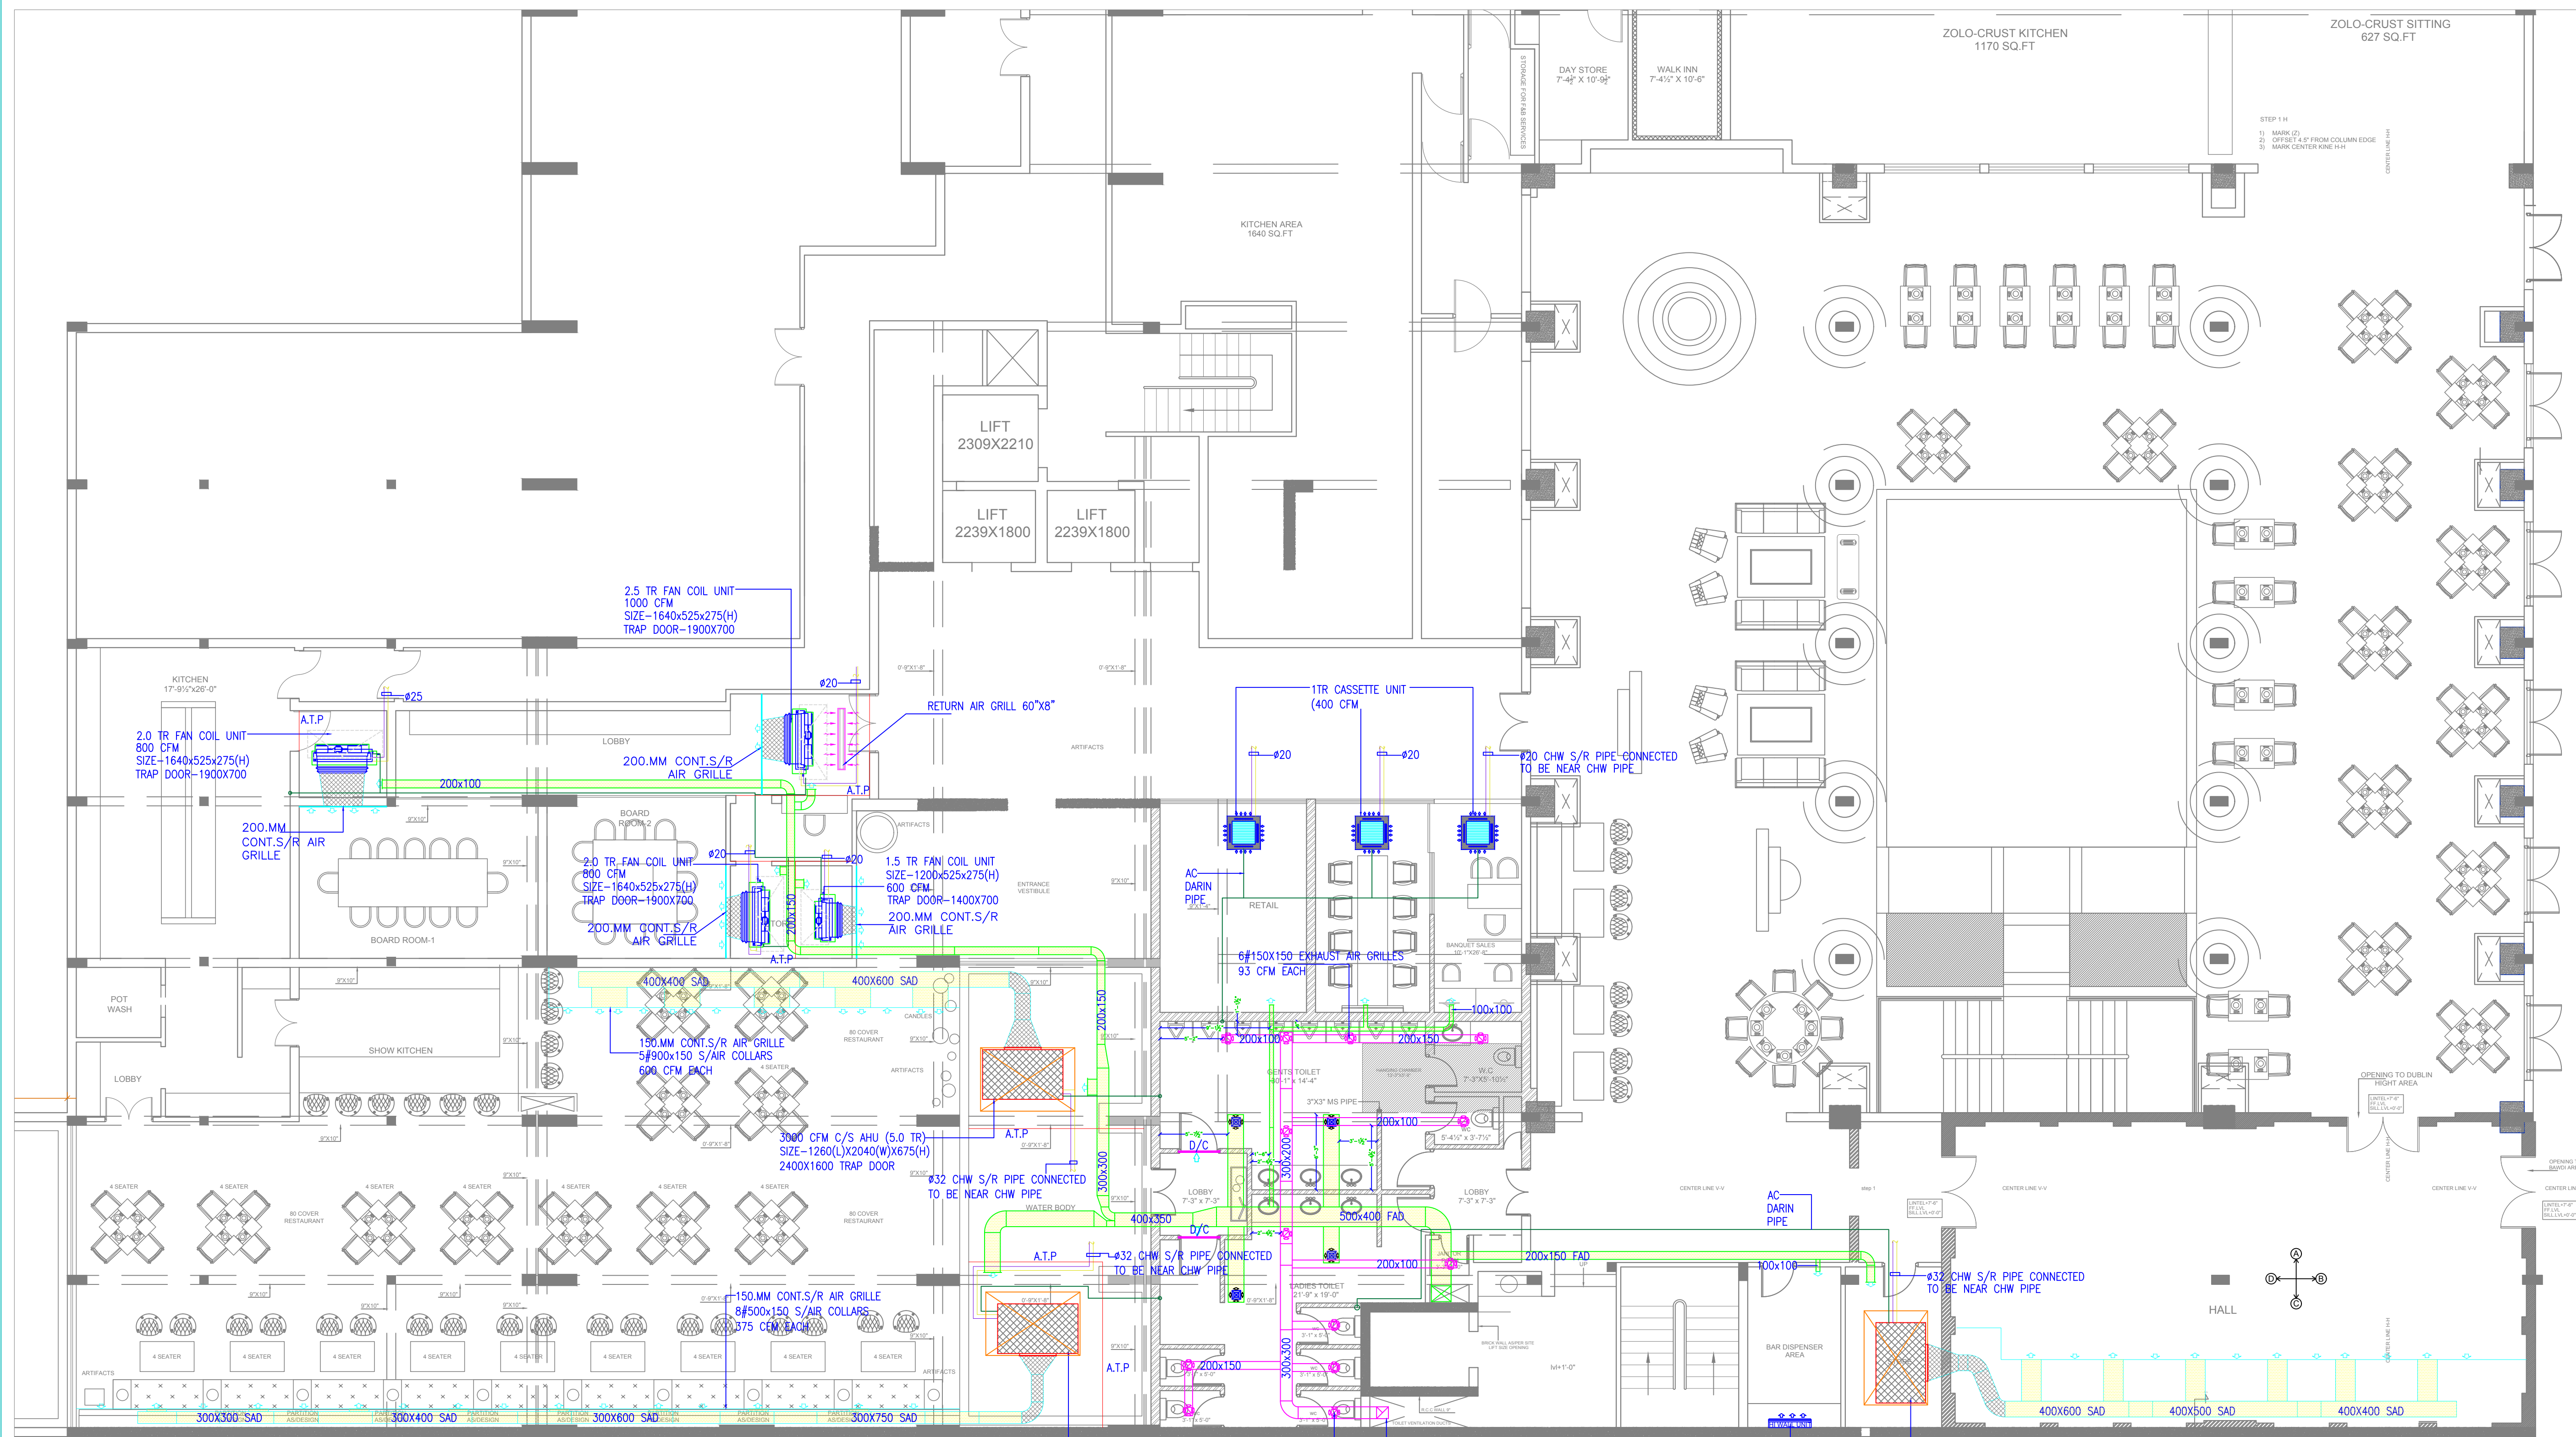

SYMBOL	DESCRIPTION
	SUPPLY AIR DUCT
	EXHAUST AIR DUCT
	FRESH AIR DUCT
	SUPPLY AIR DIFFUSER
	DUCT INSULATION
	DUCT ACOUSTIC
	EXHAUST AIR GRILLE
	RETURN AIR DUCT
	CHW SUPPLY PIPE
	CHW RETURN PIPE
	DRAIN PIPE

**HOTEL CLARKS,
LUCKNOW**

ARCHITECTS
NEERAV GUPTA
L-1, KRISHNA MARG, C- SCHEME,
JAIPUR (302001), RAJASTHAN.
PH.0141-2360825
E-Mail- architect_neeravgupta@yahoo.com

**REVISED BASEMENT FLOOR
HVAC LAYOUT**

SCALE: N.T.S.

PROJECT NO:41
DRAWING NO: NGHCL/HVAC/01
REVISION NO:05
02.03.2019

SAN ENGINEERS & CONSULTANTS
G-2, 1055 CHITRAKOOT, NEAR CIVIL SUPPLY STATION,
VISHAL NAGAR, JAIPUR
+91-141-402631
E-mail: info@sanepl.com