


FOR BALANCING
& SWIMMING POOL
TATION PLANT ROOM

North

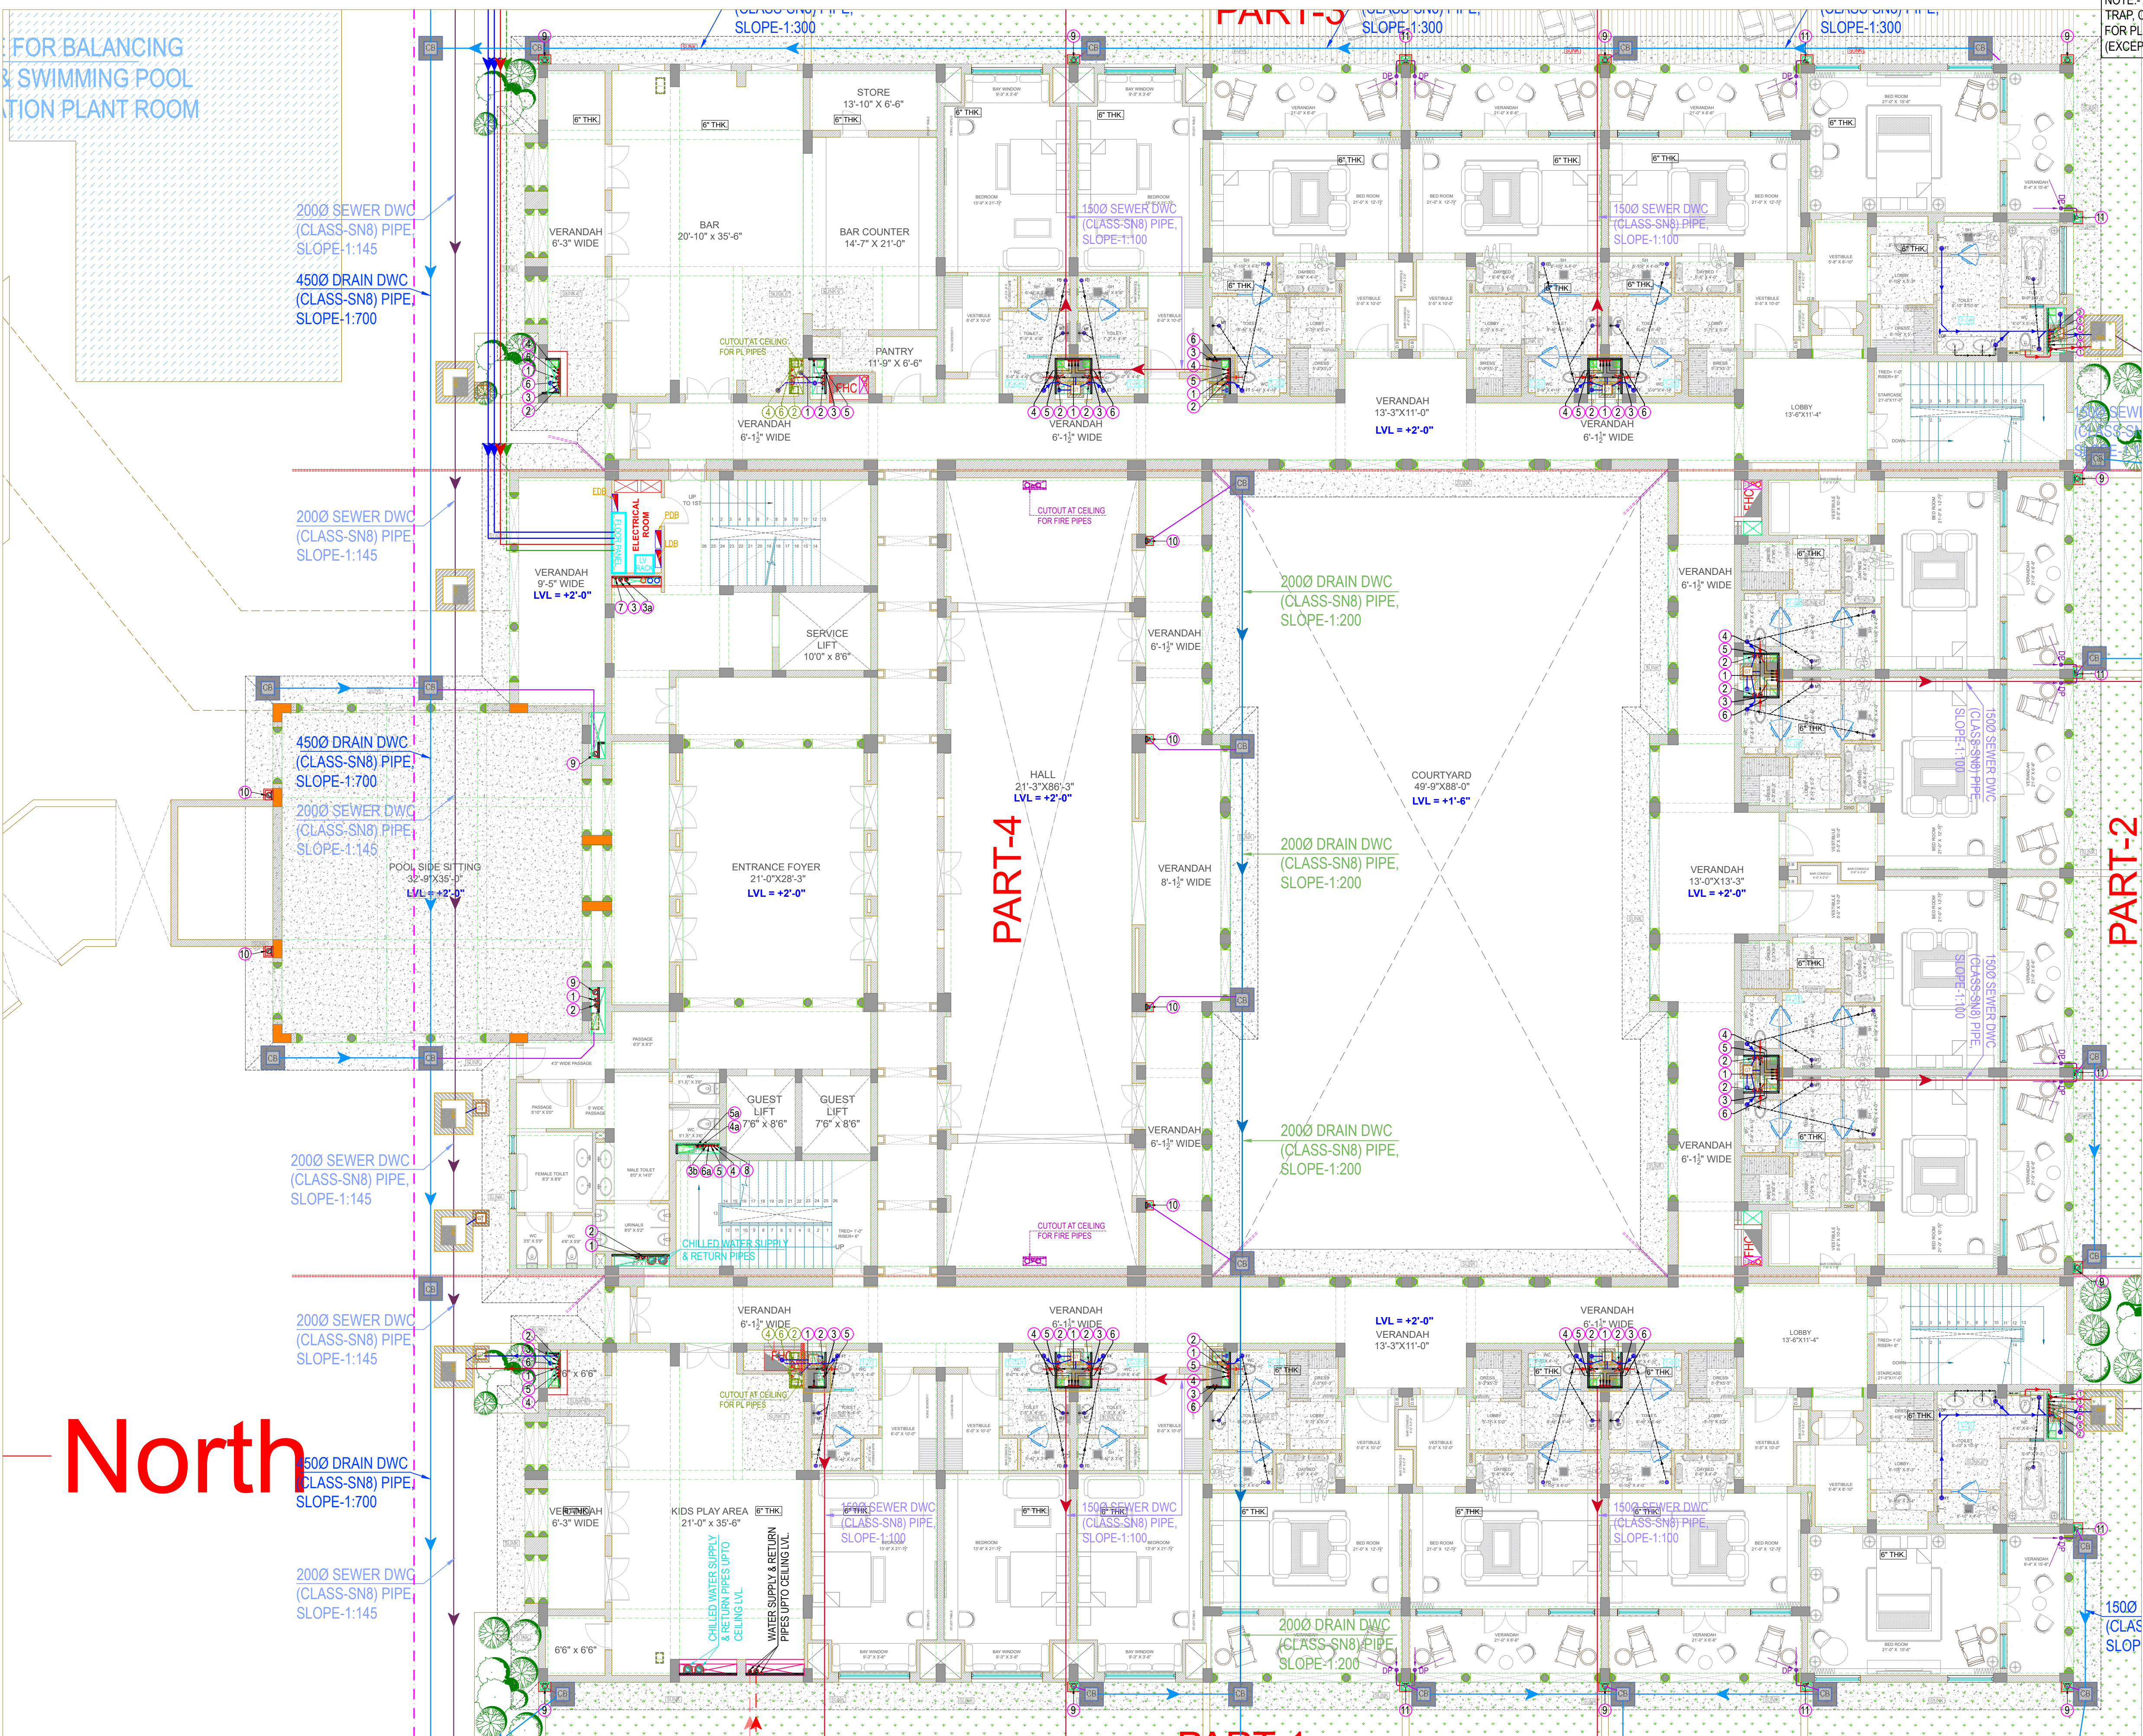

NOTE:- ALL PIPE DIAMETER, MANHOLE SIZES, GULLY TRAP, CHAMBER, MEP PLANTS ETC. SHOWN IN MM FOR PLUMBING AND FIRE FIGHTING WORKS (EXCEPT SHAFT SIZES).

PLUMBING LEGEND	
①	1000 SOIL VERTICAL & VENT PIPE
②	1000 WASTE VERTICAL & VENT PIPE
③	COLD WATER SUPPLY PIPE FROM W.T.P. PLANT ROOM (HYDRO-PNEUMATIC SYSTEM) FOR GR. & 1ST FLOOR
③a	COLD WATER SUPPLY PIPE FROM W.T.P. PLANT ROOM (HYDRO-PNEUMATIC SYSTEM) FOR 2ND & 3RD FLOOR
③b	COLD WATER SUPPLY PIPE TO PUBLIC TOILETS FROM O.H. TANK (BY GRAVITY)
④	HOT WATER SUPPLY PIPE FROM CENTRALISED HOT WATER SYSTEM FOR GR. & 1ST FLOOR
④a	HOT WATER SUPPLY PIPE FROM CENTRALISED HOT WATER SYSTEM FOR 2ND & 3RD FLOOR
⑤	HOT WATER RETURN PIPE TO CENTRALISED HOT WATER SYSTEM FOR GR. & 1ST FLOOR
⑤a	HOT WATER RETURN PIPE TO CENTRALISED HOT WATER SYSTEM FOR 2ND & 3RD FLOOR
⑥	FLUSHING WATER SUPPLY PIPE FROM O.H. TANK FOR GR. & 1ST FLOOR
⑥a	FLUSHING WATER SUPPLY PIPE TO PUBLIC TOILETS FROM O.H. TANK (BY GRAVITY)
⑦	COLD RISER PIPE FOR O.H. TANK FILLING
⑧	FLUSHING RISER PIPE FOR O.H. TANK FILLING
⑨	1500 RAIN WATER VERTICAL PIPE
⑩	1000 RAIN WATER VERTICAL PIPE
⑪	750 RAIN WATER VERTICAL PIPE
→	SOIL PIPE (RUN IN SUNKEN / CEILING)
→	WASTE PIPE (RUN IN SUNKEN / CEILING)
FT	FLOOR TRAP 100X100MM (P' TRAP) WITH S.S GRATING
FD	FLOOR DRAIN (100X50MM) WITH S.S GRATING
WB TO FT	320 WASTE PIPE
FD TO FT	500 / 650 WASTE PIPE
FT TO MAIN PIPE	1000 WASTE PIPE
UT TO MAIN PIPE	1000 SOIL PIPE
WC TO MAIN PIPE	1000 SOIL PIPE

GOOD FOR CONSTRUCTION
(ADVANCE COPY)

REVISION NO.- R1

MEPF
NEWTECH CONSULTING ENGINEERS
C-137/1, 3rd Floor, Vijay Vihar Phase - II
(Rohini Sec.-1), New Delhi - 110085, (India)

ARCHITECT:
RAVI KUMAR GUPTA
CA/83/7739
L-1, KRISHNA MARG, C- SCHEME,
JAIPUR (302001), RAJASTHAN.
PH.0141-2360825 E-Mail-ravigupta_15@yahoo.com

DRAWING TITLE:
**GROUND FLOOR PLAN
(PLUMBING LAYOUT)**

PROJECT:
LAXMI PALACE / HOTEL

DRAWN BY:	NORTH:	DATE:
SONU KUMAR		20-03-2024
CHECKED BY:	DRAWING NO.:	SCALE:
VIJAY KUMAR	PL-01	1:100

NOTES:
THE COPYRIGHT AND PROPERTY OF THIS DESIGN AND DRAWING BELONGS TO **RAVI KUMAR GUPTA**. IT MUST NOT BE COPIED OR REPRODUCED IN ANY MANNER WITHOUT THEIR WRITTEN CONSENT. A LEGAL ACTION AS PER LAW MAY BE INITIATED AGAINST THE OFFENDER. 02

STRUCTURE CO. :
SANRACHANA

GROUND FLOOR PLAN