


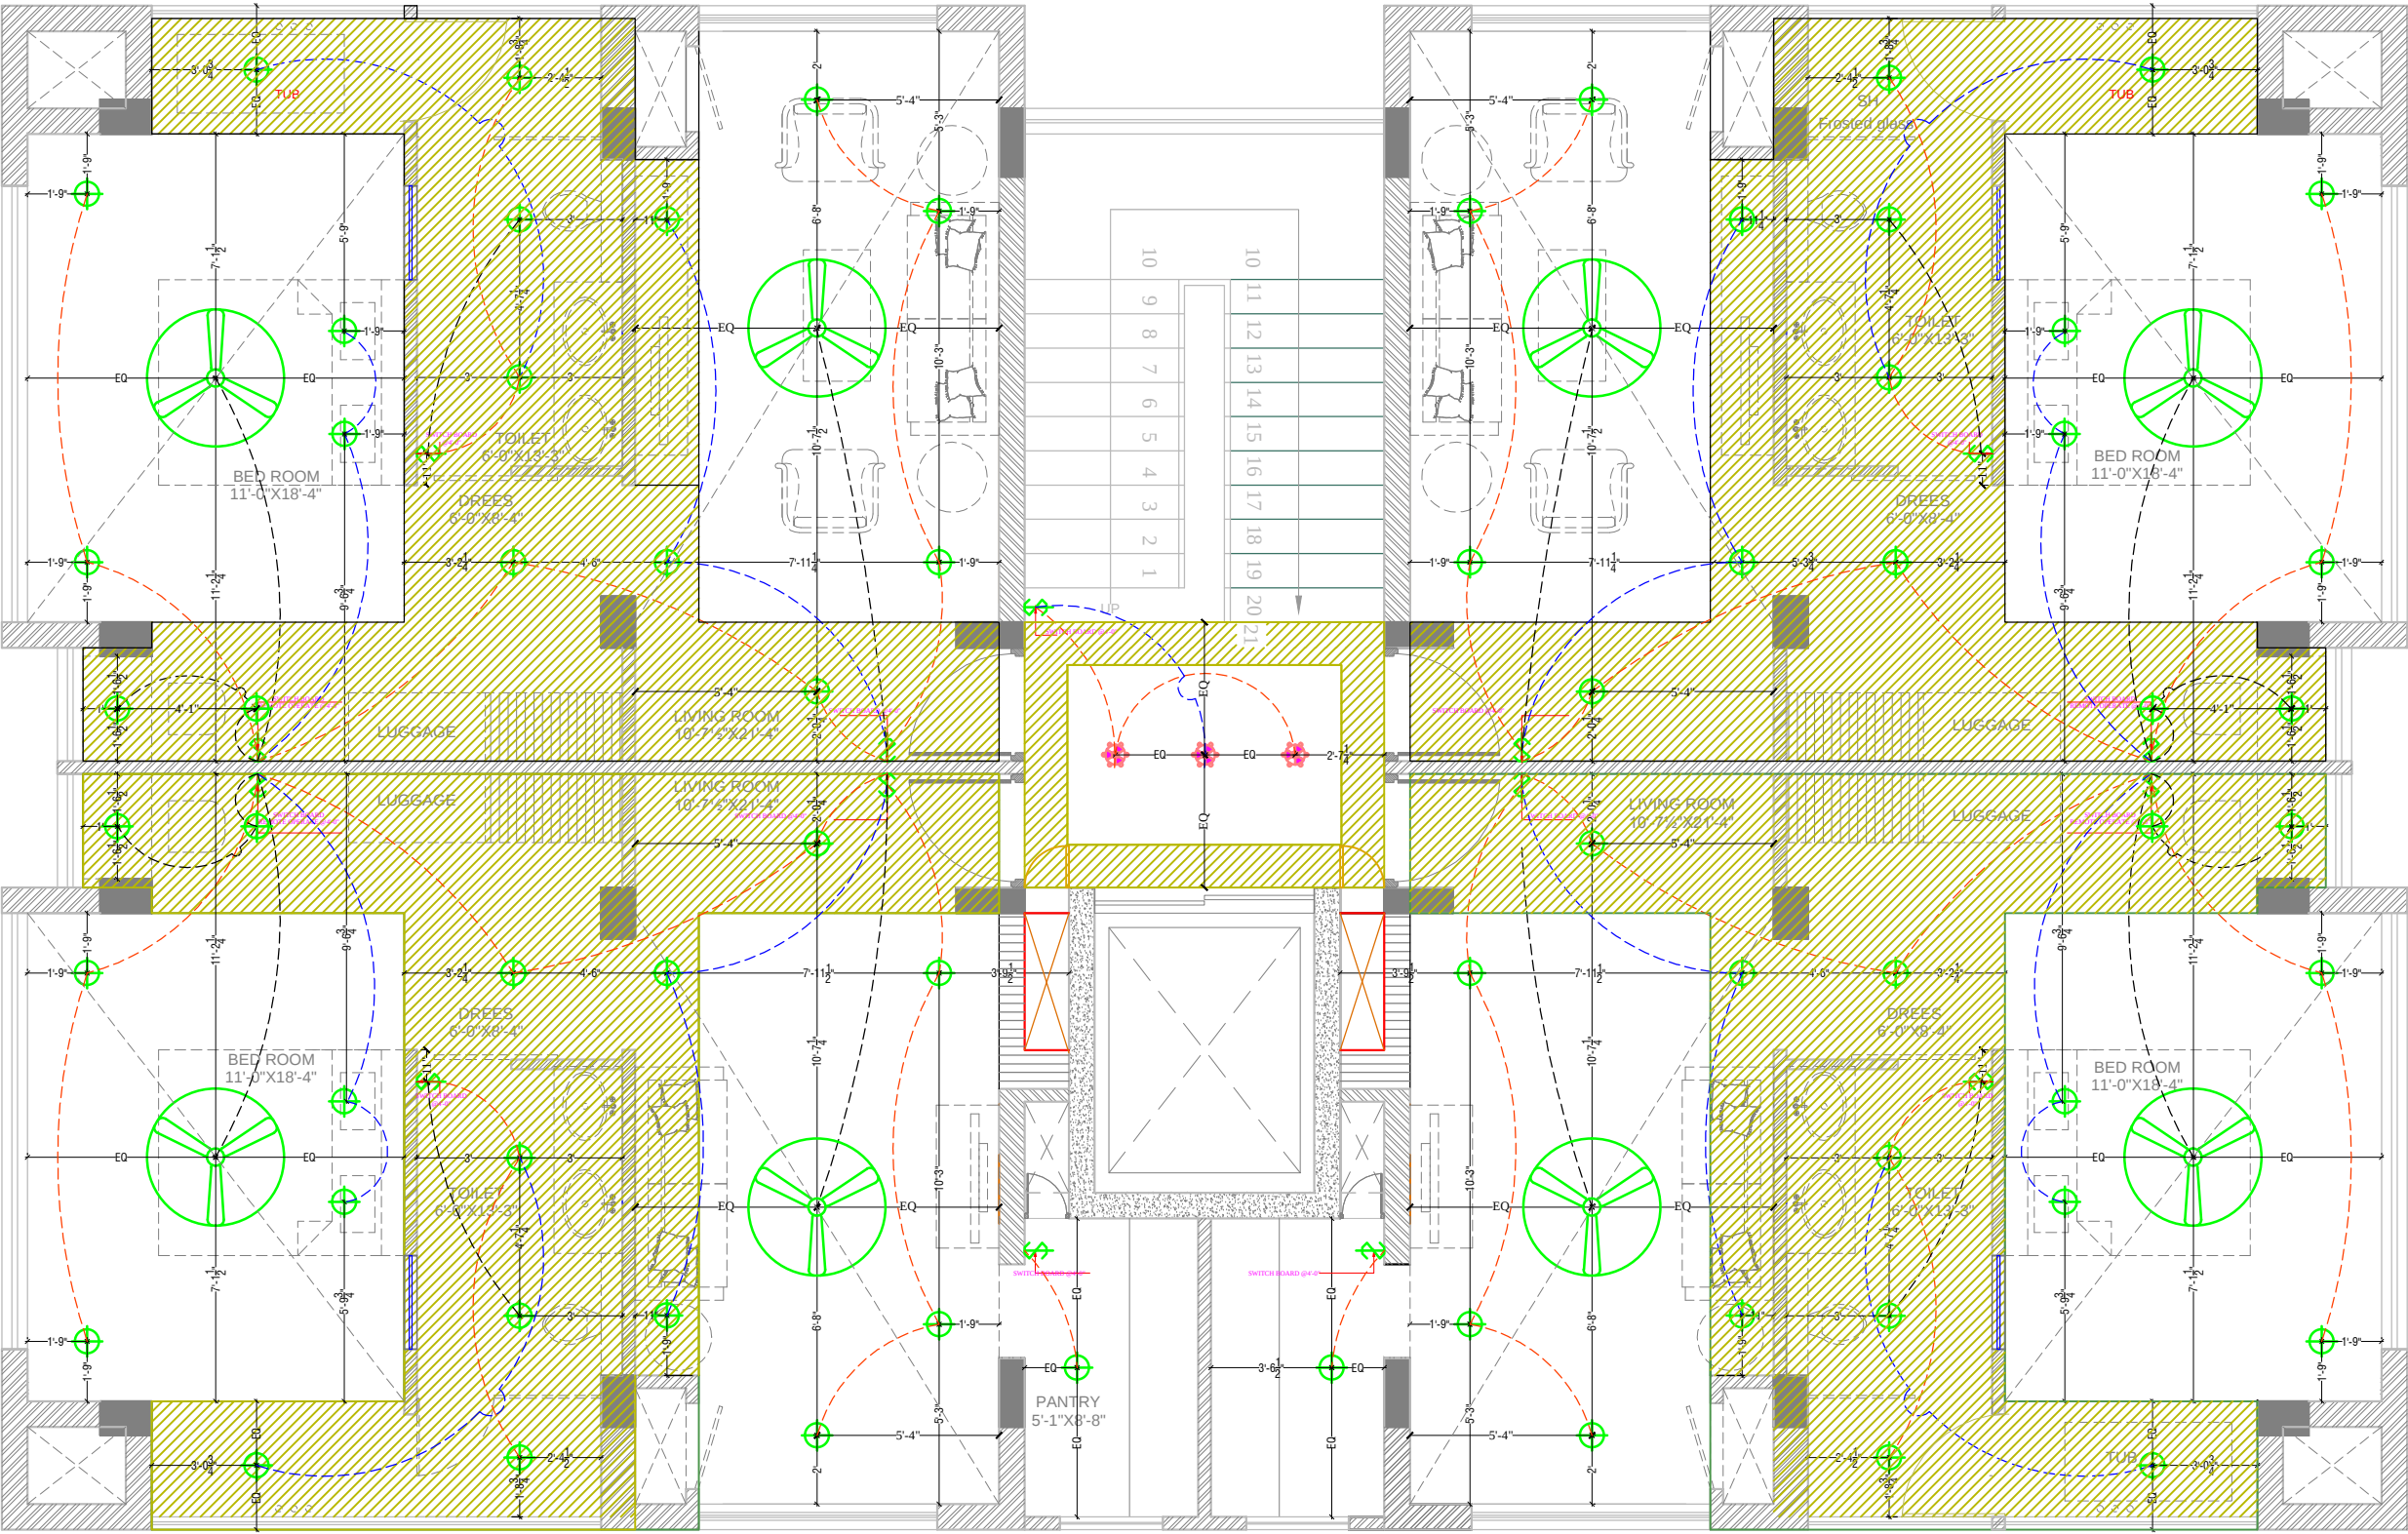

TYPICAL FLOOR CEILING ELECTRICAL PLAN

LEGEND - ELECTRICAL			
S.NO.	SYMBOL	DESCRIPTION OF ITEM	HT.
1		CEILING FAN	
2		SWITCH BOARD	
3		BRACKET LIGHT	7'-0"
4		RETROFIT CFL INTEGRATED	
5		SWITCH SOCKET 6A.	
6		SWITCH SOCKET 16A.	
7		ANTENNA	
8		TELEPHONE	
9		CHANDELIER	
10		DISTRIBUTION BOX	
11		PICTURE LIGHT	7'-0"
12		HANGING LIGHT	
13		CHANDELIER	
14		UPLIGHTERS	
15		DOWNLIGHTERS	
16		DONOT DISTURB (DND)	
17		CARD HOLDER	
18		AIR CONDITIONER	
19		FOOT LIGHT	

ARCHITECT:
NEERAV GUPTA
CA/2009/44766
L-1, KRISHNA MARG, C- SCHEME,
JAIPUR (302001) RAJASTHAN PIN-304023-268825
E-Mail: architect_neeravgupta@yahoo.com

PROJECT:
HOTEL CLARKS

DRAWING TITLE:
**ARCHITECTURAL
TYPICAL CEILING ELECTRICAL
PLAN/FLOOR PLAN**

DRAWN BY:
RAHUL

SCALE:
N.T.S

DATE:
24-12-2018

CHECKED BY:
NEERAV
GUPTA

DRAWING NO.:
 30/C/AR/06

NOTES:
THE COPYRIGHT AND PROPERTY OF THIS DESIGN AND DRAWING
BELONGS TO RAJESH KUMAR GUPTA, IT MUST NOT BE COPIED OR
REPRODUCED IN ANY MANNER WITHOUT THE WRITTEN
CONSENT. A LEGAL ACTION AS PER LAW MAY BE INITIATED
AGAINST THE OFFENDERS.