


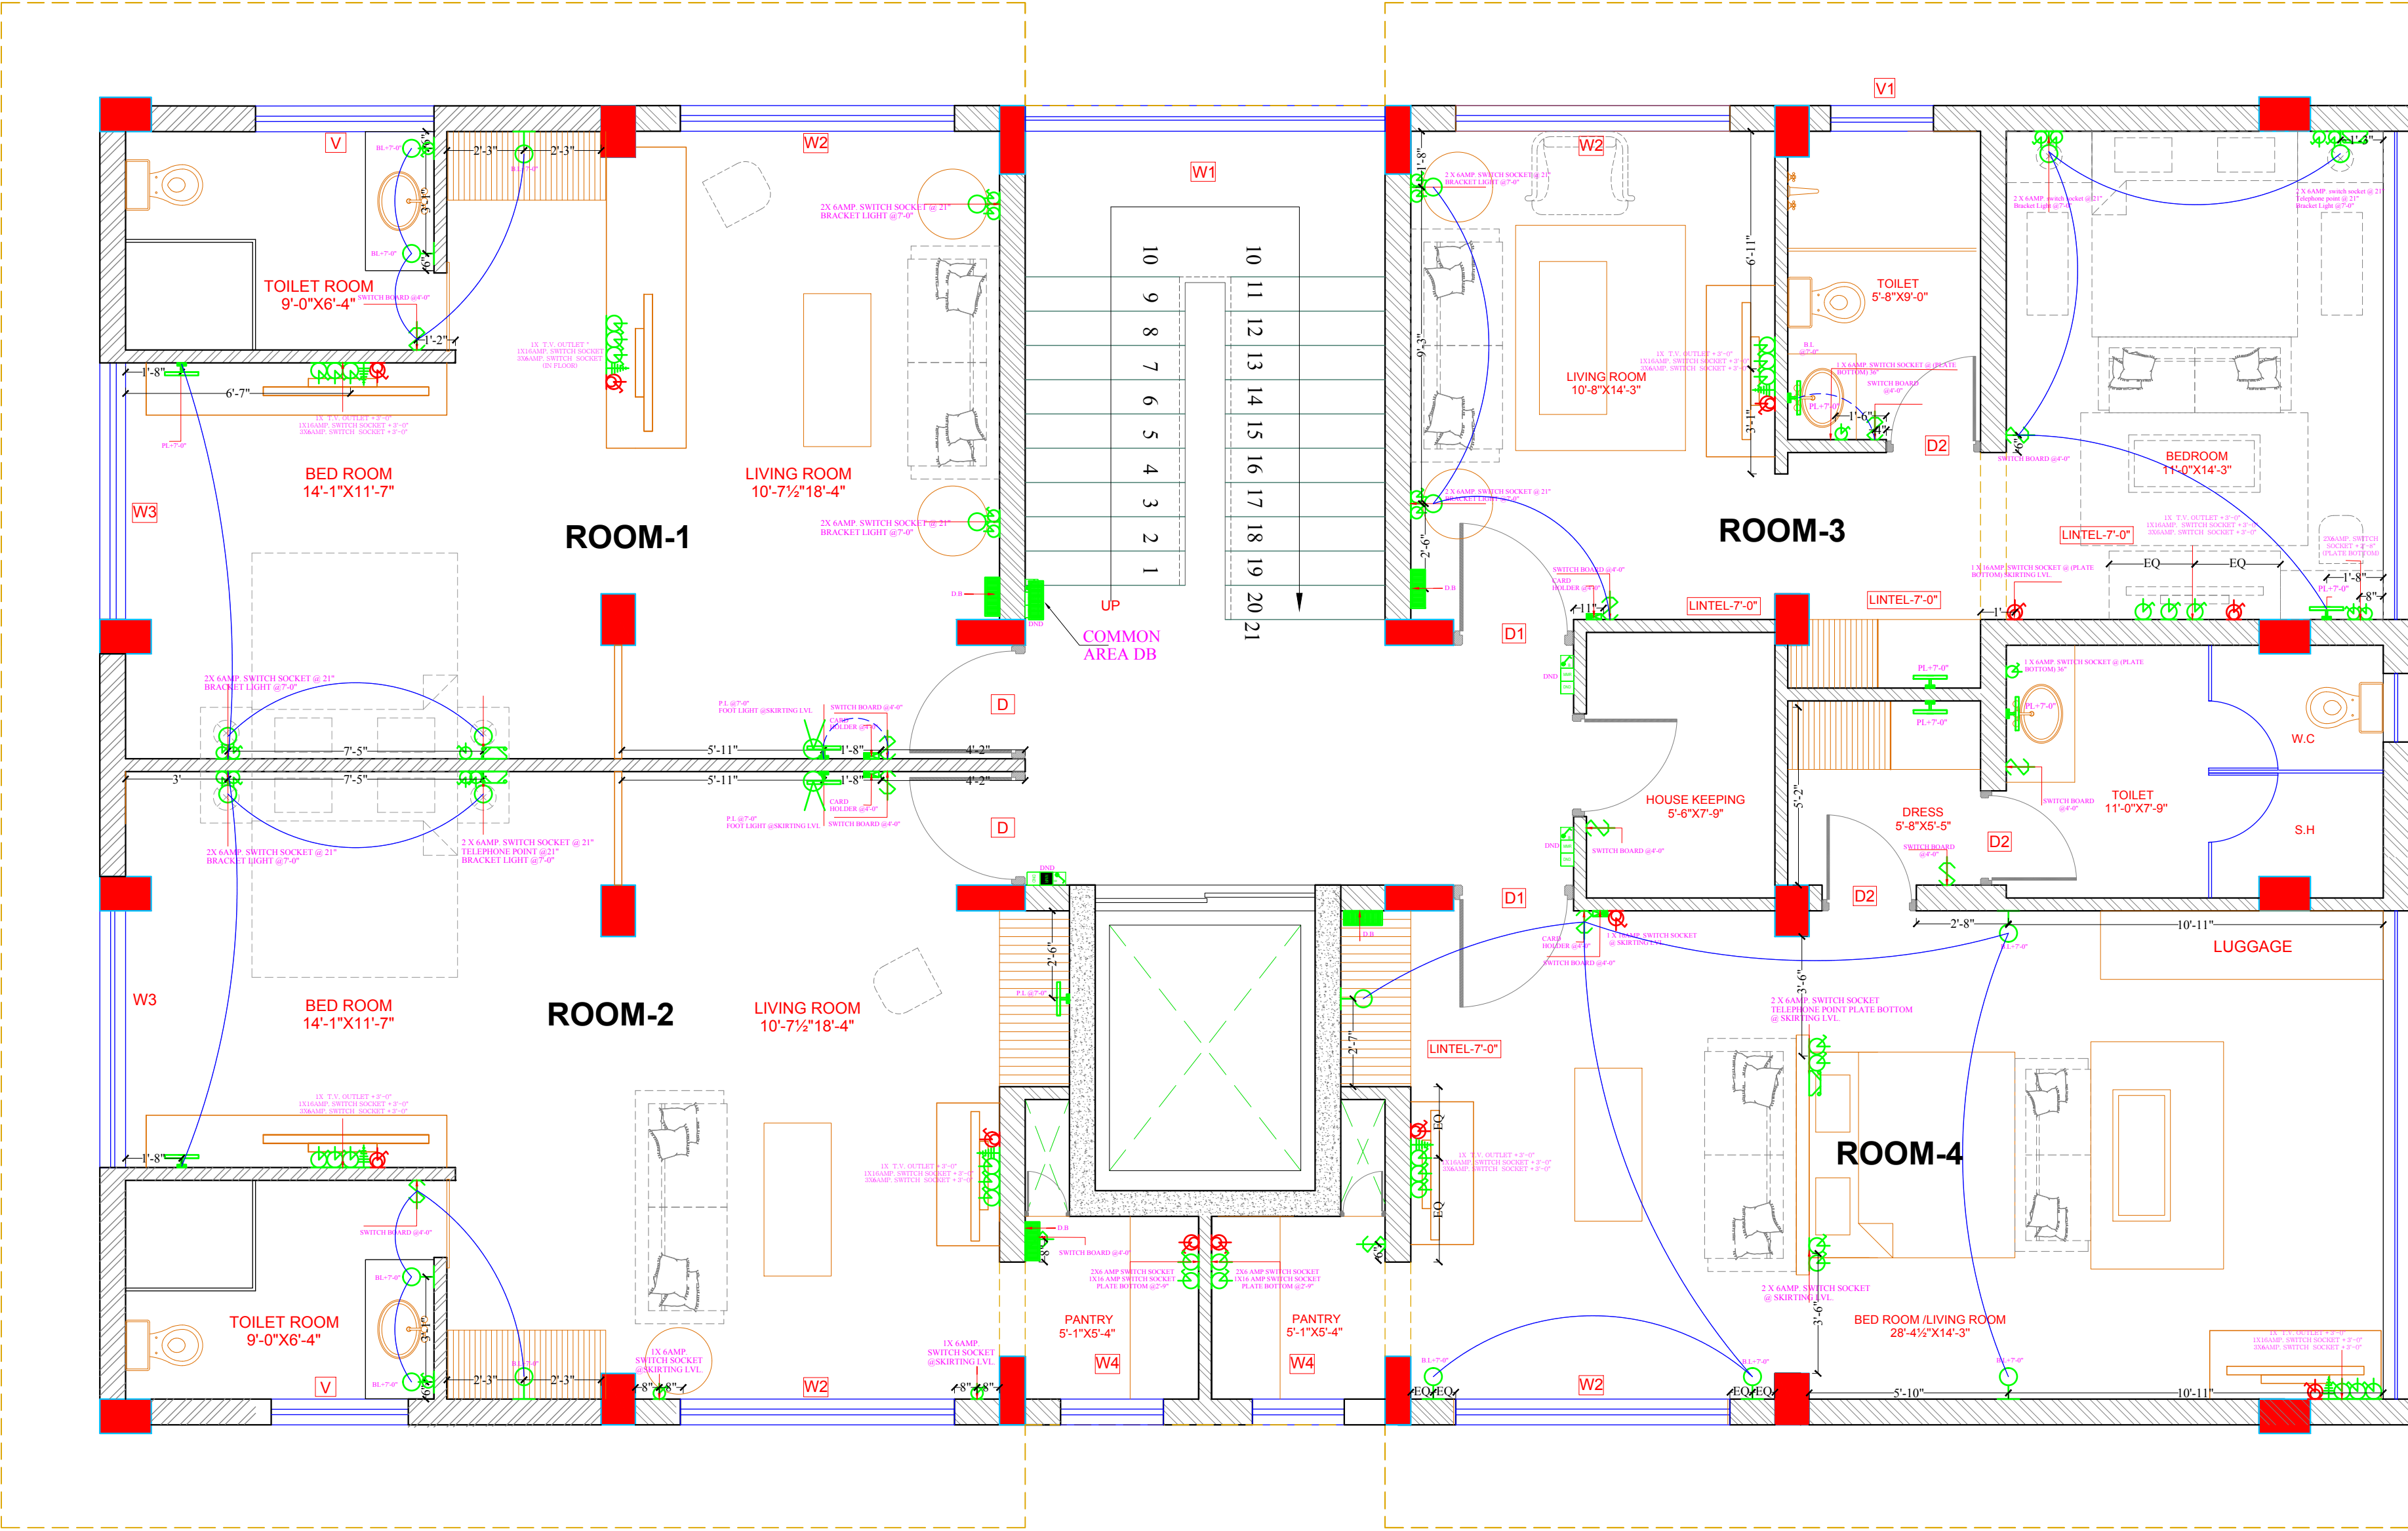

LEGEND - ELECTRICAL

S.NO.	SYMBOL	DESCRIPTION OF ITEM	HT.
1		CEILING FAN	
2		SWITCH BOARD	
3		BRACKET LIGHT	7'-0"
4		RETROFIT CFL INTEGRATED	
5		SWITCH SOCKET 6A.	
6		SWITCH SOCKET 16A.	
7		ANTENNA	
8		TELEPHONE	
9		CHANDELLIER	
10		DISTRIBUTION BOX	
11		PICTURE LIGHT	7'-0"
12		HANGING LIGHT	
13		CHANDELLIER	
14		UPLIGHTERS	
15		DOWNLIGHTERS	
16		DONOT DISTURB (DND)	
17		CARD HOLDER	
18		AIR CONDITIONER	
19		FOOT LIGHT	

GROUND FLOOR WALL ELECTRICAL PLAN

ARCHITECT:
NEERAV GUPTA
CA/2009/44766
L-1, KRISHNA MARG, C- SCHEME,
JAIPUR (302001), RAJASTHAN.PH.0141-2360825
E-Mail=architect_neeravgupta@yahoo.com

PROJECT:
HOTEL CLARKS

DRAWING TITLE:
**ARCHITECTURAL
(R-12)REVISED GROUND
FLOOR PLAN**

DRAWN BY: SCALE: DATE:
RAHUL N.T.S 22-12-2018

CHECKED BY: DRAWING NO.:
NEERAV GUPTA 30/C/AR/02

NOTES:
THE COPYRIGHT AND PROPERTY OF THIS DESIGN AND DRAWING
BELONGS TO RAVI KUMAR GUPTA. IT MUST NOT BE COPIED OR
REPRODUCED IN ANY MANNER WITHOUT THEIR WRITTEN
CONSENT. A LEGAL ACTION AS PER LAW MAY BE INITIATED
AGAINST THE OFFENDER.