



SYMBOL	DESCRIPTION
	SUPPLY AIR DUCT
	EXHAUST AIR DUCT
	FRESH AIR DUCT
	SUPPLY AIR DIFFUSER
	DUCT INSULATION
	DUCT ACOUSTIC
	EXHAUST AIR GRILLE
	RETURN AIR GRILLE
	CHW SUPPLY PIPE
	CHW RETURN PIPE
	DRAIN PIPE

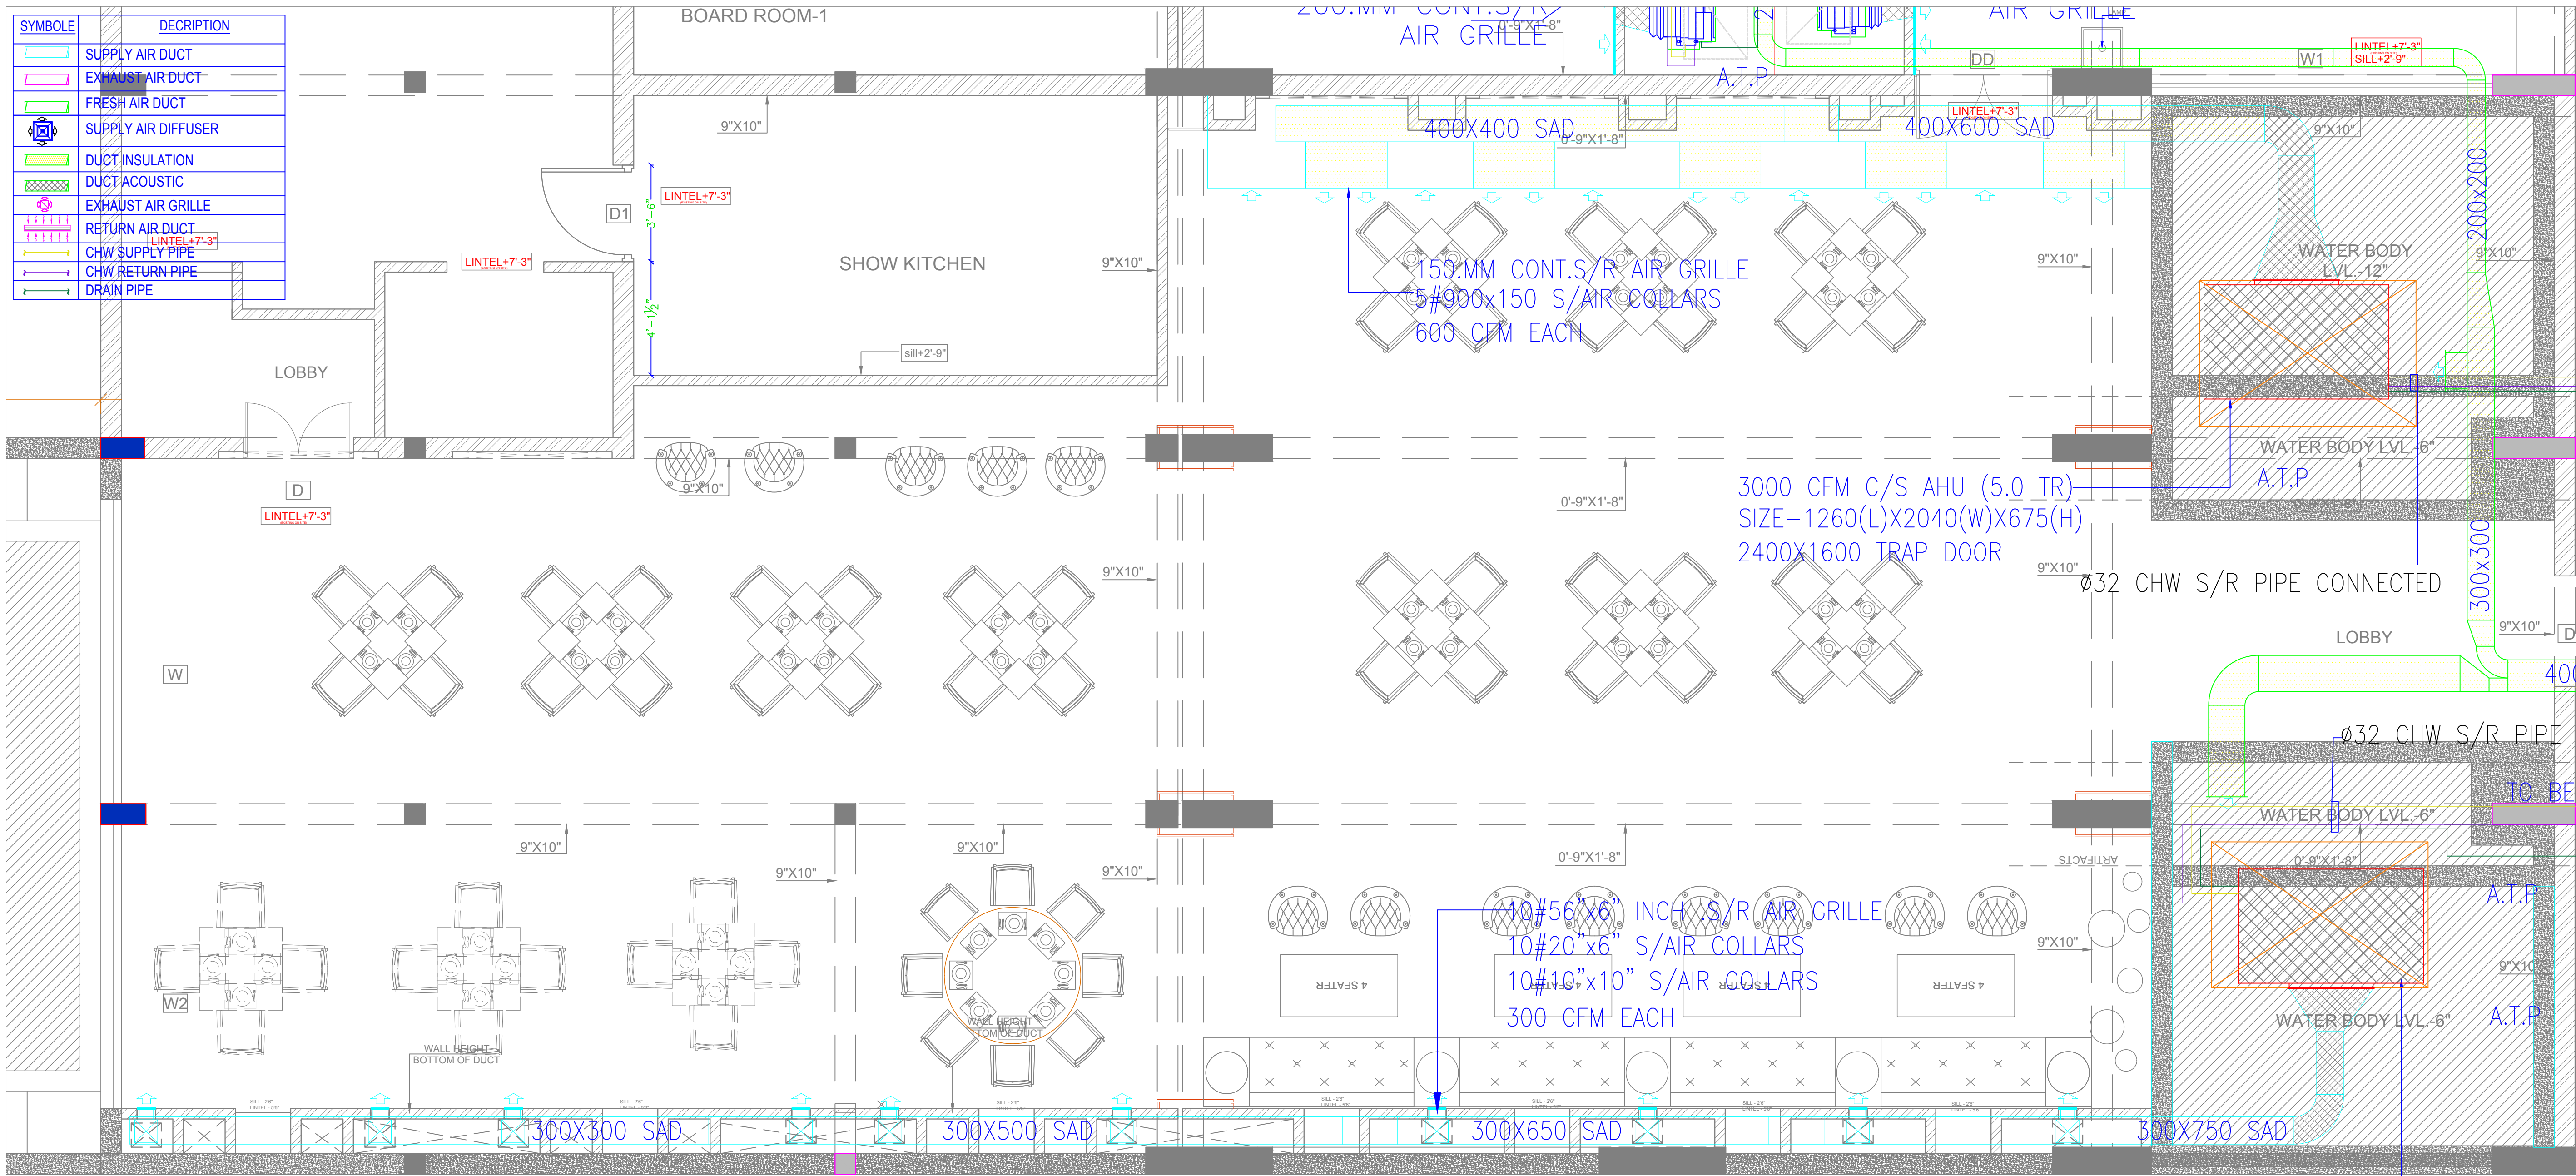

N

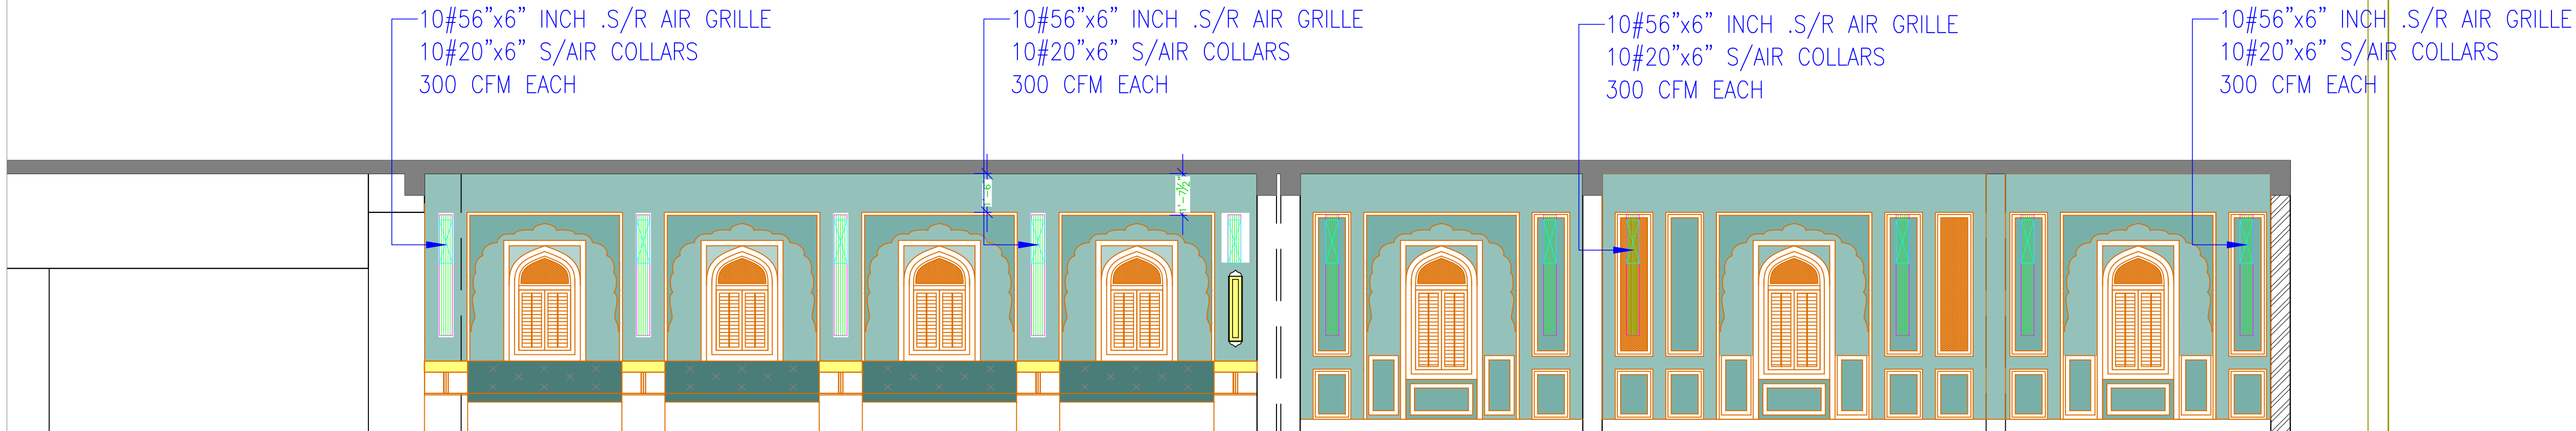

ELEVATION A

HOTEL CLARKS,
LUCKNOW

ARCHITECTS
NEERAV GUPTA
L-1, KRISHNA MARG, C- SCHEME,
JAIPUR (302001), RAJASTHAN.
PH.0141-2360825
E-Mail- architect_neeravgupta@yahoo.com

REVISED BASEMENT FLOOR
FALAKNUMA RESTAURANT
HVAC LAYOUT

SCALE: N.T.S.
PROJECT NO-41
DRAWING NO:
NGHCL/HVAC/01
REVISION NO:06
29.06.2019

SAN ENGINEERS & CONSULTANTS
G-2, JESS CHITRAKOOT SCHEME, NEAR PRAJAY STADIUM,
VARDOLI, JAIPUR-302015
E-mail: info@saneepl.com