


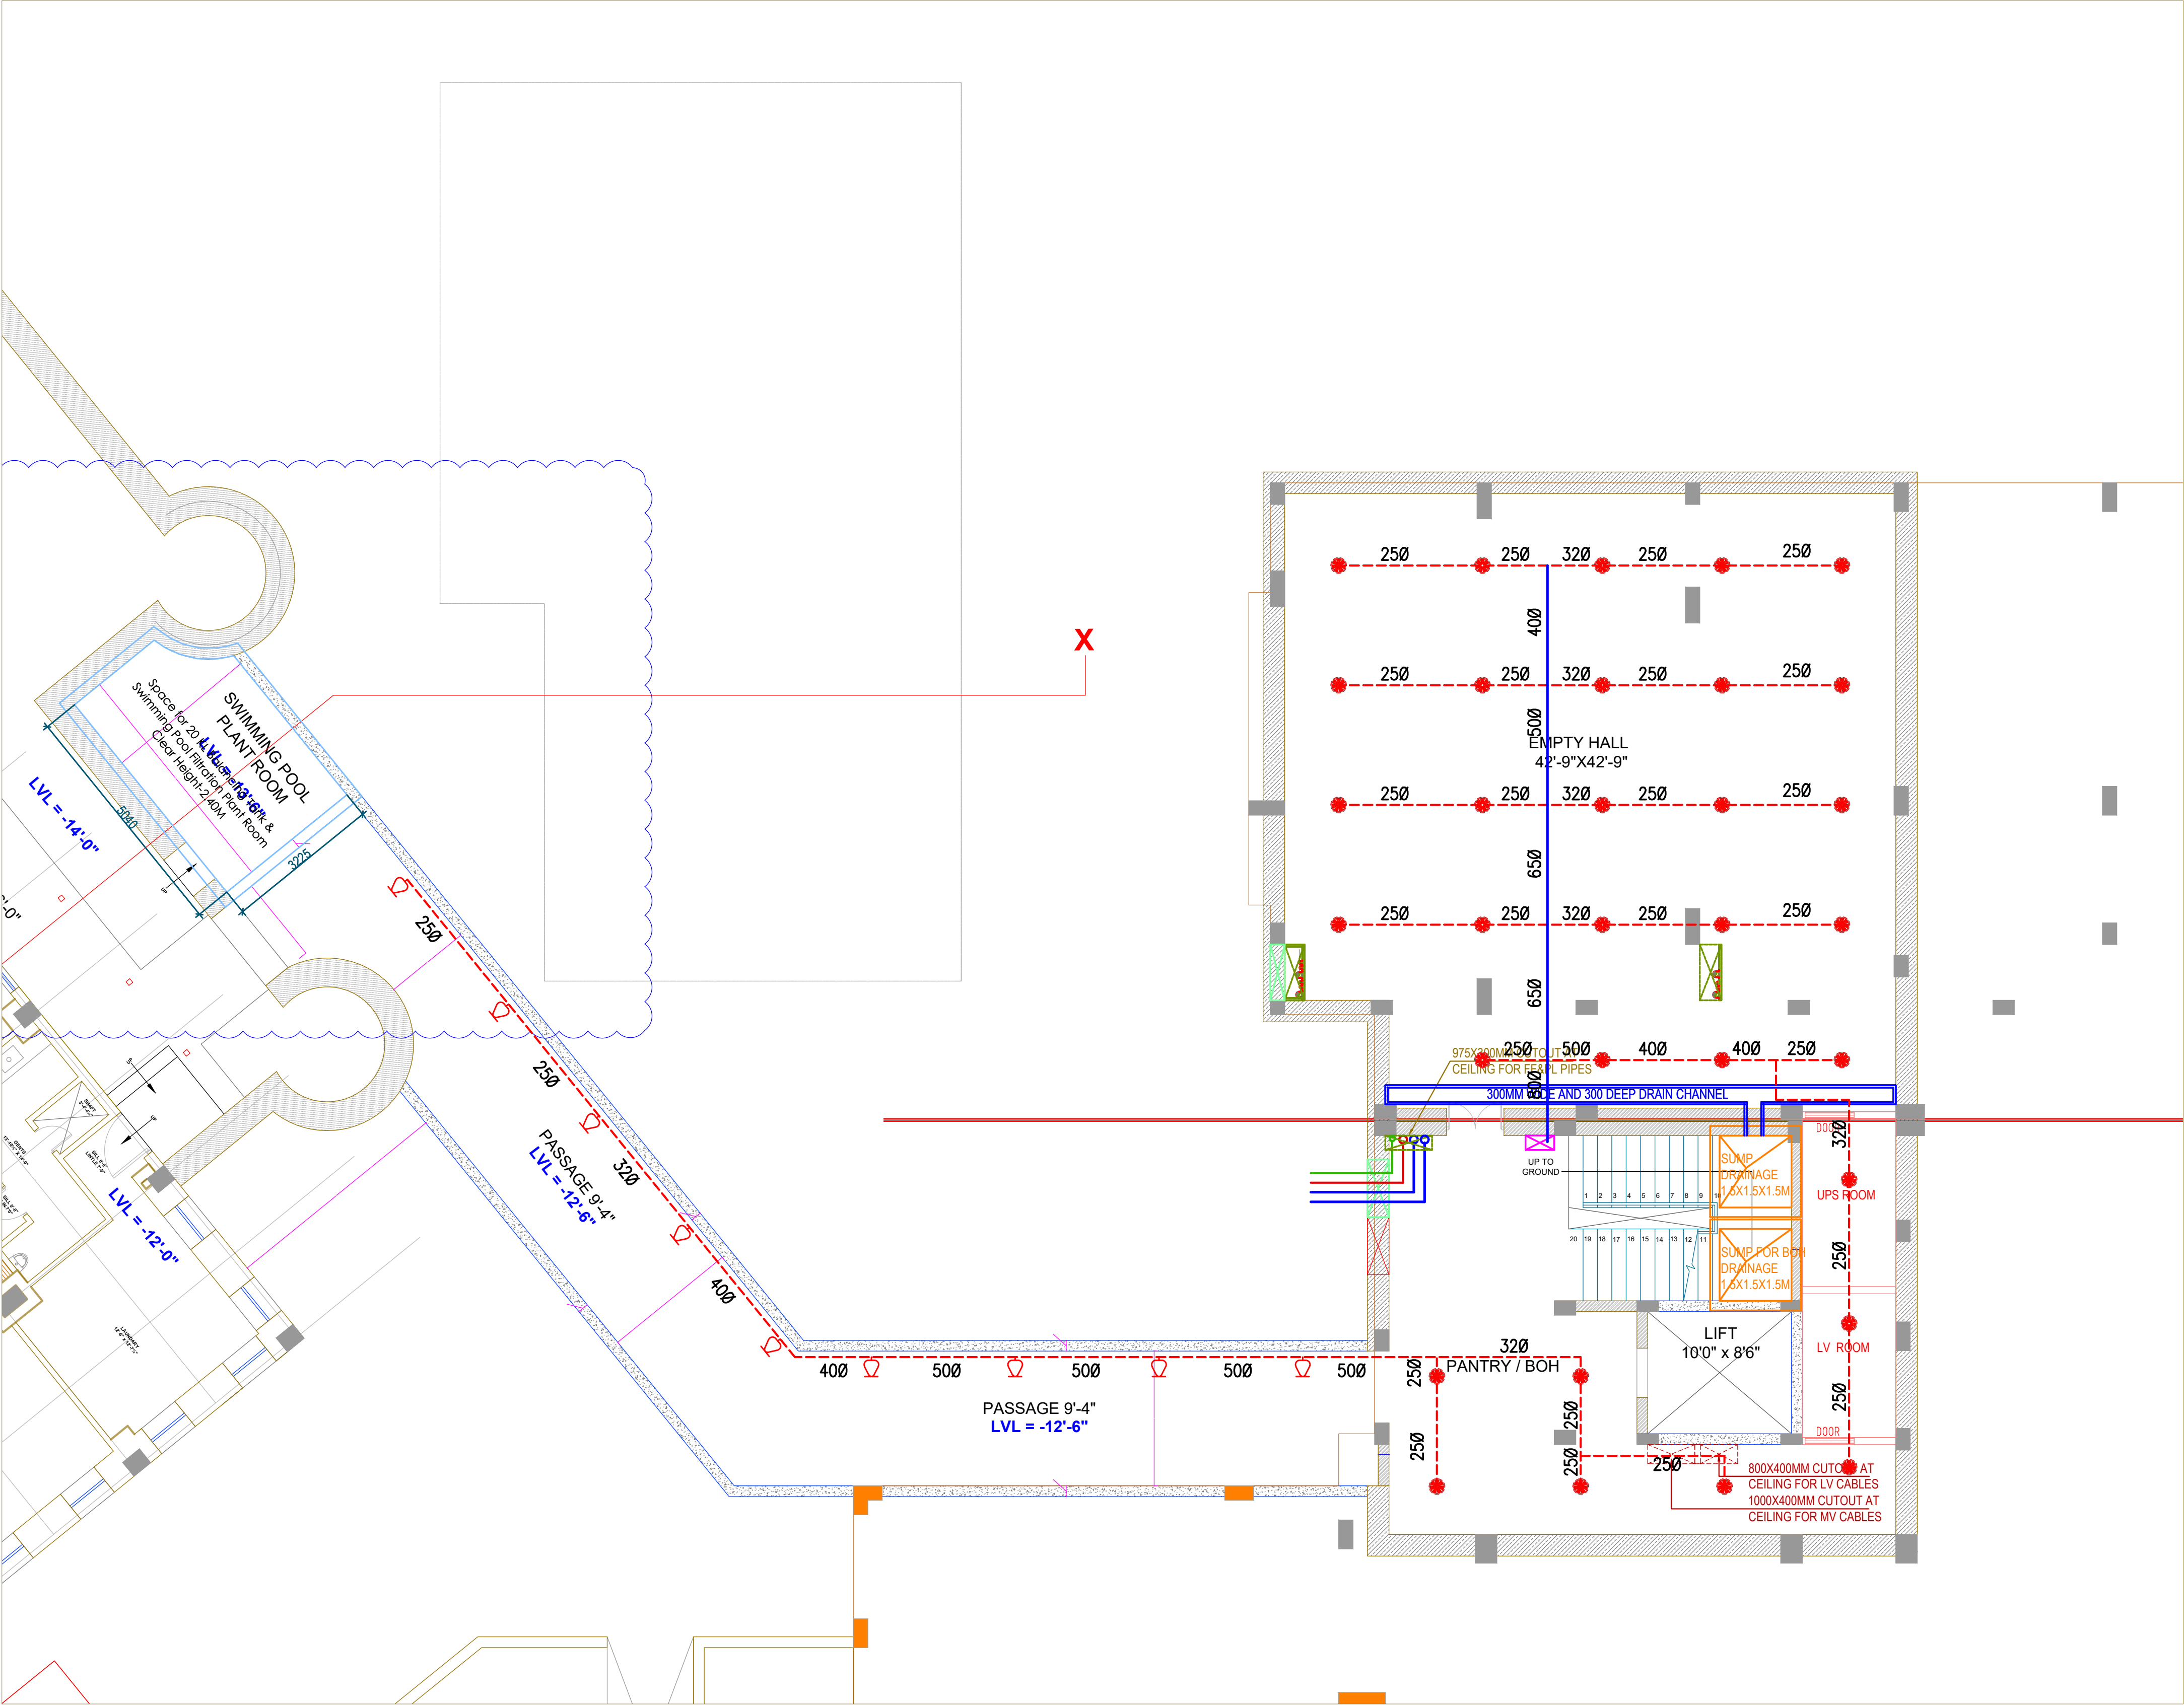

LEGENDS FOR FIRE FIGHTING:-	
(A)	100Ø FIRE HYDRANT RISER PIPE
(B)	150Ø FIRE SPRINKLER RISER PIPE
(C)	65Ø SPRINKLER DRAIN PIPE
	PENDENT SPRINKLER
	SIDE WALL SPRINKLER
	FLOW SWITCH
	ISOLATION VALVE
	SPRINKLER BRANCH PIPE
	MAIN SPRINKLER HEADER PIPE
F.H.C	FIRE HOSE CABINET CONSISTING:- 1. 1NO. 63mmØ LANDING VALVE 2. 1NO. 20mmØ 36.5M LONG HOSE REEL WITH DRUM 3. 1NO. 63mmØ BRANCH PIPE 4. 2NOS. 63mmØ R.R.L HOSE PIPE 5. 1NO. FIRE MEN AXE 6. 2NO. FIRE EXTINGUISHER

SCHEMATIC DRAWINGS		
REVISION NO.- R0		
MEPF CONSULTANT: NEWTECH CONSULTING ENGINEERS C-137/1, 3rd Floor, Vijay Vihar Phase - II (Rohini Sec.-1), New Delhi – 110085. (India)		
ARCHITECT: RAVI KUMAR GUPTA CA/83/7739 L-1, KRISHNA MARG, C- SCHEME, JAIPUR (302001), RAJASTHAN. PH.0141-2360825 E-Mail-ravigupta_15@yahoo.com		
DRAWING TITLE: BASEMENT FLOOR PLAN (FIRE FIGHTING LAYOUT)		
PROJECT: LAXMI PALACE / HOTEL		
DRAWN BY: SONU KUMAR	NORTH:	DATE: 09-01-2024
CHECKED BY: VIJAY KUMAR	DRAWING NO.: FF-00	SCALE: 1:100
NOTES: THE COPYRIGHT AND PROPERTY OF THIS DESIGN AND DRAWING BELONGS TO RAVI KUMAR GUPTA . IT MUST NOT BE COPIED OR REPRODUCED IN ANY MANNER WITHOUT THEIR WRITTEN CONSENT. A LEGAL ACTION AS PER LAW MAY BE INITIATED AGAINST THE OFFENDER.		
STRUCTURE CO. : SANRACHANA		

BASEMENT FLOOR PLAN