


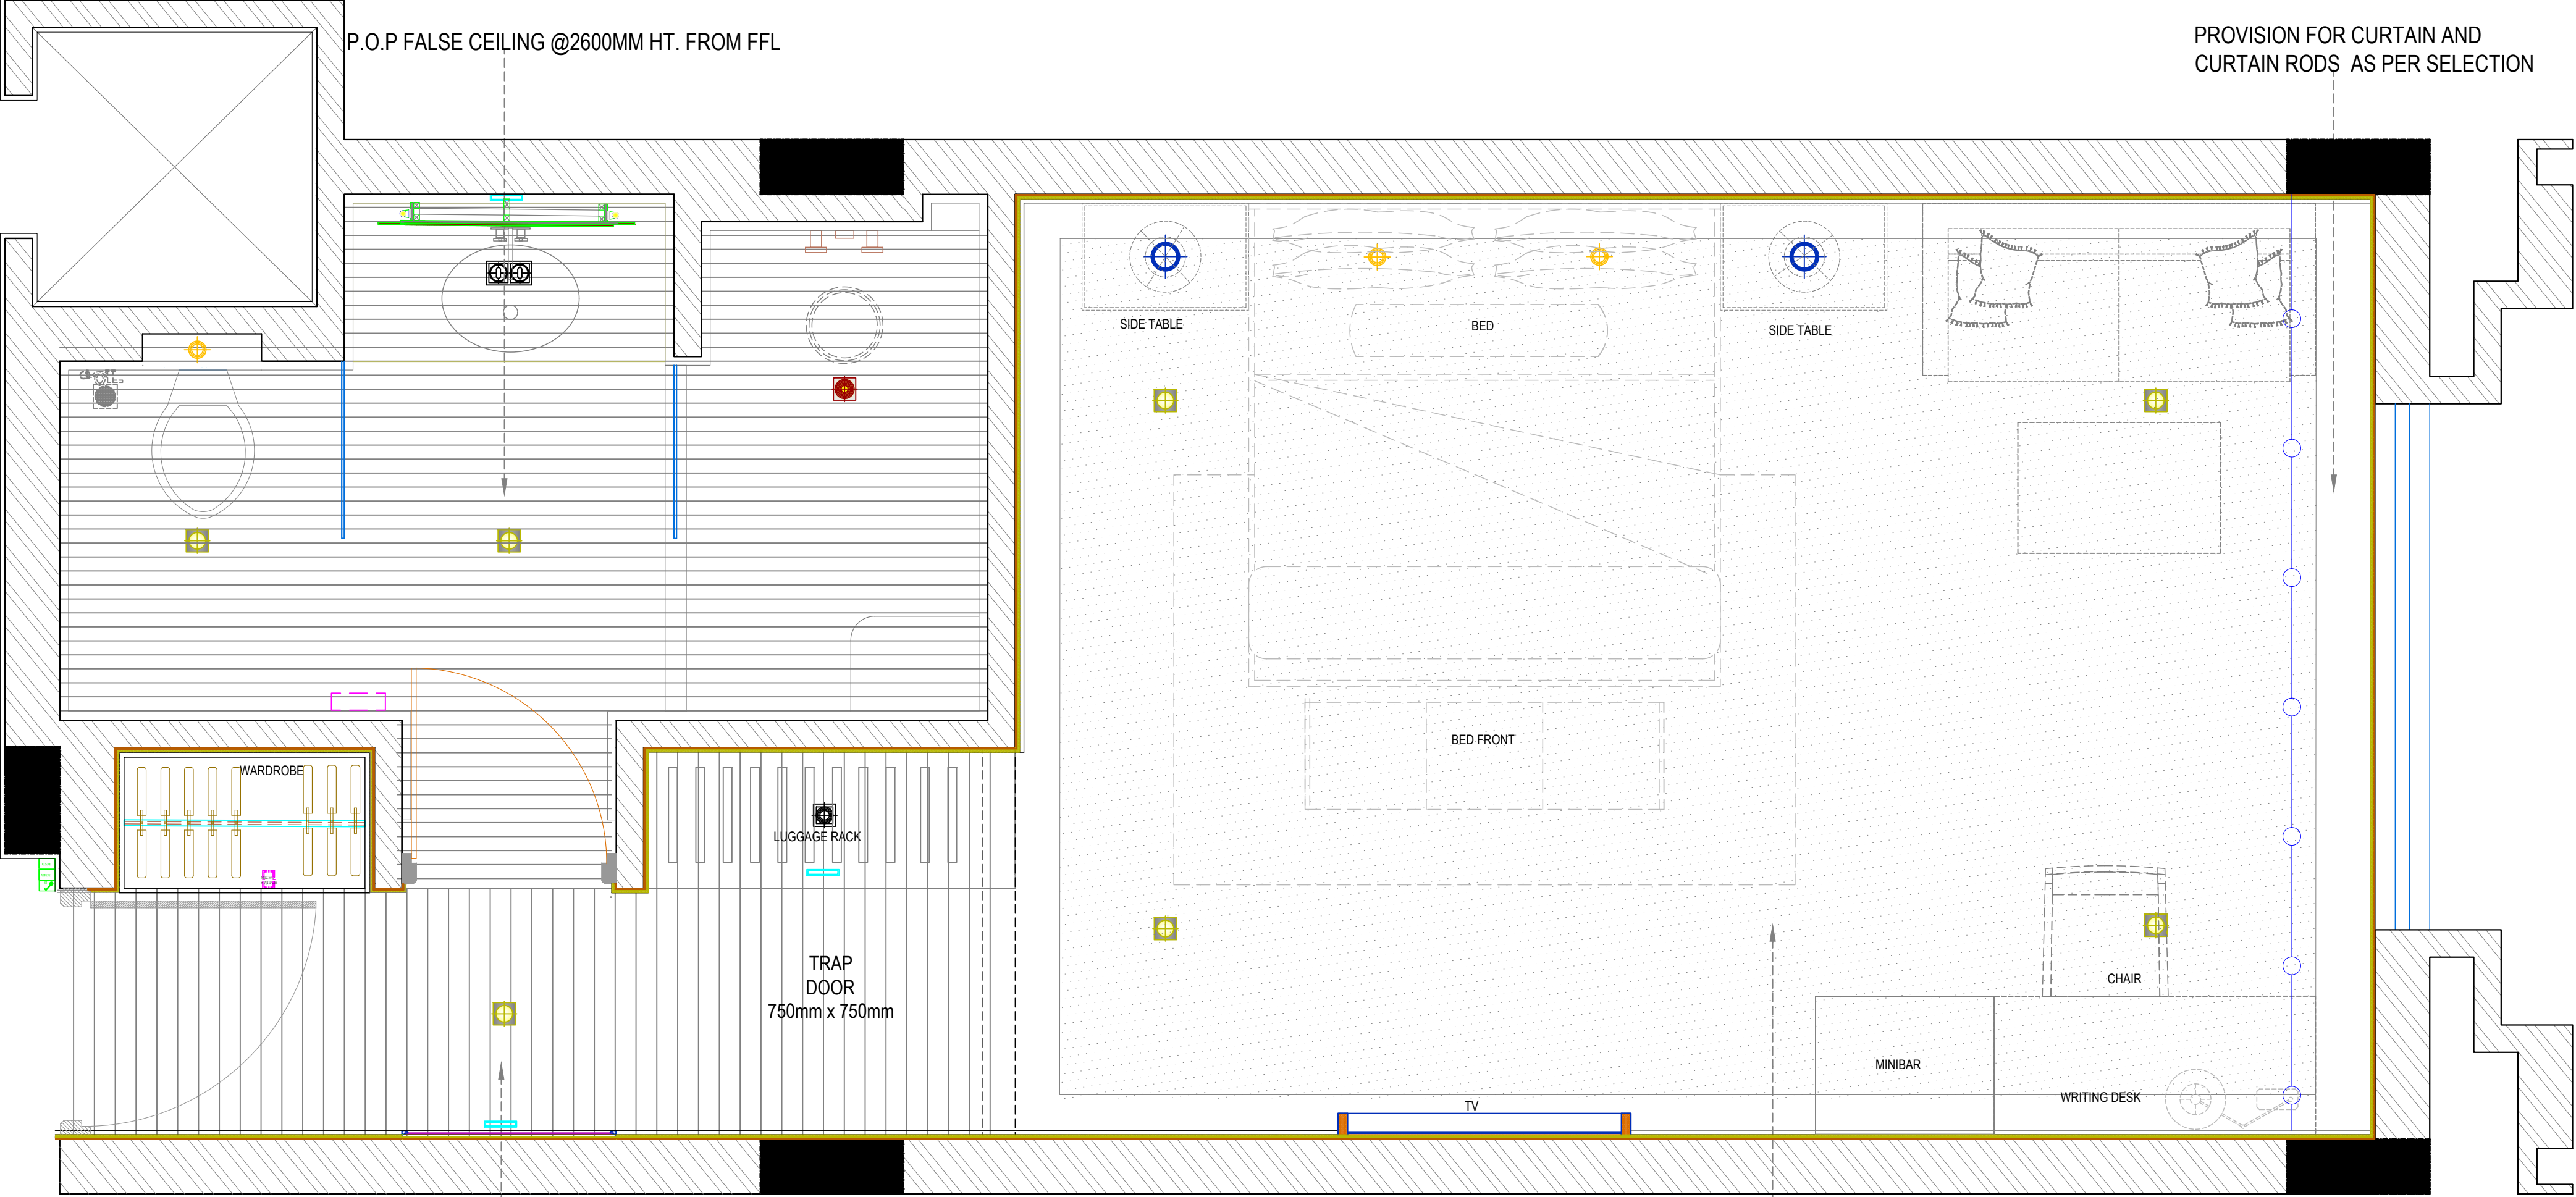

FALSE CEILING @2550MM HT. FROM
FFL FINISHED IN APP. VENEER TREATED WITH
P.U. MATT POLISH

GROUND FLOOR
ROOM NO.
16,18,22,30,32,34,35,37,39,40
1ST FLOOR
ROOM NO.
F16,F18,F22,F30,F32,F34,F35,F37,F39,F40

P.O.P MESH CEILING @2845MM HT. FROM F.F.L
FINISHED IN APP. SHADE OF PAINT

SR. NO.	SYMBOL	DESCRIPTION
1		ADJUSTABLE DOWN LIGHT
2		7 WATT DOWN LIGHT
3		ADJUSTABLE PIN SPOT
4		NIGHT LAMP
5		HANGING LIGHT
6		IP 65 RATED DOWN LIGHT
7		ADJUSTABLE DUAL WALL WASHER

ARCHITECT: RAVI KUMAR GUPTA CA/83/7739 L-1, KRISHNA MARG, C- SCHEME, JAIPUR (302001), RAJASTHAN, PH.0141-2360825 © 2019 architect_raavigupta@yahoo.com			
PROJECT: RESORTS OF MAKERS CHAMBER			
LOCATION: JAIPUR			
DRAWING TITLE : GUEST ROOM TYPE -2 KING ROOM REFLECTED CEILING PLAN			
DRAWN BY: DEEPIKA	SCALE: N.T.S	DATE: 20-11-2019	NORTH:
CHECKED BY: NEERAV GUPTA		DRAWING NO.	
NOTE: THE COPYRIGHT AND PROPERTY OF THIS DESIGN AND DRAWING BELONGS TO RAVI KUMAR GUPTA. IT MUST NOT BE COPIED OR REPRODUCED IN ANY MANNER WITHOUT THEIR WRITTEN CONSENT. A LEGAL ACTION SUIT PER LAW MAY BE INITIATED AGAINST THE OFFENDER.			