


LEGEND - ELECTRICAL		
S.NO.	SYMBOL	DESCRIPTION OF ITEM
1		CEILING FAN
2		SWITCH BOARD
3		MASTER SWITCH
4		CEILING LIGHT
6		SWITCH SOCKET 6A.
7		SWITCH SOCKET 16A.
9		TELEPHONE
10		DISTRIBUTION BOX
11		TUBE LIGHT
12		AC POINTS
13		UPLIGHTER (FLOOR LIGHT)
14		SPRINKLER
15		SMOKE DETECTOR
16		AC
17		speakers

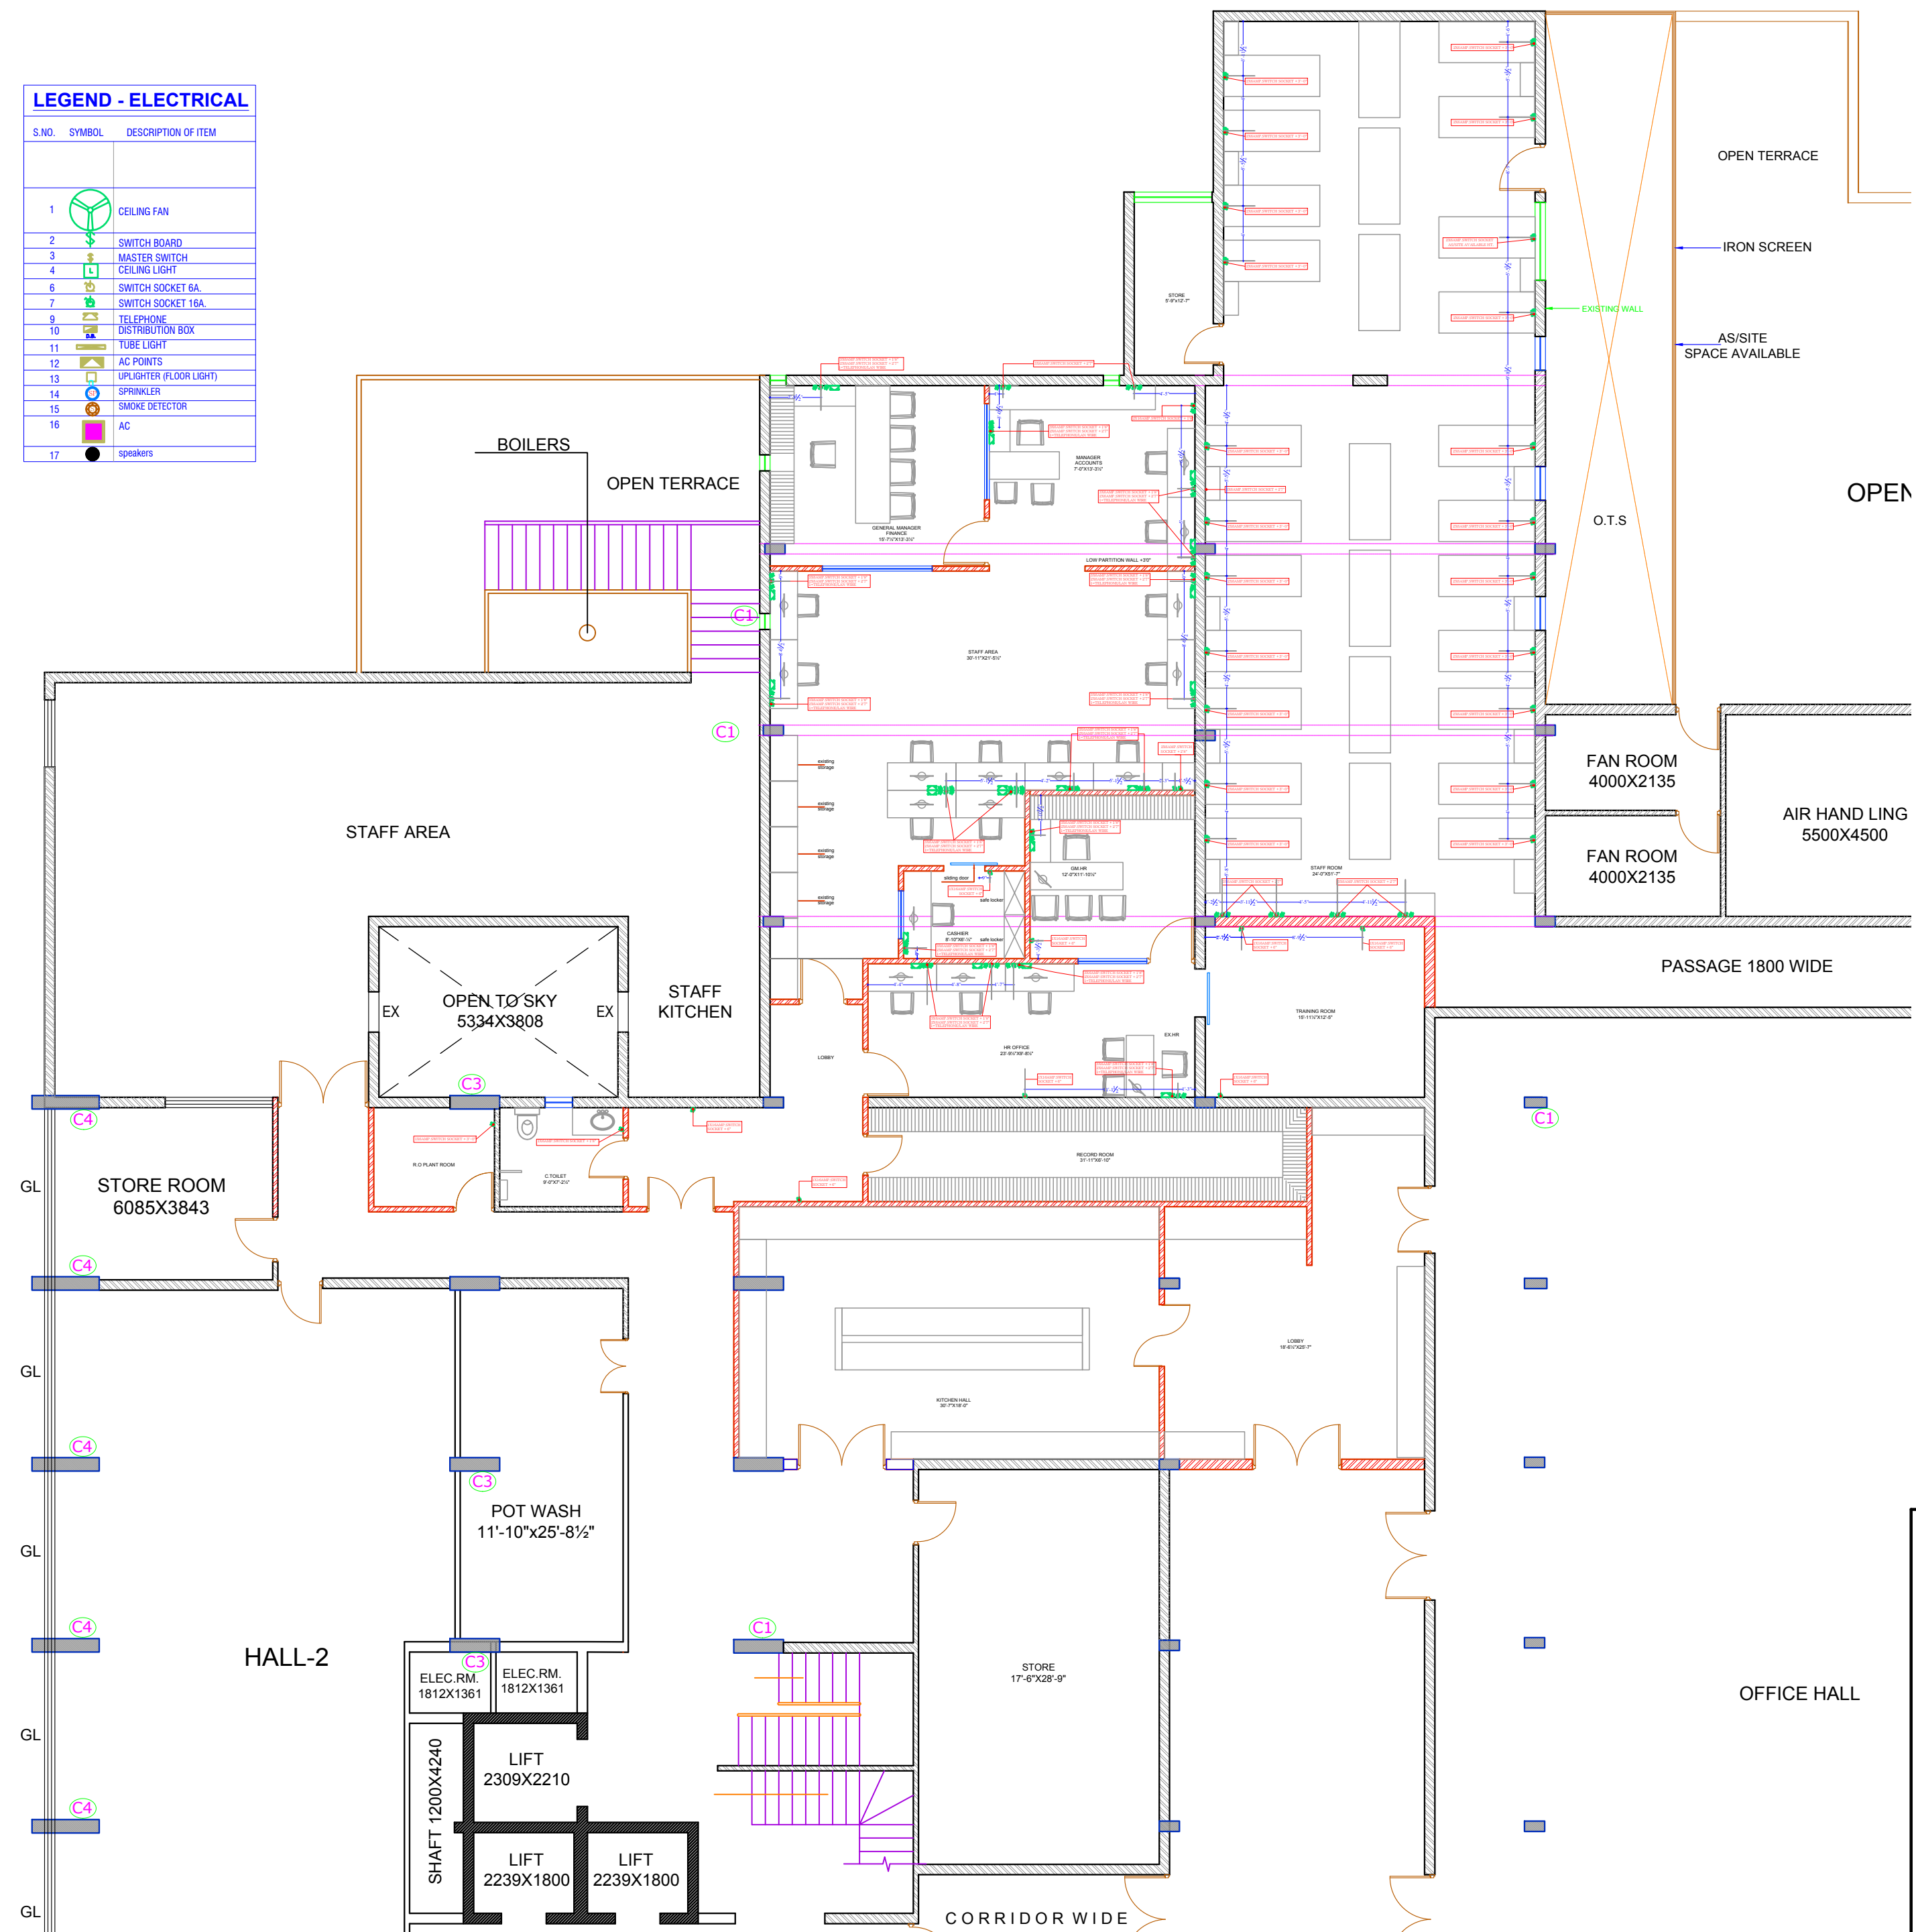

ARCHITECT: NEERAAM GUPTA L-1, KRISHNA MARG, C- SCHEME, JALPAIGUJI (302001), RAJASTHAN, PIN-304112-2560025 E-Mail-architect_neeraamgupta@yahoo.com		
PROJECT: CLARKS DRAWING TITLE: ACCOUNTS AND HR WALL ELECTRICAL PLAN		
DRAWN BY: RAHUL	SCALE: N.T.S.	DATE: 24-08-2018
CHECKED BY: NEERAAM GUPTA	SHEET NO :- 	C/AV/AC/EL02
NOTES: THE COPYRIGHT AND PROPERTY OF THIS DESIGN AND DRAWING BELONGS TO NEERAAM GUPTA. IT MUST NOT BE COPIED OR REPRODUCED IN ANY MANNER WITHOUT THEIR WRITTEN CONSENT. A LEGAL ACTION AS PER LAW MAY BE INITIATED AGAINST THE OFFENDER.		