


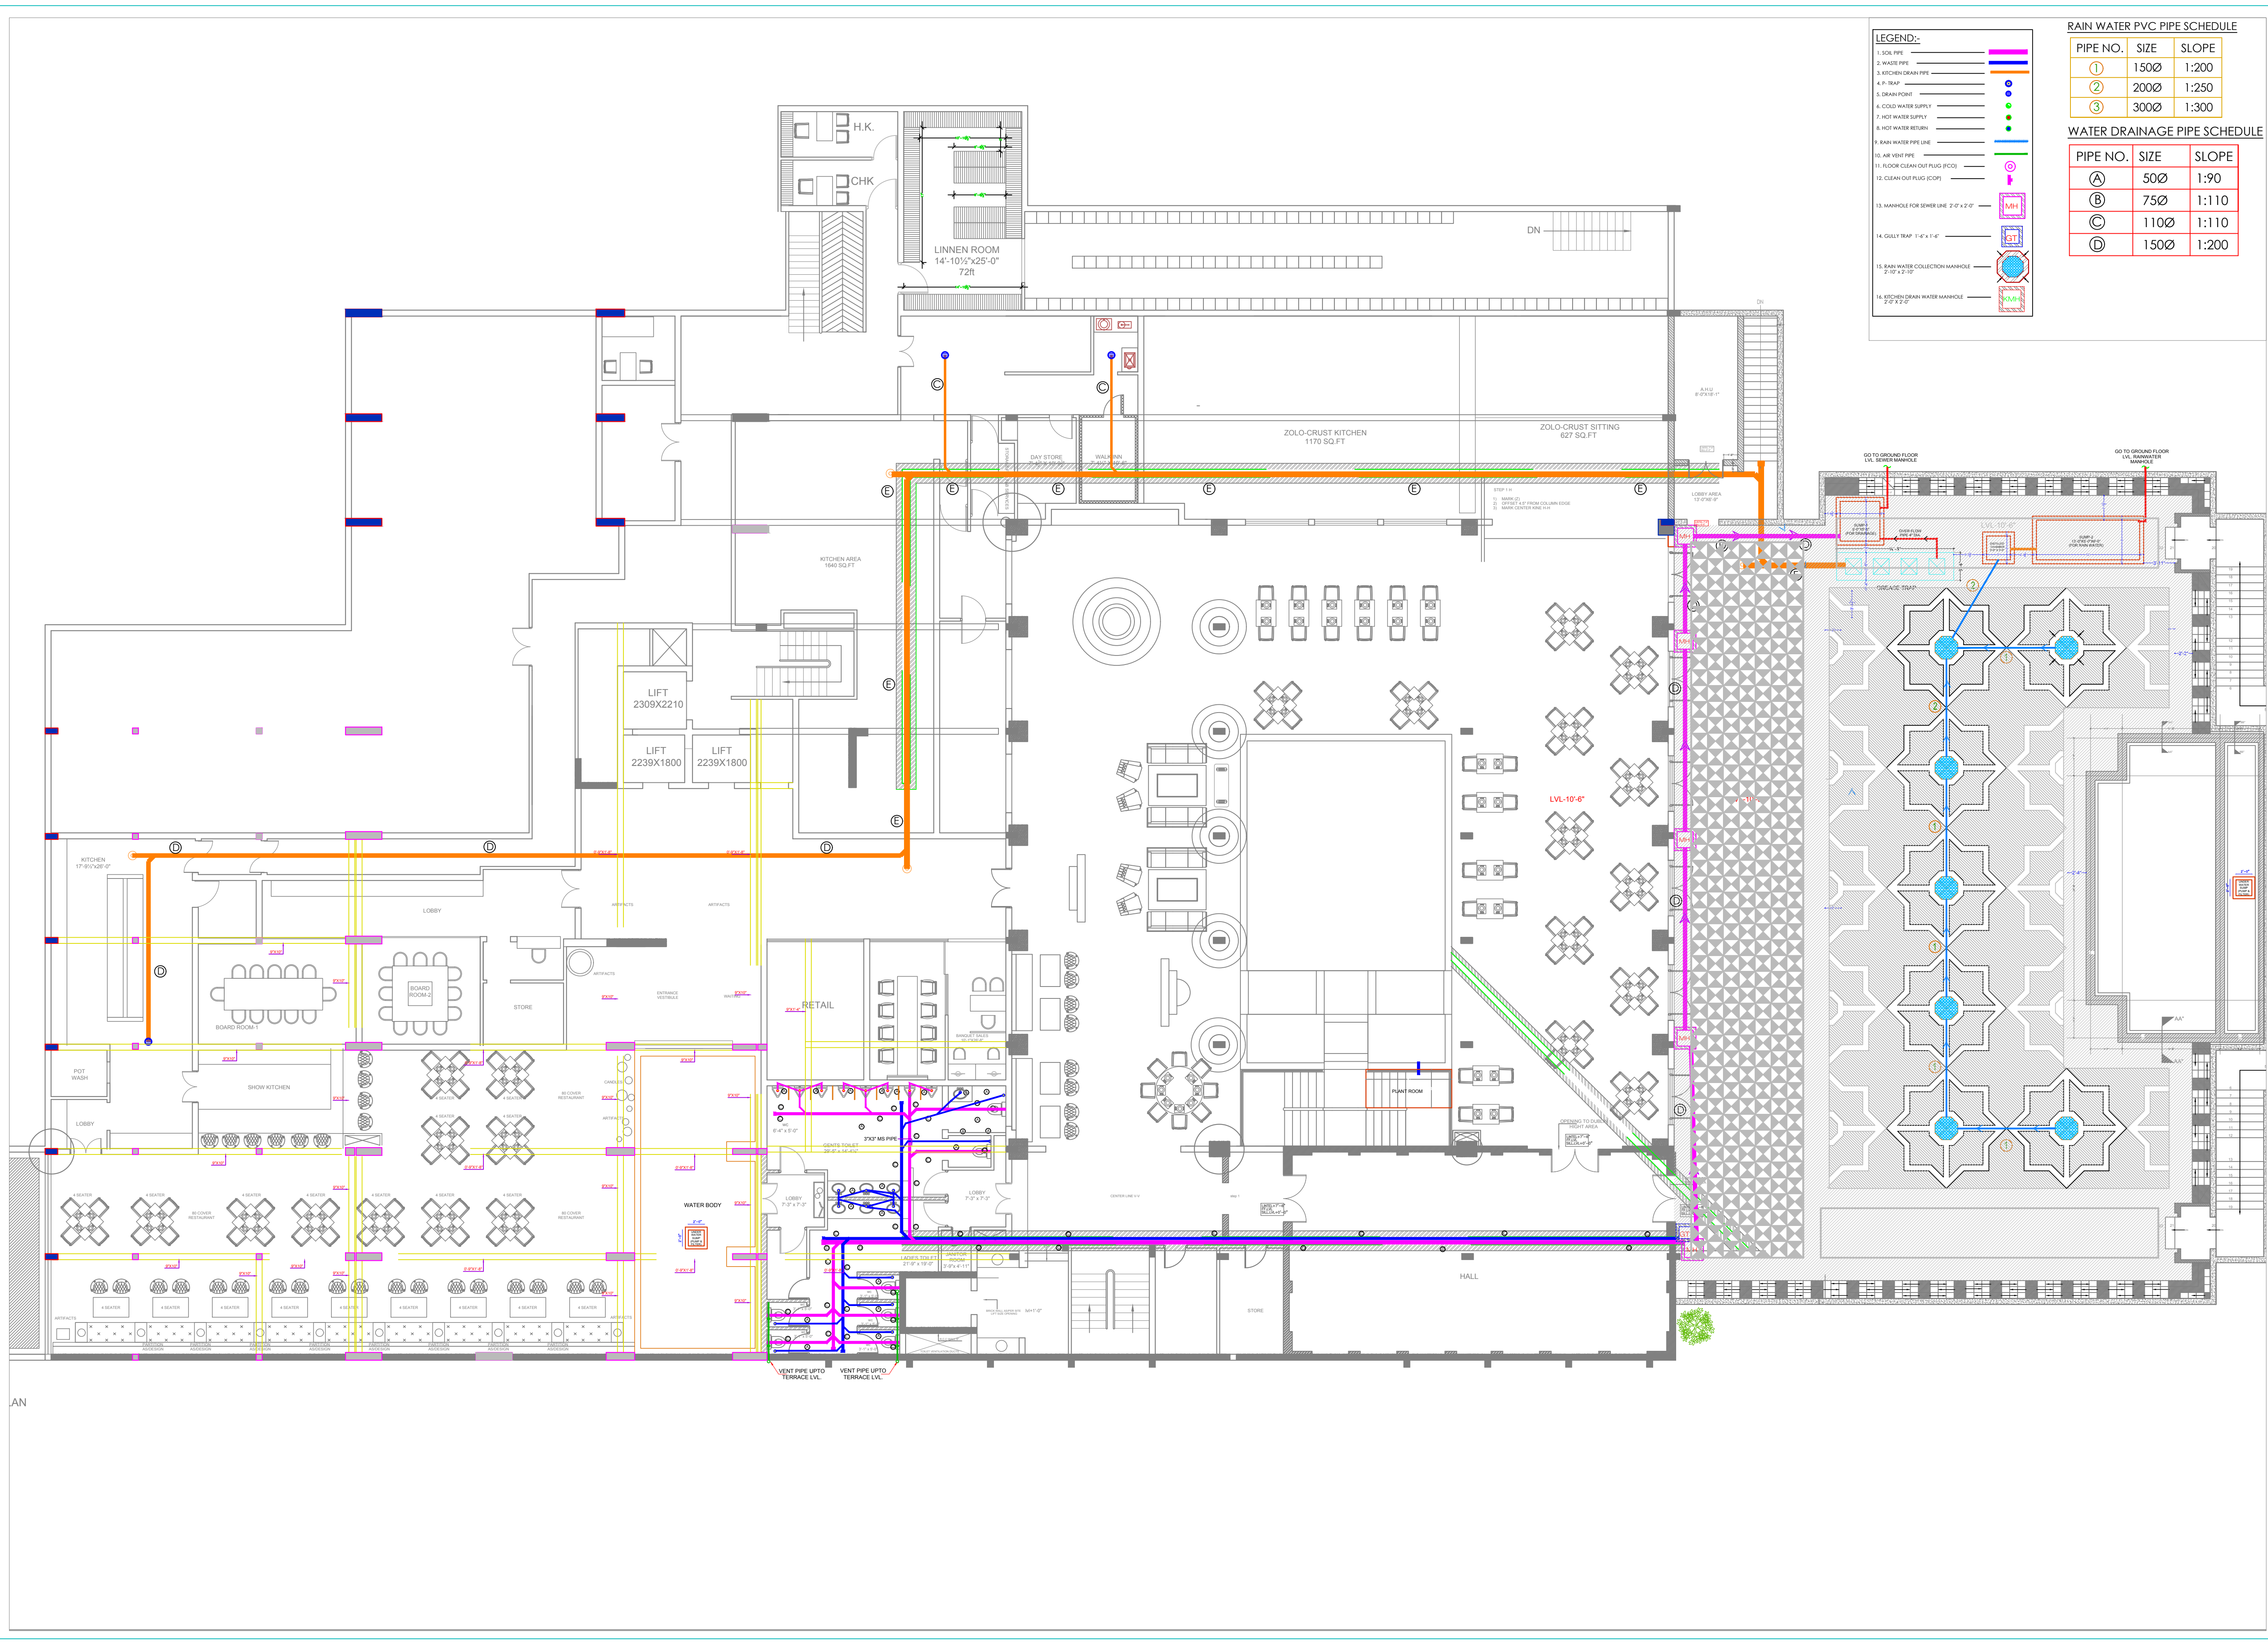

LEGEND:-

1. SOL PIPE	
2. WASTE PIPE	
3. KITCHEN DRAIN PIPE	
4. P. RAP	
5. DRAIN POINT	
6. COLD WATER SUPPLY	
7. HOT WATER SUPPLY	
8. HOT WATER RETURN	
9. RAIN WATER PIPE LINE	
10. AIR VENT PIPE	
11. FLOOR CLEAN OUT PLUG (FCO)	
12. CLEAN OUT PLUG (COP)	
13. MANHOLE FOR SEWER LINE 2'0" x 2'0"	
14. GULLY TRAP 1'-6" x 1'-6"	
15. RAIN WATER COLLECTION MANHOLE 2'0" x 2'0"	
16. KITCHEN DRAIN WATER MANHOLE 2'0" x 2'0"	

RAIN WATER PVC PIPE SCHEDULE

PIPE NO.	SIZE	SLOPE
①	150Ø	1:200
②	200Ø	1:250
③	300Ø	1:300

WATER DRAINAGE PIPE SCHEDULE

PIPE NO.	SIZE	SLOPE
A	50Ø	1:90
B	75Ø	1:110
C	110Ø	1:110
D	150Ø	1:200

ARCHITECTS

NEERAV GUPTA
L-1, KRISHNA MARG, C-SCHEME,
JAIPUR (302001), RAJASTHAN.
PH.0141-2360825
E-Mail- architect_neeravgupta@yahoo.com

BASEMENT FLOOR BAWDI AREA
TOILET, KITCHEN AREA DRAINAGE
LAYOUT AND OPEN AREA RAIN
WATER DRAINAGE LAYOUT

SCALE: N.T.S.

PROJECT NO:41
DRAWING NO:
NGHC/LU/05
REVISION NO:03
10.02.2019

SAN ENGINEERS & CONSULTANTS
G-2, 1055, CHITRAMOOT SCHEME, NEAR PRATAP STADIUM,
VAISALI NAGAR, BESIDE TAGORE FOUNDATION SCHOOL,
JAIPUR-302011 (+91-141-4626831)
E-mail- info@sanspe.com