


LEGEND - ELECTRICAL

S.NO.	SYMBOL	DESCRIPTION OF ITEM
1		CEILING FAN
2		SWITCH BOARD
3		MASTER SWITCH
4		CEILING LIGHT
6		SWITCH SOCKET 6A
7		SWITCH SOCKET 16A
9		TELEPHONE
10		DISTRIBUTION BOX
11		TUBE LIGHT
12		AC POINTS
13		UPLIGHTER (FLOOR LIGHT)
14		SPRINKLER
15		SMOKE DETECTOR
16		AC
17		speakers

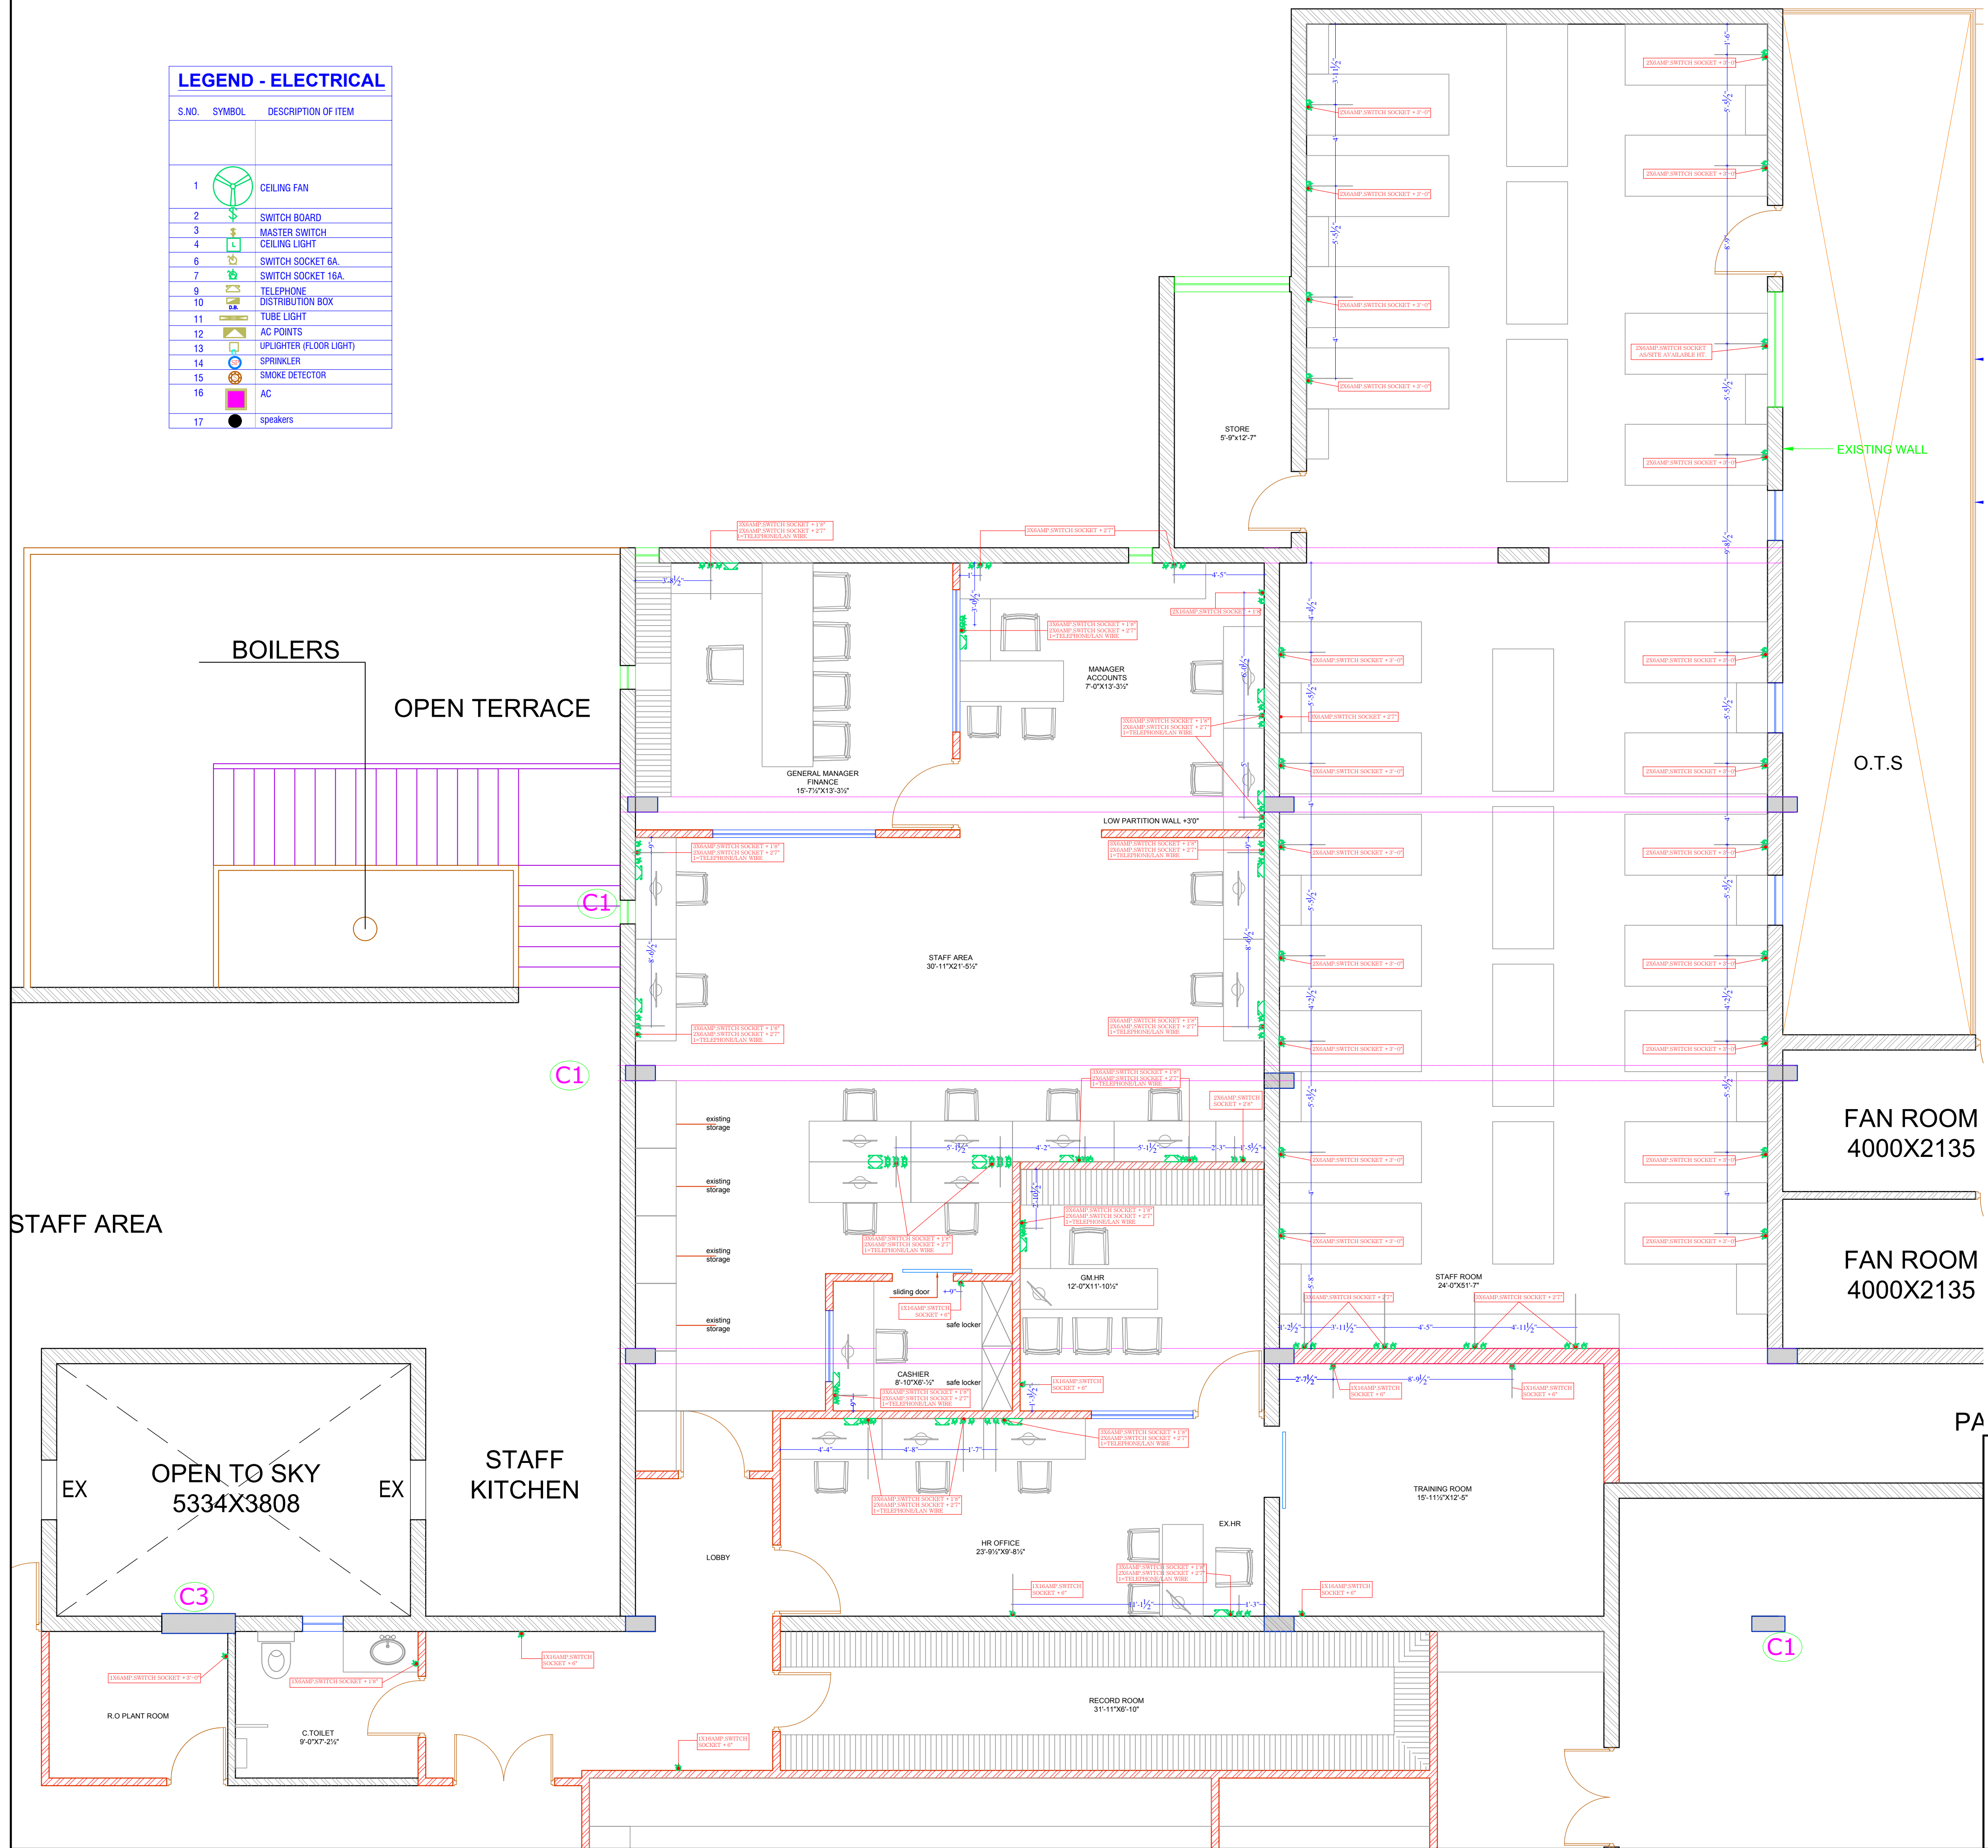

ARCHITECT:
NEERAV GUPTA
L-1, KRISHNA MARG, C- SCHEME,
JAIPUR (302001), RAJASTHAN.
PH:0141-2369825
E-Mail:architect_neeravgupta@yahoo.com

PROJECT:
CLARKS

DRAWING TITLE:
ACCOUNTS AND HR
WALL ELECTRICAL PLAN

DRAWN BY:	SCALE:	DATE:
RAHUL	N.T.S.	29-08-2018
CHECKED BY:	SHEET NO :-	
NEERAV GUPTA	C/AV/AC/EL/02	

NOTES:
THE COPYRIGHT AND PROPERTY OF THIS DESIGN AND DRAWING
BELONGS TO NEERAV GUPTA. IT MUST NOT BE COPIED OR
REPRODUCED IN ANY MANNER WITHOUT THEIR WRITTEN
CONSENT. A LEGAL ACTION AS PER LAW MAY BE INITIATED
AGAINST THE OFFENDER.