


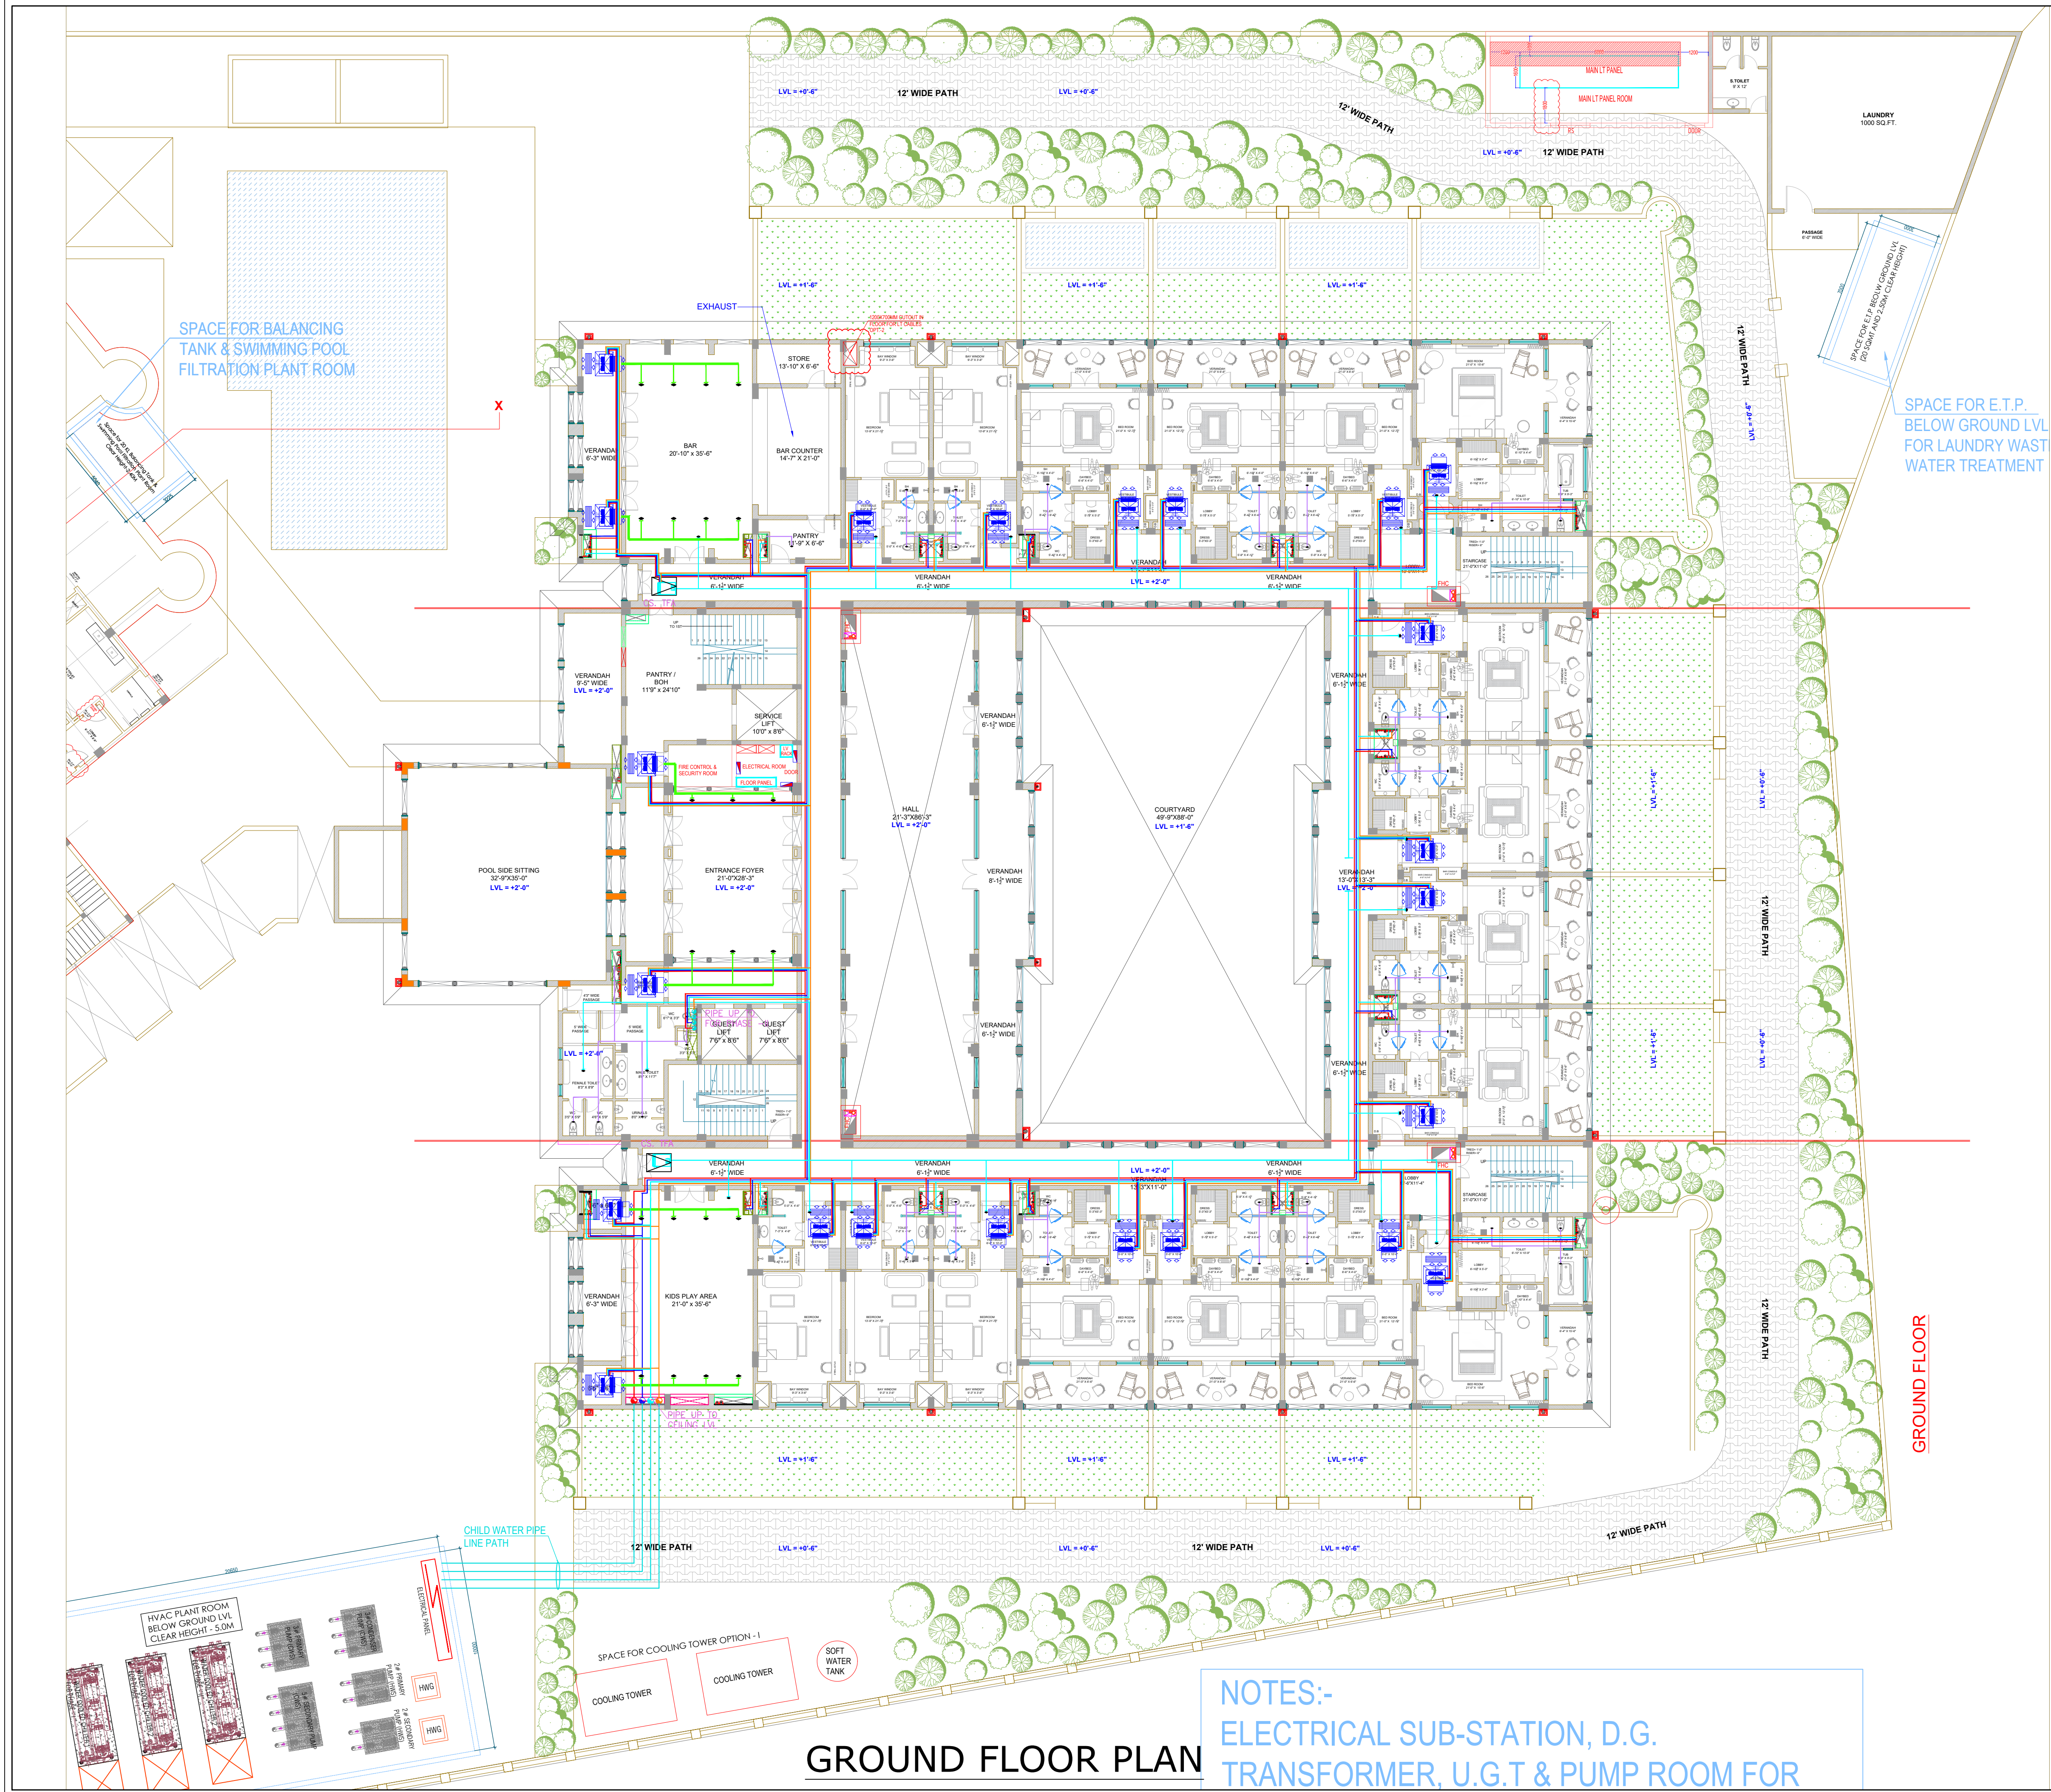

HVAC LEGEND	
—	CHILLED WATER SUPPLY PIPE
—	CHILLED WATER RETURN PIPE
—	HOT WATER SUPPLY PIPE
—	HOT WATER RETURN PIPE
—	TREATED FRESH AIR DUCT
—	TOILET EXHAUST DUCT

SCHEMATIC DRAWINGS

REVISION NO.- R0

MEPF CONSULTANT:
NEWTECH CONSULTING ENGINEERS
C-137/1, 3rd Floor, Vijay Vihar Phase - II
(Rohini Sec.-1), New Delhi – 110085. (India)

ARCHITECT:
RAVI KUMAR GUPTA
CA/83/7739
L-1, KRISHNA MARG, C- SCHEME,
JAIPUR (302001), RAJASTHAN.
PH.0141-2360825 E-Mail-ravigupta_15@yahoo.com

DRAWING TITLE:
**GROUND FLOOR PLAN
(HVAC LAYOUT)**

PROJECT:
LAXMI PALACE / HOTEL

DRAWN BY: SONU KUMAR	NORTH:	DATE: 09-01-2024
CHECKED BY: VIJAY KUMAR	DRAWING NO.: AC-01	SCALE: 1:100

NOTES:
THE COPYRIGHT AND PROPERTY OF THIS DESIGN AND DRAWING
BELONGS TO **RAVI KUMAR GUPTA**. IT MUST NOT BE COPIED OR
REPRODUCED IN ANY MANNER WITHOUT THEIR WRITTEN
CONSENT. A LEGAL ACTION AS PER LAW MAY BE INITIATED
AGAINST THE OFFENDER. 02

STRUCTURE CO. :
SANRACHANA

NOTES:-
ELECTRICAL SUB-STATION, D.G.
TRANSFORMER, U.G.T & PUMP ROOM FOR