


LEGEND - ELECTRICAL		
S.NO.	SYMBOL	DESCRIPTION OF ITEM
1		CEILING FAN
2		SWITCH BOARD
3		MASTER SWITCH
4		CEILING LIGHT
6		SWITCH SOCKET 6A.
7		SWITCH SOCKET 16A.
9		TELEPHONE
10		DISTRIBUTION BOX
11		TUBE LIGHT
12		AC POINTS
13		UPLIGHTER (FLOOR LIGHT)
14		SPRINKLER
15		SMOKE DETECTOR
16		AC
17		speakers

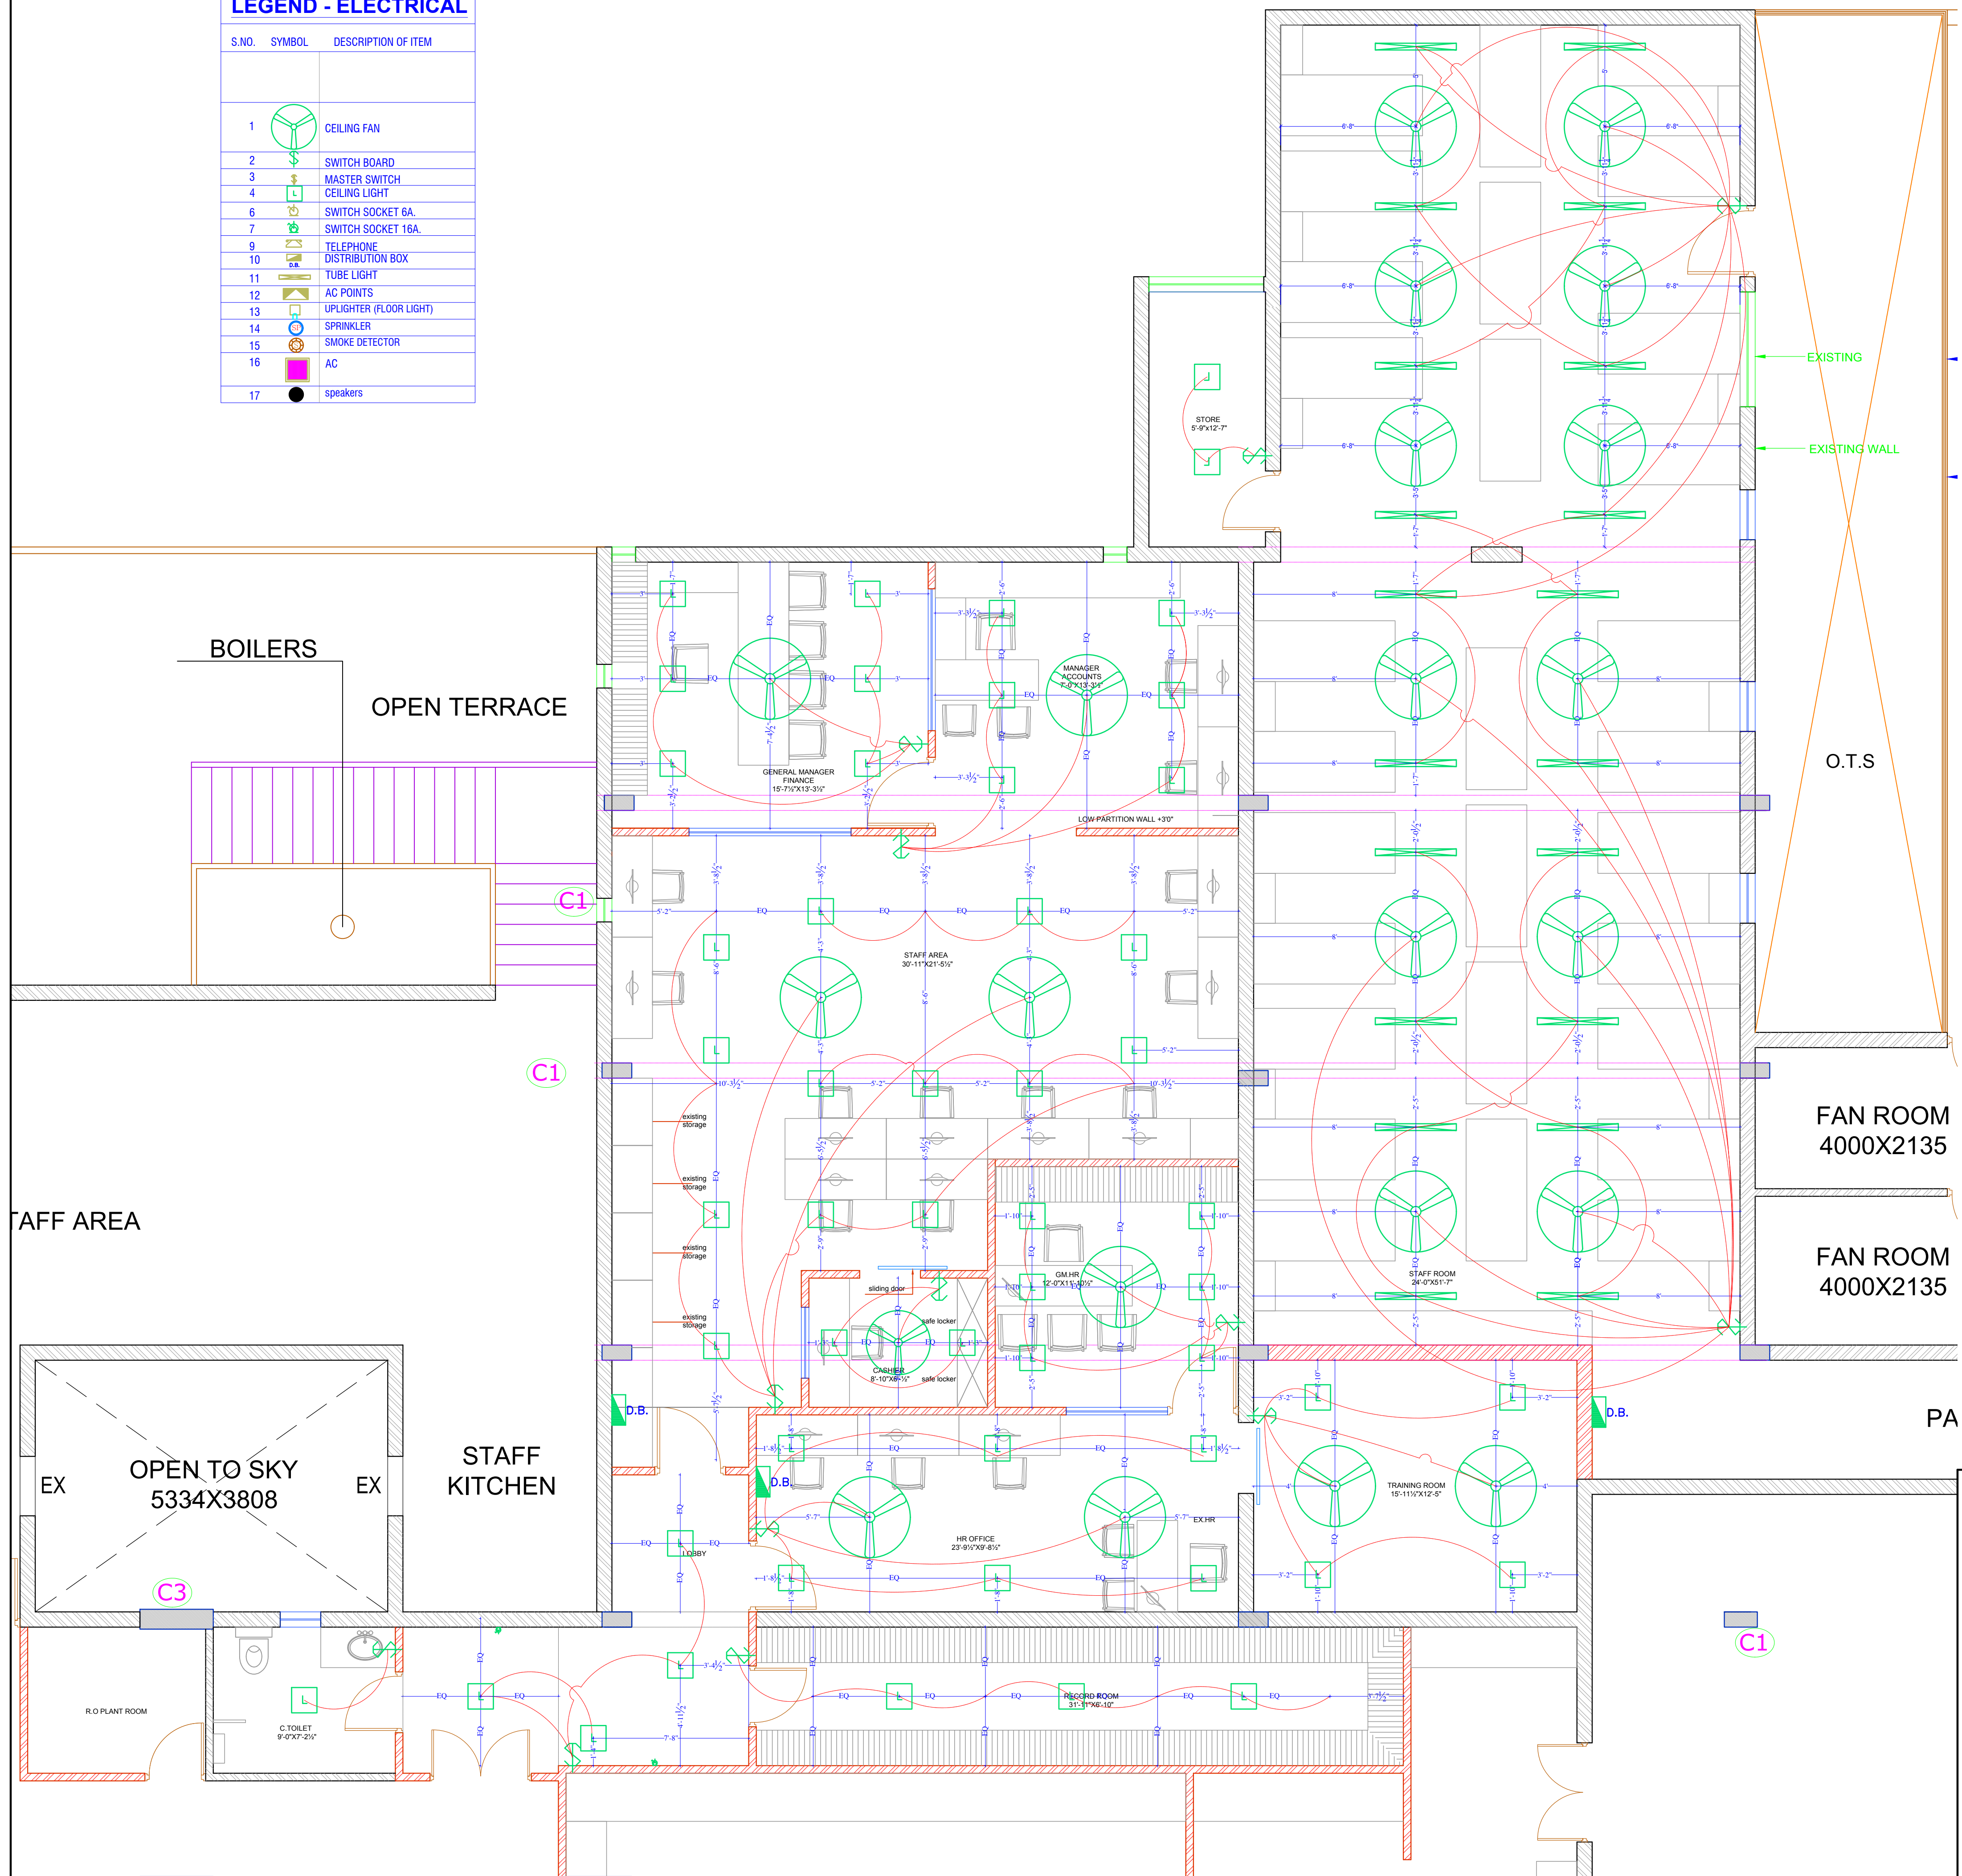

ARCHITECT:
NEERAV GUPTA
L-1, KRISHNA MARG, C-SCHEME,
JAIPUR (302001), RAJASTHAN.
PH.0141-2360825
E-Mail-architect_neeravgupta@yahoo.com

PROJECT:
CLARKS

DRAWING TITLE:
**ACCOUNTS AND HR
CEILING ELECTRICAL PLAN**

DRAWN BY:
RAHUL

SCALE:
N.T.S.

DATE:
28-09-2018

CHECKED BY:
**NEERAV
GUPTA**

SHEET NO :-
 C/AV/AC/EL/01

NOTES:
THE COPYRIGHT AND PROPERTY OF THIS DESIGN AND DRAWING
BELONGS TO **NEERAV GUPTA**. IT MUST NOT BE COPIED OR
REPRODUCED IN ANY MANNER WITHOUT THEIR WRITTEN
CONSENT. A LEGAL ACTION AS PER LAW MAY BE INITIATED
AGAINST THE OFFENDERS.