


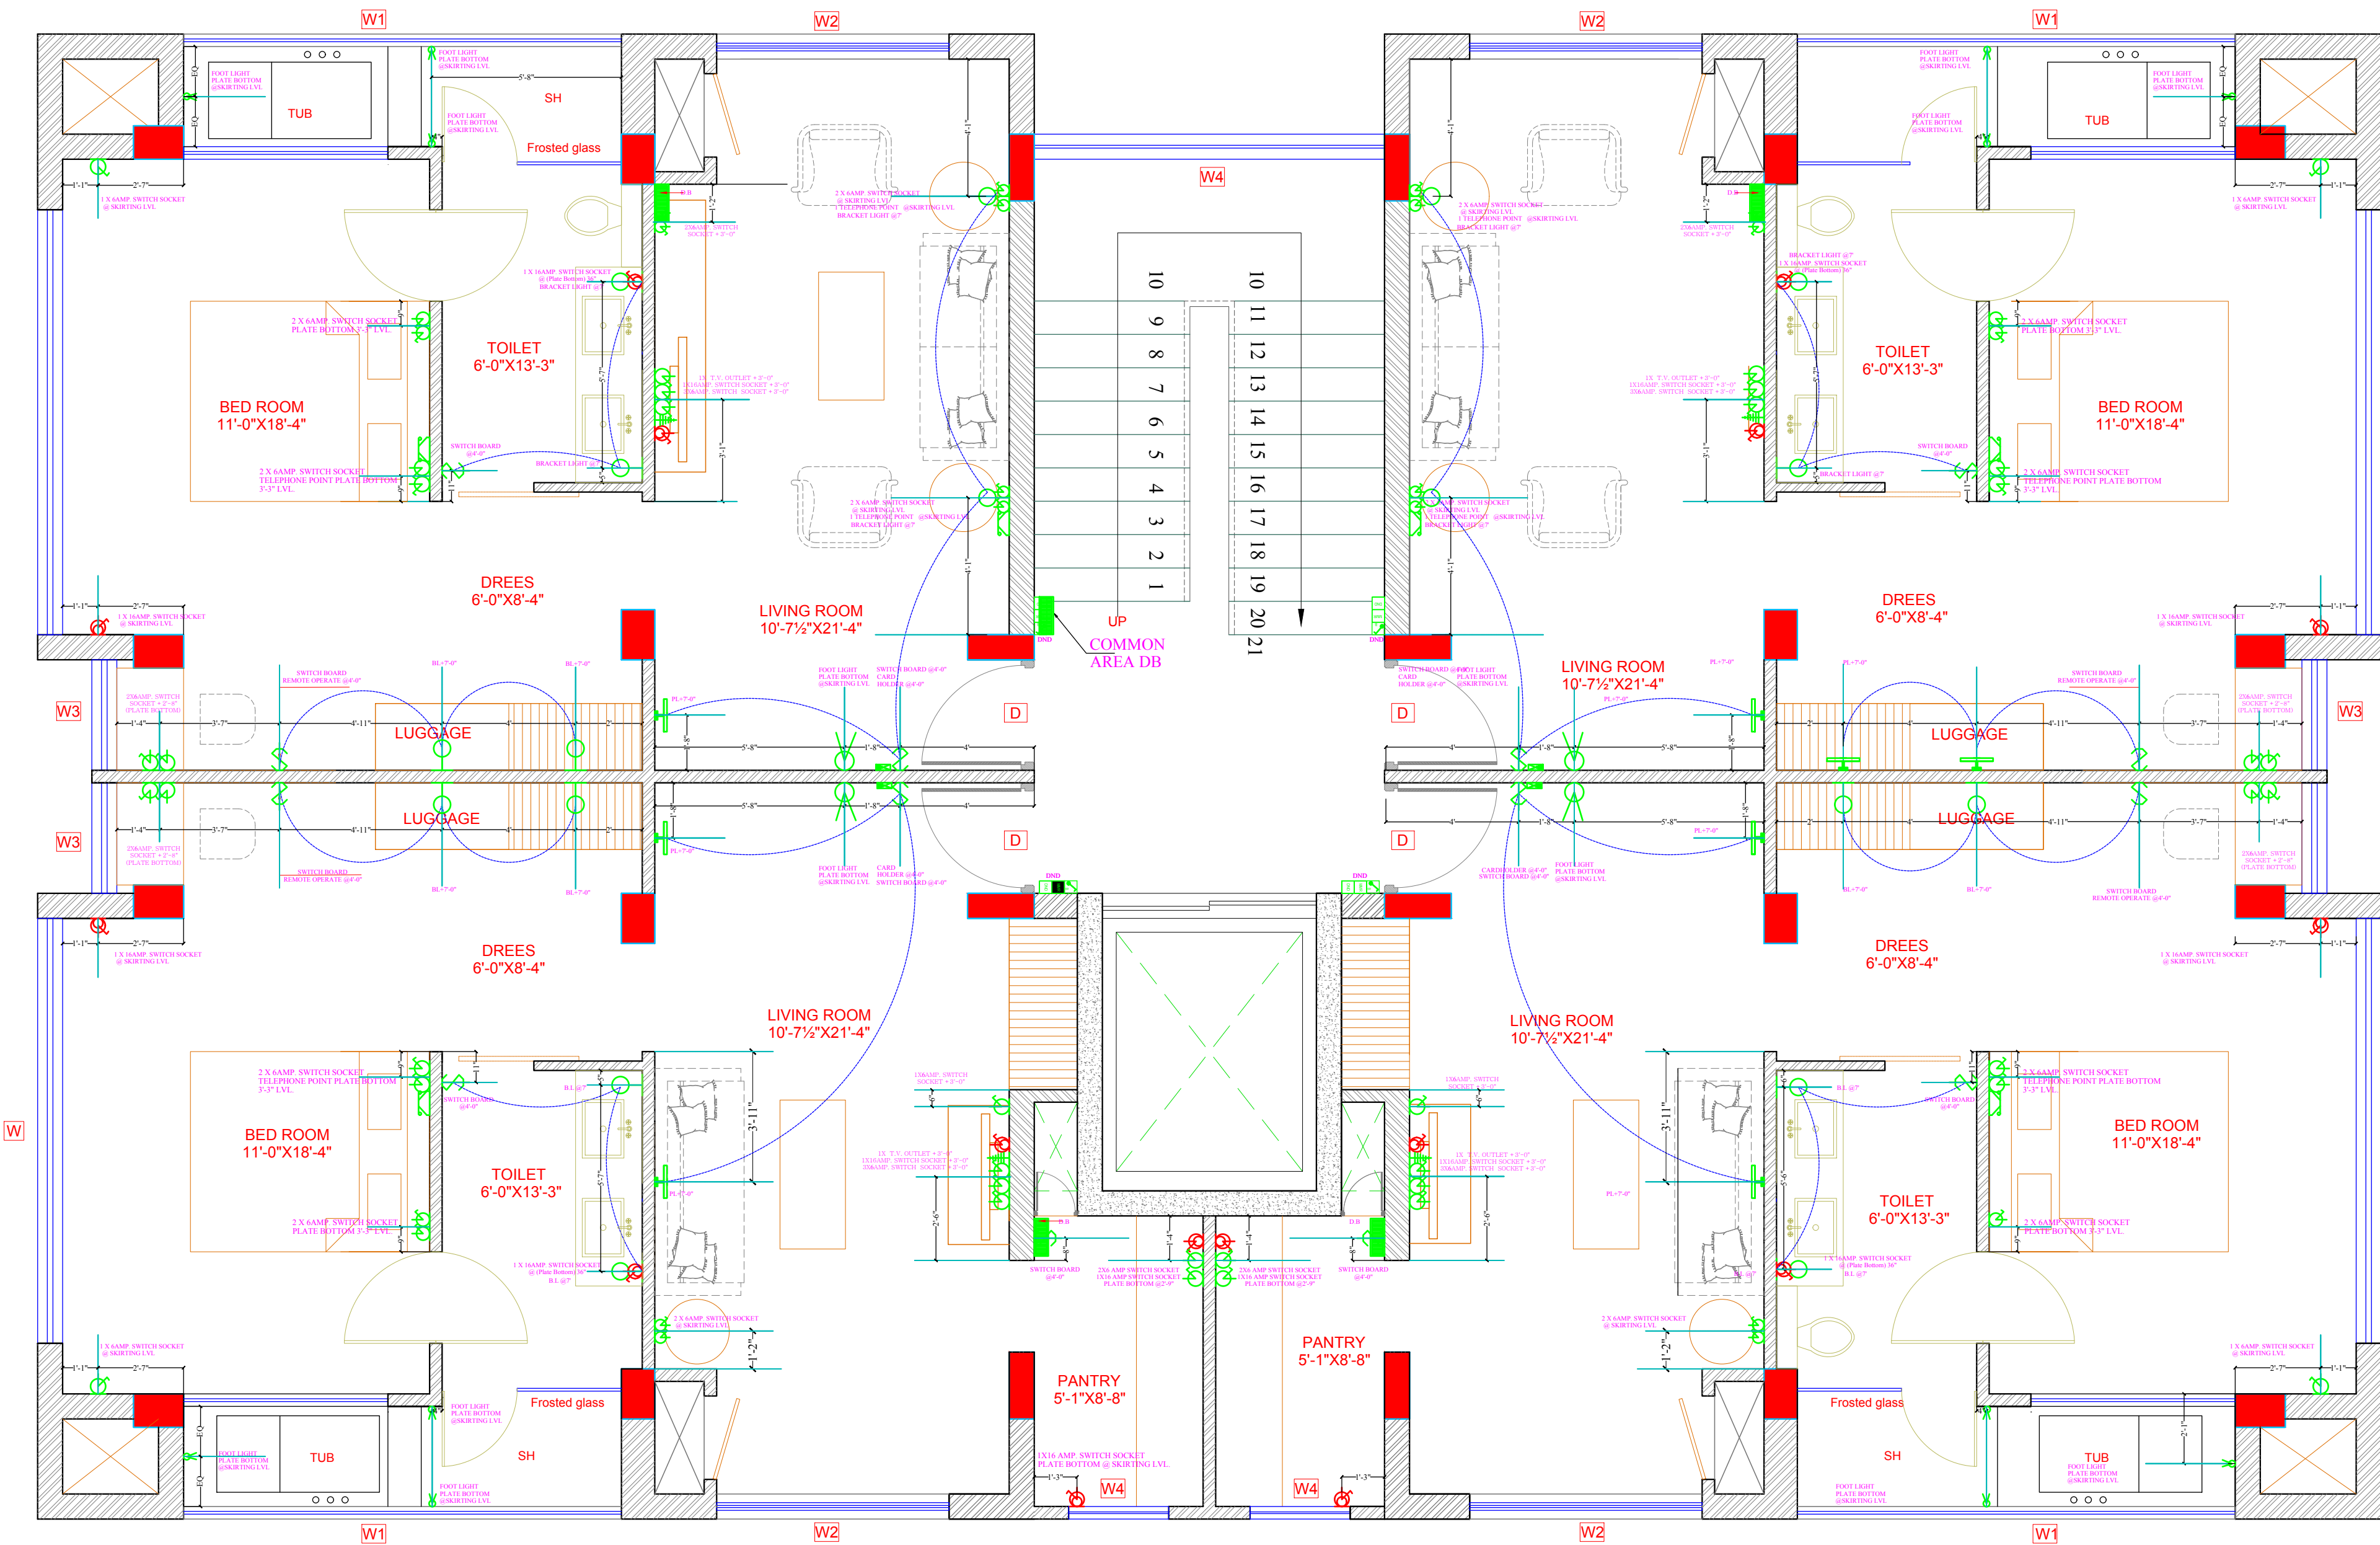

LEGEND - ELECTRICAL

S.NO.	SYMBOL	DESCRIPTION OF ITEM	HT.
1		CEILING FAN	
2		SWITCH BOARD	
3		BRACKET LIGHT	7'-0"
4		RETROFIT CFL INTEGRATED	
5		SWITCH SOCKET 6A.	
6		SWITCH SOCKET 16A.	
7		ANTENNA	
8		TELEPHONE	
9		CHANDELLIER	
10		DISTRIBUTION BOX	
11		PICTURE LIGHT	7'-0"
12		HANGING LIGHT	
13		CHANDELLIER	
14		UPLIGHTERS	
15		DOWLNLIGHTERS	
16		DONOT DISTURB (DND)	
17		CARD HOLDER	
18		AIR CONDITIONER	
19		FOOT LIGHT	

TYPICAL FLOOR WALL ELECTRICAL PLAN

ARCHITECT:
NEERAV GUPTA
CA/2009/44766
L-1, KRISHNA MARG, C- SCHEME,
JAIPUR (302001), RAJASTHAN, PH.0141-2360825
E-Mail-architect_neeravgupta@yahoo.com

PROJECT:
HOTEL CLARKS

DRAWING TITLE:
ARCHITECTURAL
(R-12)REVISED TYPICAL FLOOR
ELECTRICAL PLAN

DRAWN BY:
RAHUL

SCALE:
N.T.S

DATE:
19-02-2019

CHECKED BY:
NEERAV
GUPTA

DRAWING NO.:
 30/C/AR/06

NOTES:
THE COPYRIGHT AND PROPERTY OF THIS DESIGN AND DRAWING
BELONGS TO RAJESH KUMAR GUPTA. IT MUST NOT BE COPIED OR
REPRODUCED IN ANY MANNER WITHOUT THEIR WRITTEN
CONSENT. A LEGAL ACTION AS PER LAW MAY BE INITIATED
AGAINST THE OFFENDER.