


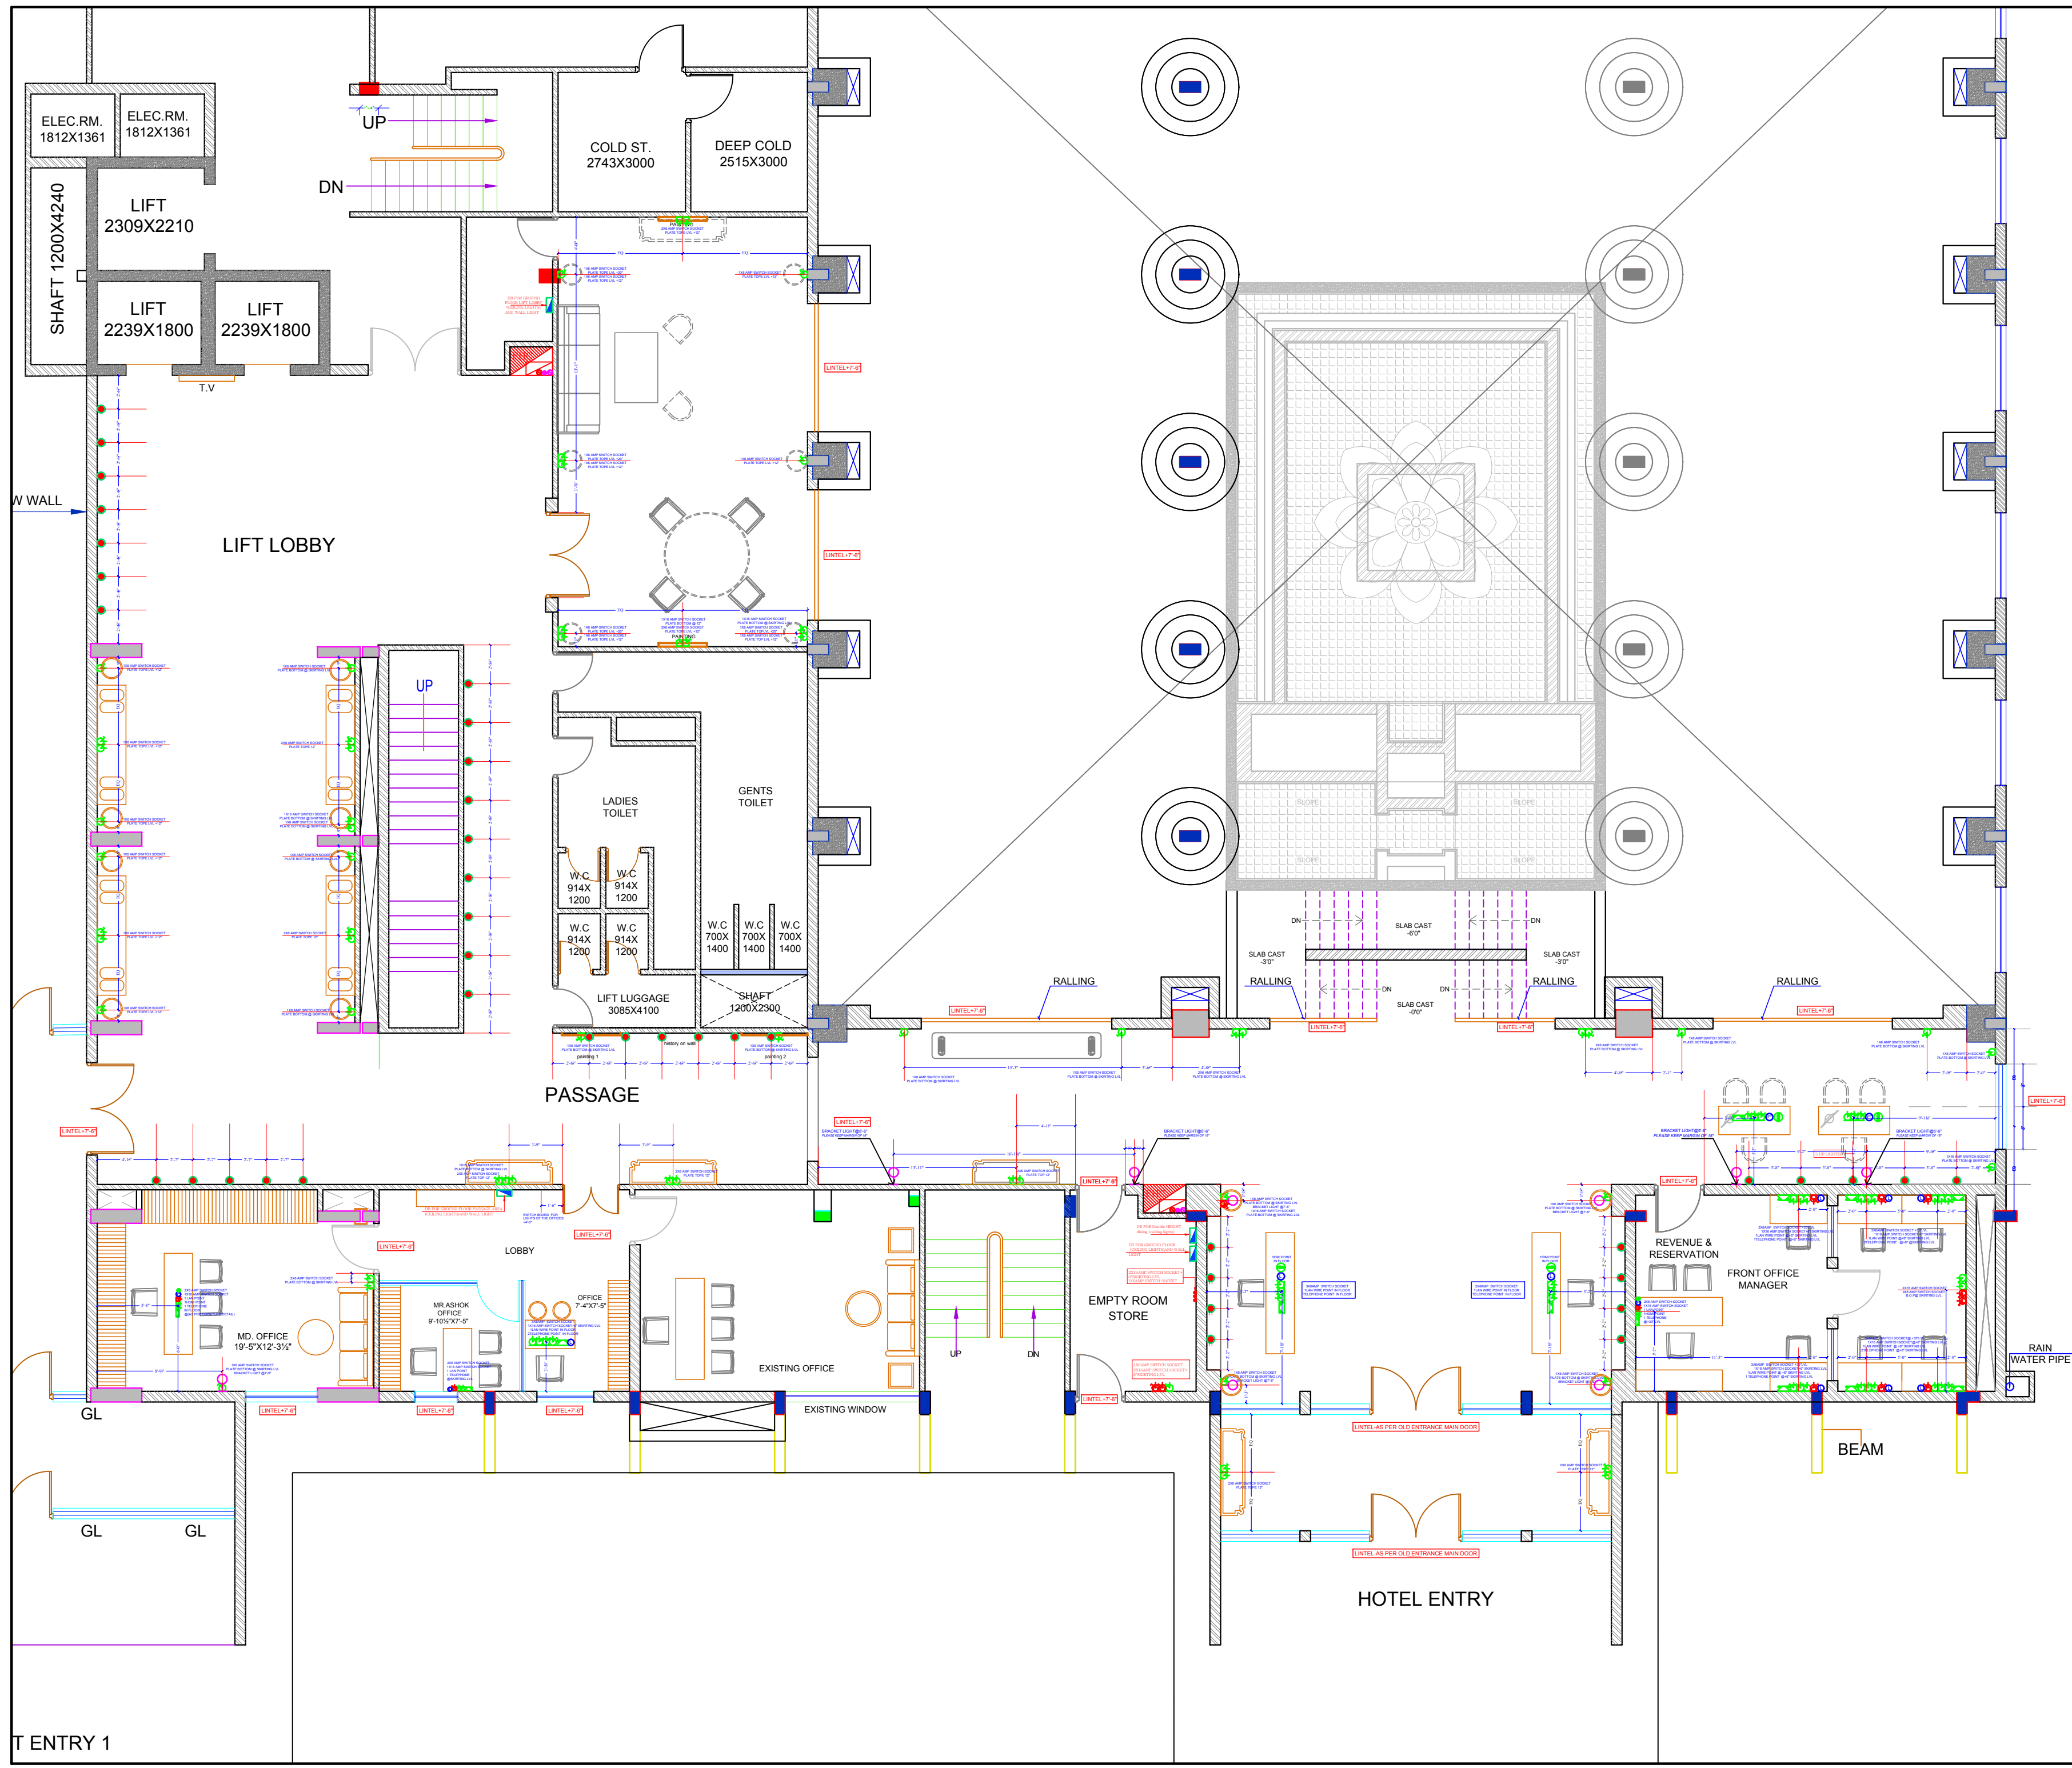

LEGEND - ELECTRICAL			
S.NO.	SYMBOL	DESCRIPTION OF ITEM	HT.
1		CEILING FAN	
2		SWITCH BOARD	
3		BRACKET LIGHT	6'-0"
4		RETROFIT CFL INTEGRATED	
5		SWITCH SOCKET 6A.	
6		SWITCH SOCKET 16A.	
7		ANTENNA	
8		TELEPHONE	
9		CHANDELLIER	
10		DISTRIBUTION BOX	
11		PICTURE LIGHT	
12		HANGING LIGHT	
13		CHANDELLIER	
14		UPLIGHTERS	
15		DOWNLIGHTERS	
16		DONOT DISTURB (DND)	
17		CARD HOLDER	
18		AIR CONDITIONER	
19		FOOT LIGHT	
20		CEILING SPEAKER	

ARCHITECT:
NEERAV GUPTA
L-1, KRISHNA MARG, C- SCHEME,
JAIPUR (302001), RAJASTHAN.
PH.0141-2360825
E-Mail-architect_neeravgupta@yahoo.com

PROJECT:
CLARKS
DRAWING TITLE:
GROUND FLOOR
WALL ELECTRICAL PLAN

DRAWN BY:	SCALE:	DATE:
RAHUL	N.T.S.	20-07-2019
CHECKED BY:	SHEET NO :-18	
NEERAV GUPTA	C/AV/AR/WR/80	

NOTES:
THE COPYRIGHT AND PROPERTY OF THIS DESIGN AND DRAWING BELONGS TO NEERAV GUPTA. IT MUST NOT BE COPIED OR REPRODUCED IN ANY MANNER WITHOUT THEIR WRITTEN CONSENT. A LEGAL ACTION AS PER LAW MAY BE INITIATED AGAINST THE OFFENDER.