


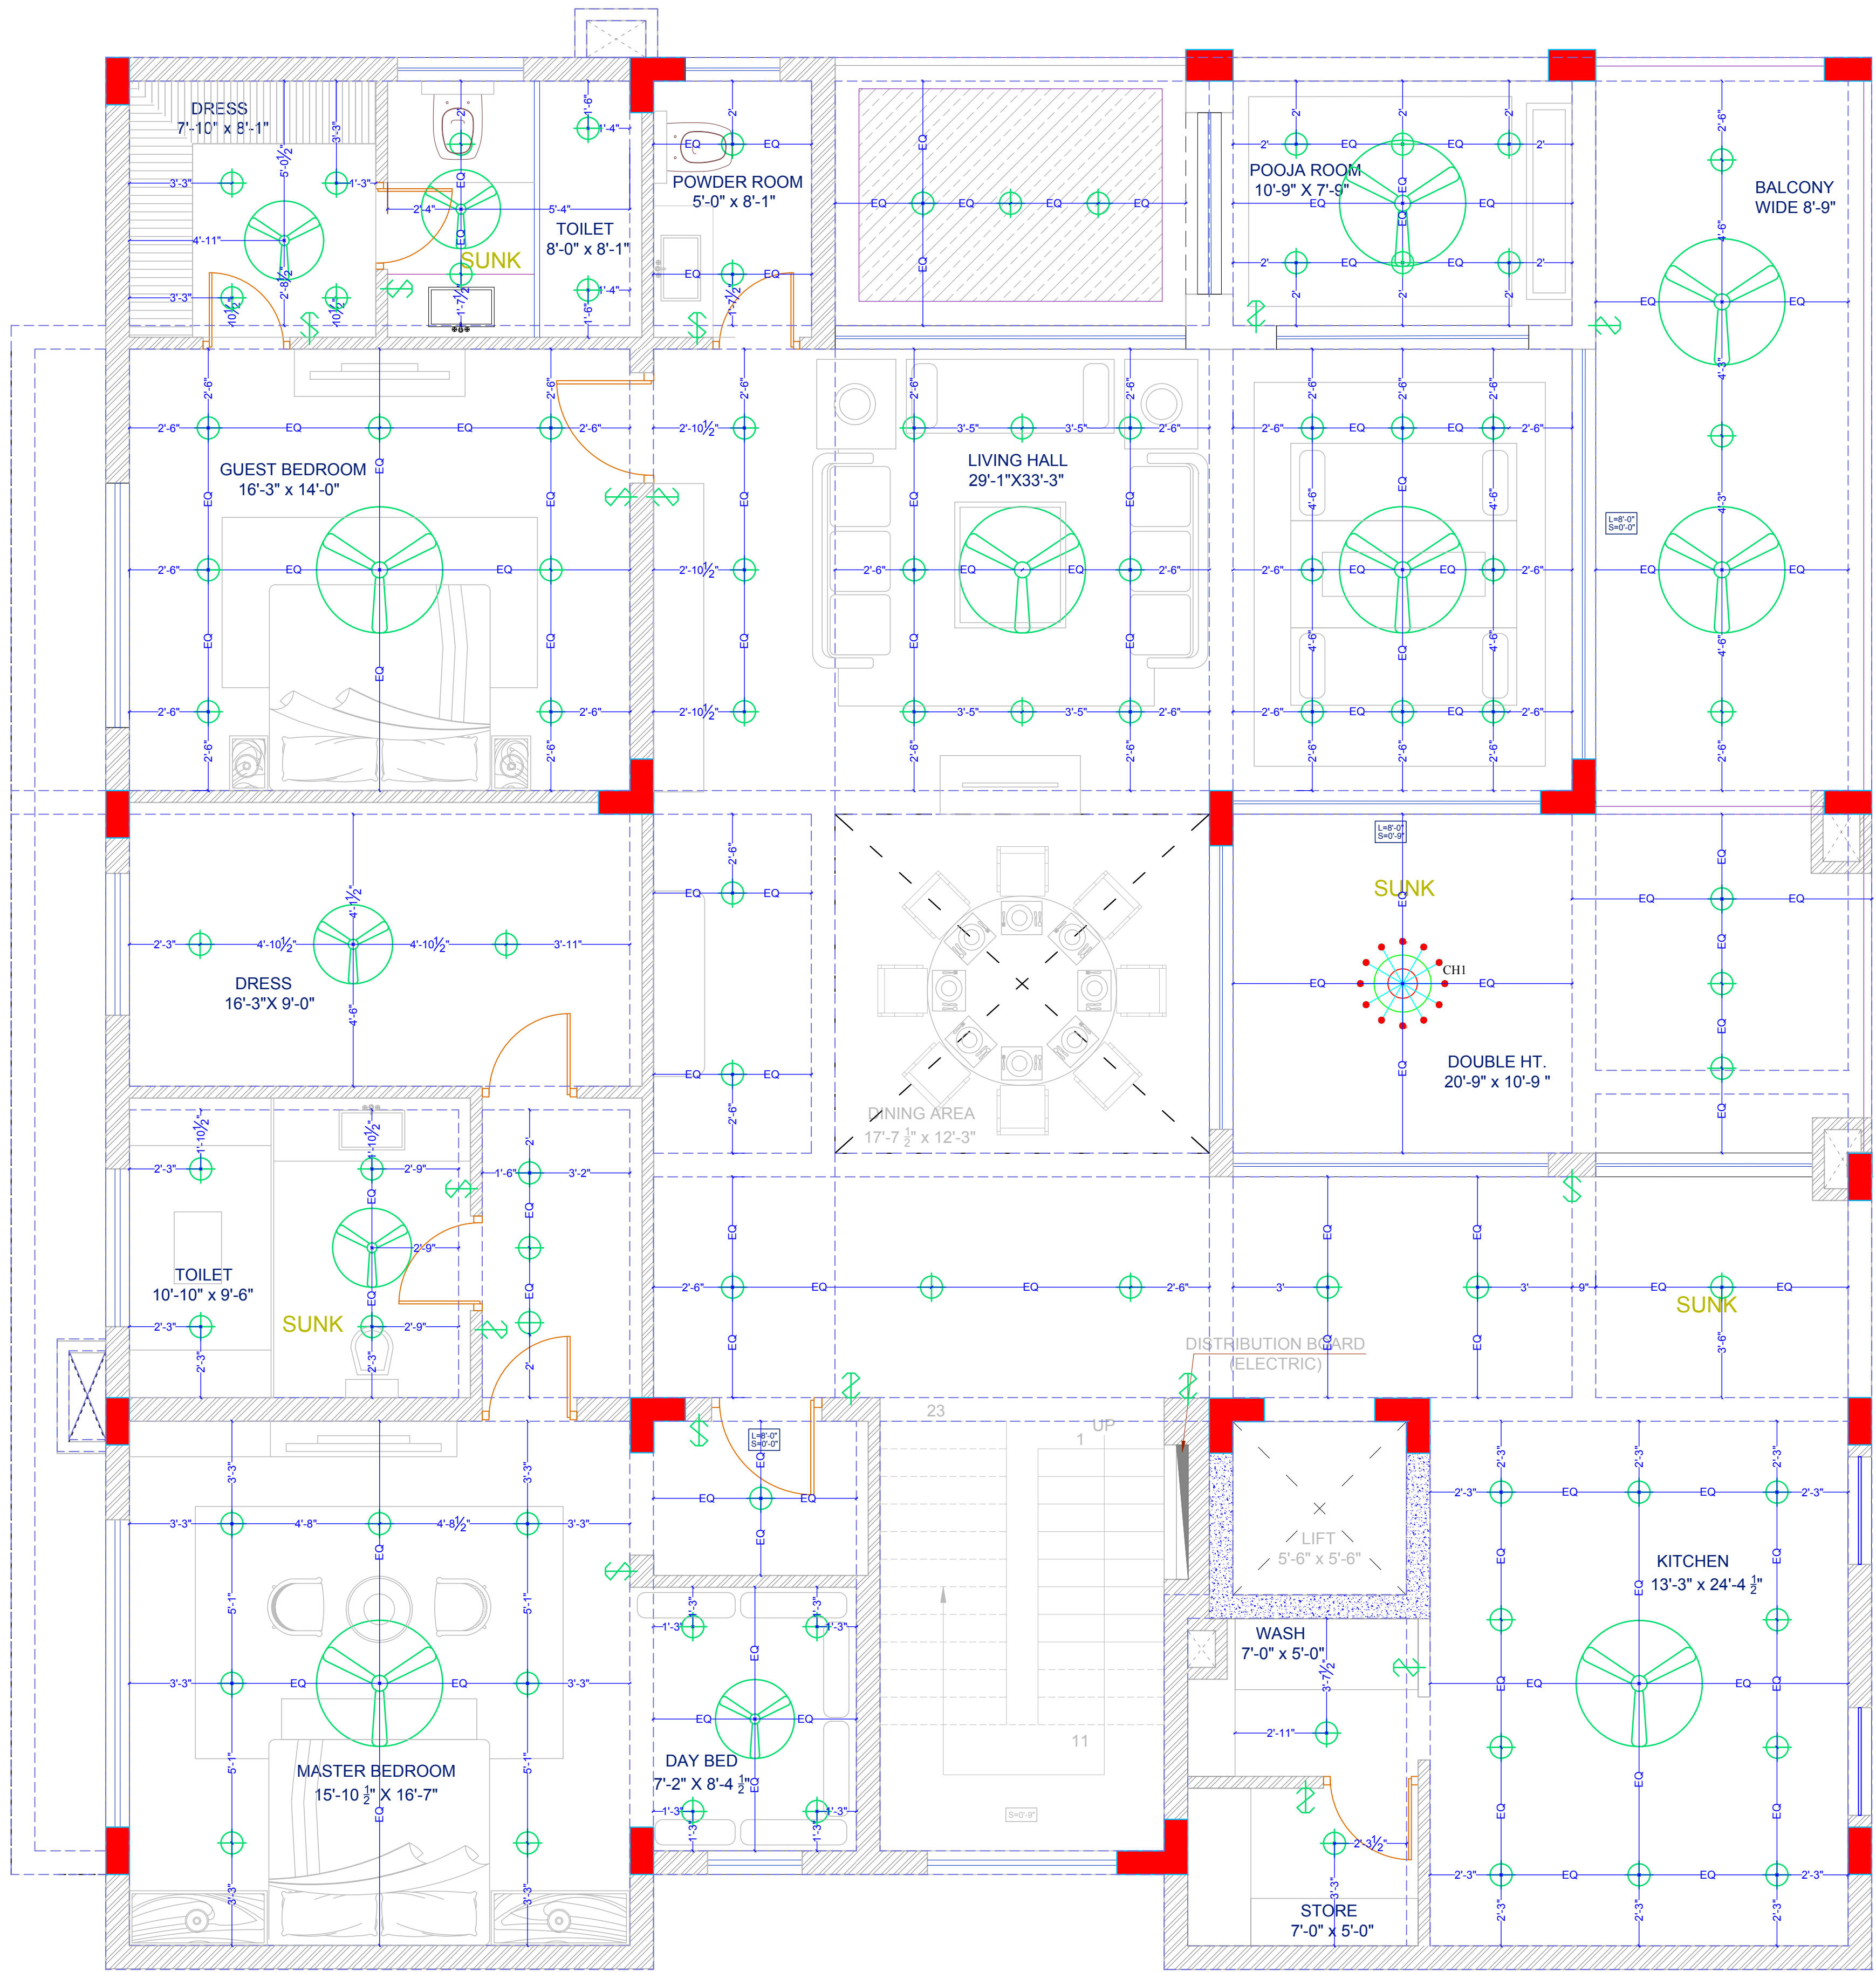

ALL DIMINTIONS ARE FROM
FINISH FLOOR LEVEL

LEGEND - ELECTRICAL		
S.NO.	SYMBOL	DESCRIPTION OF ITEM
1		CEILING FAN
2		SWITCH BOARD
3		MASTER SWITCH
4		RETROFIT CFL INTEGRATED
5		BRACKET LIGHT
6		SWITCH SOCKET 6A.
7		SWITCH SOCKET 16A.
8		ANTENNA
9		TELEPHONE
10		CHANDELLIER
11		WALL FAN
12		EXHAUST FAN
13		METALLIC SW. SOC 20A. IN MCB BOX
14		DISTRIBUTION BOX
15		TUBE LIGHT
16		CALL BELL
17		AC POINTS
18		UPLIGHTER
19		WARDROBE LIGHT

NOTE: ALL BRACKET LIGHTS ARE AT 7'-0" LVL.

15-10-2018 REVISED FIRST FLOOR ELECTRICAL PLAN

ARCHITECT:
NEERAV GUPTA
CA/2009/44766
L-1, KRISHNA MARG, C- SCHEME,
JAIPUR (302001), RAJASTHAN.PH.0141-2380825
E-Mail-architect_neeravgupta@yahoo.com

PROJECT:
ABHISHEK'S RESIDENCE

DRAWING TITLE:
**REVISED FIRST FLOOR
ELECTRICAL PLAN**

DRAWN BY:	SCALE:	DATE:
RAHUL	N.T.S	15-10-18

CHECKED BY:	DRAWING NO.:
NEERAV GUPTA	AB/EL/A3

NOTES:
THE COPYRIGHT AND PROPERTY OF THIS DESIGN AND DRAWING
BELONGS TO **RAV KUMAR GUPTA**. IT MUST NOT BE COPIED OR
REPRODUCED IN ANY MANNER WITHOUT THEIR WRITTEN
CONSENT. A LEGAL ACTION AS PER LAW MAY BE INITIATED
AGAINST THE OFFENDER.