


LEGEND - ELECTRICAL

S.NO.	SYMBOL	DESCRIPTION OF ITEM
1		CEILING FAN
2		SWITCH BOARD
3		MASTER SWITCH
4		CEILING LIGHT
6		SWITCH SOCKET 6A
7		SWITCH SOCKET 16A
9		TELEPHONE
10		DISTRIBUTION BOX
11		TUBE LIGHT
12		AC POINTS
13		UPLIGHTER (FLOOR LIGHT)
14		SPRINKLER
15		SMOKE DETECTOR
16		AC
17		speakers

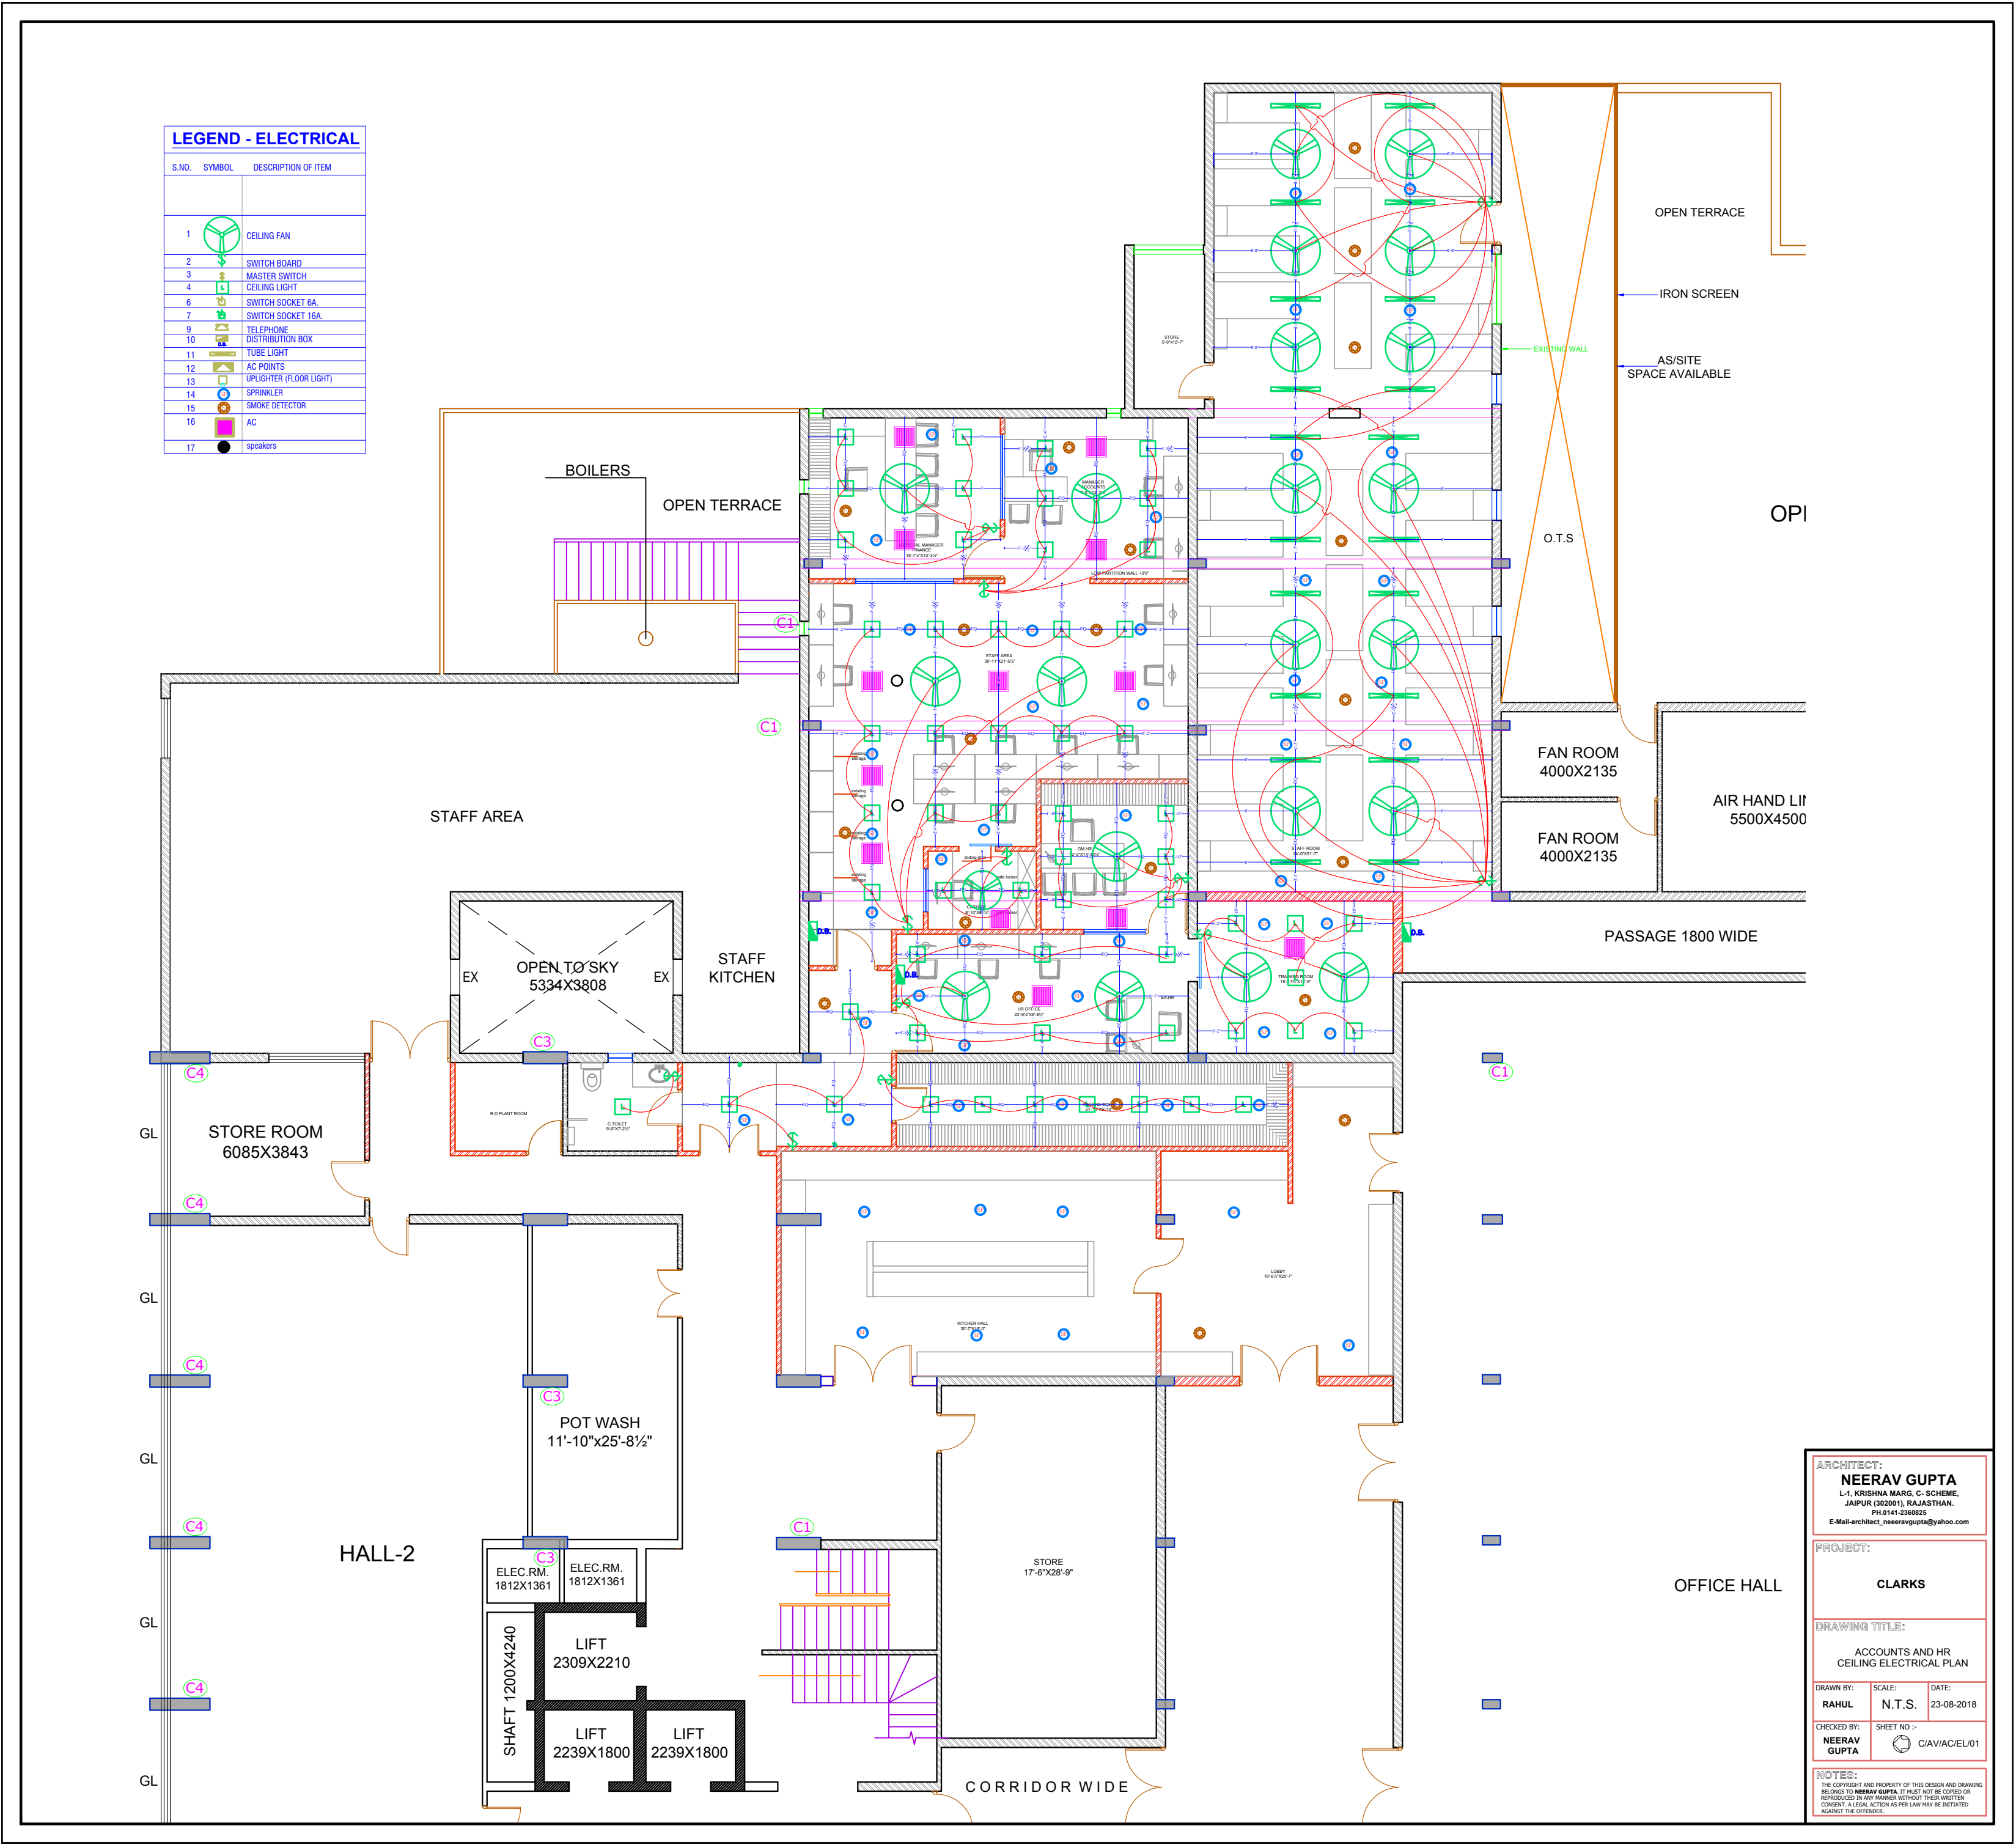

ARCHITECT:
NEERAV GUPTA
L-1, KRISHNA MARG, C-SCHEME,
JAIPUR (302001), RAJASTHAN,
PIN-302002
E-Mail-architect_neeravgupta@yahoo.com

PROJECT:
CLARKS

DRAWING TITLE:
ACCOUNTS AND HR
CEILING ELECTRICAL PLAN

DRAWN BY:
RAHUL

SCALE:
N.T.S.

DATE:
23-08-2018

CHECKED BY:
NEERAV GUPTA

SHEET NO :-
C/AVI/AC/EL/01

NOTES:
THE COPYRIGHT AND PROPERTY OF THIS DESIGN AND DRAWING
BELONGS TO NEERAV GUPTA. IT MUST NOT BE COPIED OR
REPRODUCED IN ANY MANNER WITHOUT THEIR WRITTEN
CONSENT. A LEGAL ACTION WILL BE INSTANTLY
AGAINST THE OFFENDER.