


ADVANCE COPY

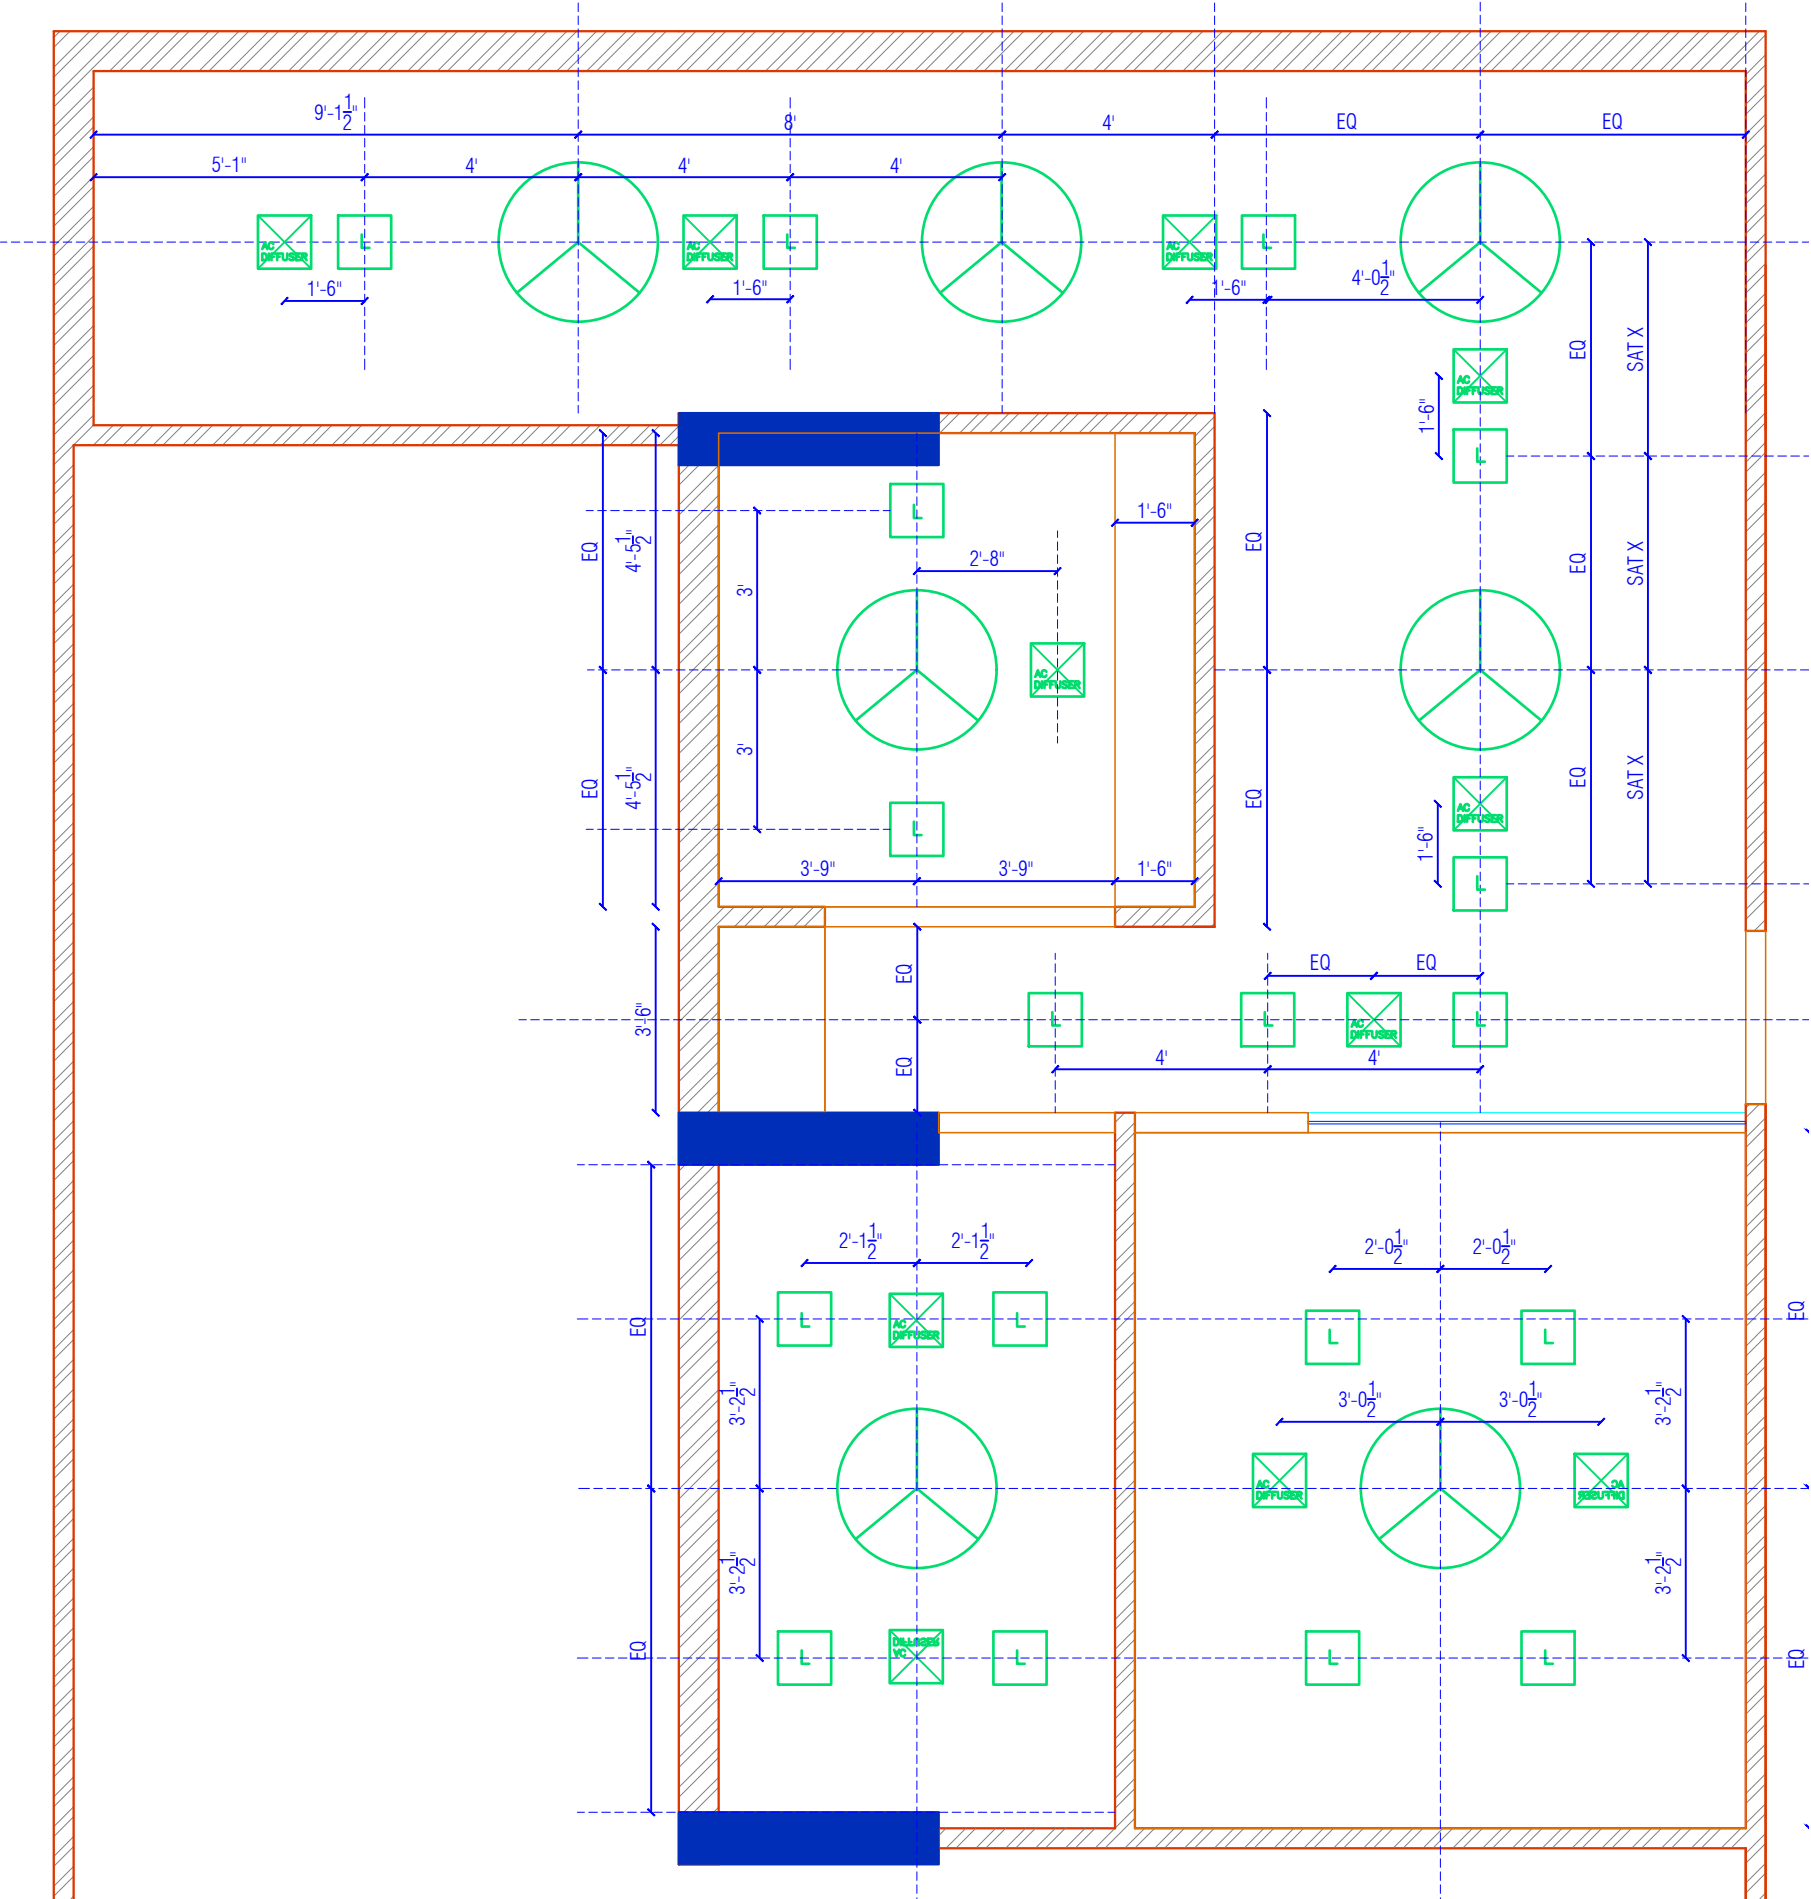

ARCHITECT: NEERAV GUPTA L-1, KRISHNA MARG, C-Scheme, JAIPUR-302001, RAJASTHAN. PH: 0141-2380825 E-Mail: architect_neeravgupta@yahoo.com		
PROJECT: CLARKS		
DRAWING TITLE: ELECTRICAL PLAN		
DRAWN BY: RAHUL	SCALE: N.T.S.	DATE: 02-04-2017
CHECKED BY: NEERAV GUPTA	NORTH: ACC 4	
NOTES: THE COPYRIGHT AND PROPERTY OF THIS DESIGN AND DRAWING BELONGS TO NEERAV GUPTA. IT MUST NOT BE REPRODUCED OR TRANSMITTED IN ANY FORM OR BY ANY MEANS, WITHOUT THE WRITTEN PERMISSION OF NEERAV GUPTA. A LEGAL ACTION AS PER LAW MAY BE INITIATED AGAINST THE OFFENDER.		