




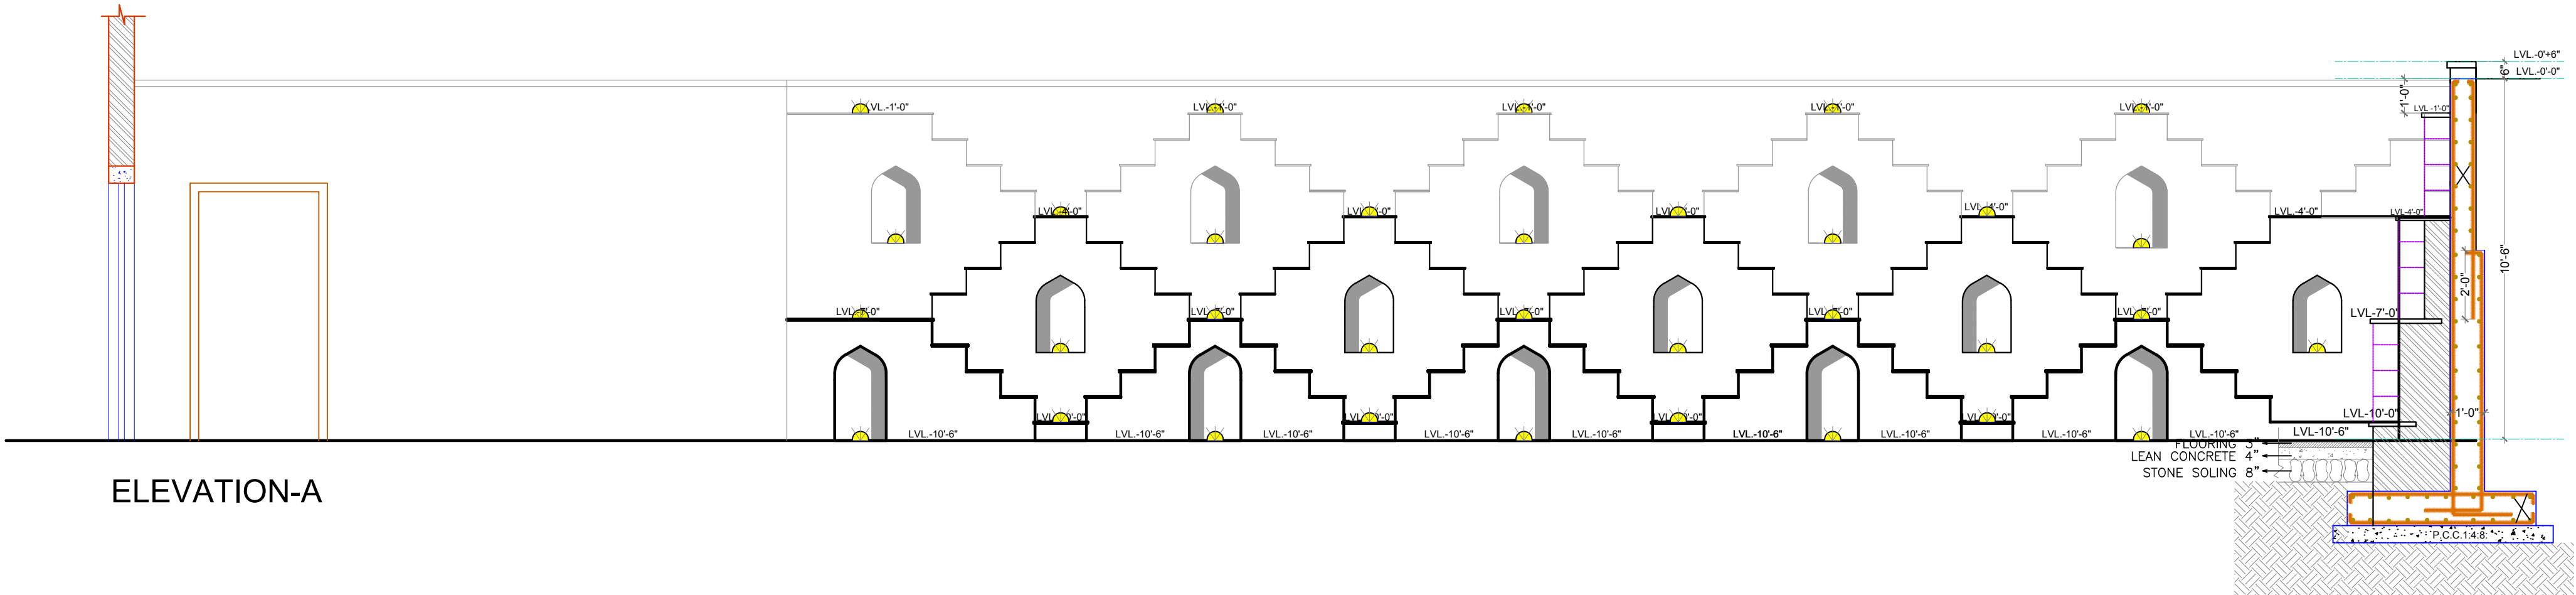

ELEVATION-A

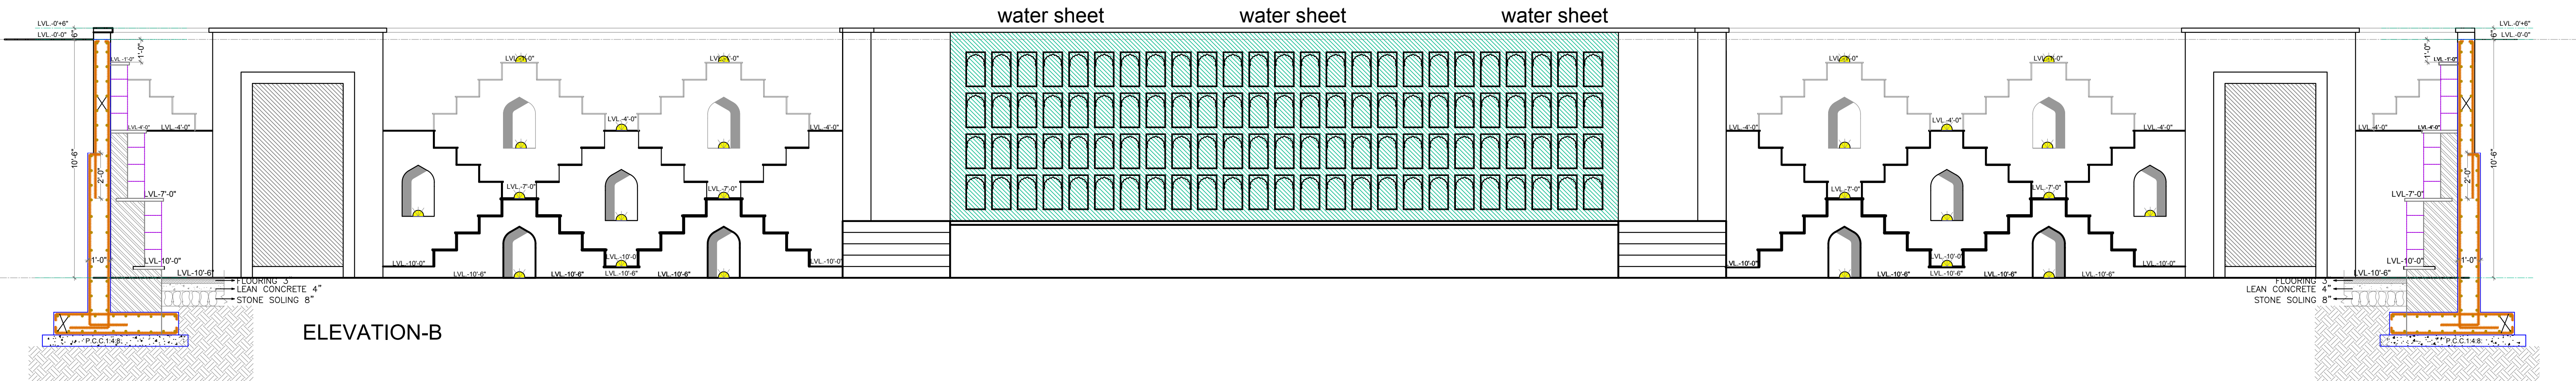

ELEVATION-B

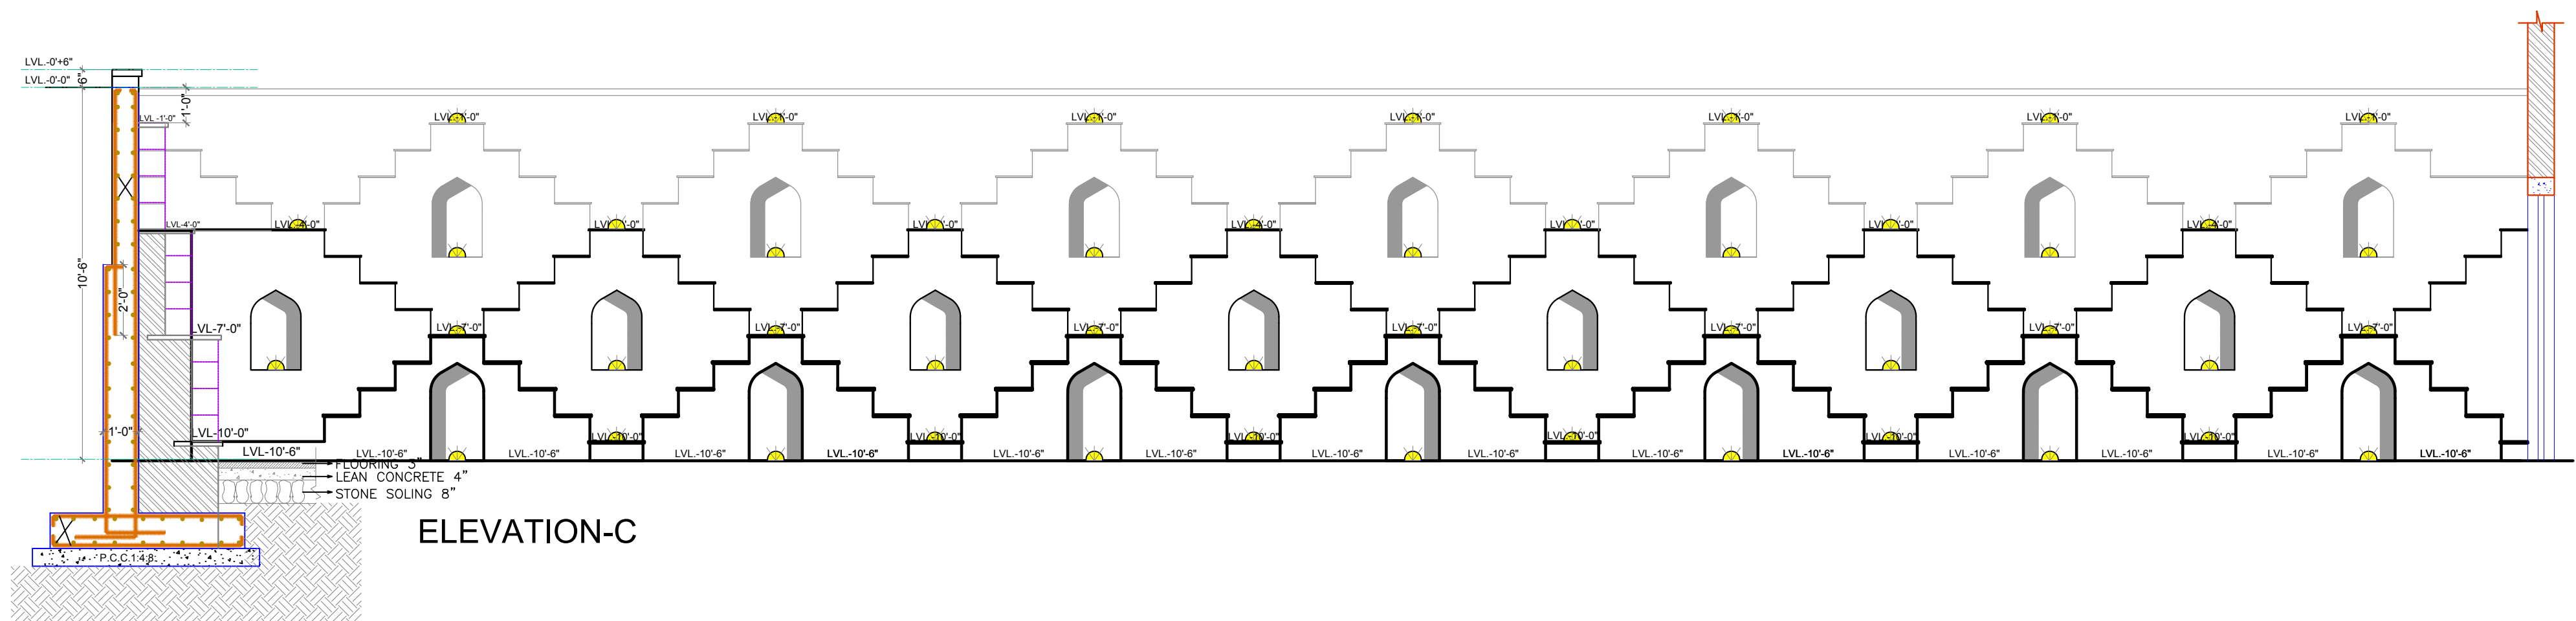

ELEVATION-C

ARCHITECT:
NEERAV GUPTA
L-1, KRISHNA MARG, C-SCHEME,
JAIPUR (302001), RAJASTHAN,
PH:0141-2388325
E-Mail:architect_neeravgupta@yahoo.com

PROJECT:
CLARKS

DRAWING TITLE:
**BAWADI
WALL ELECTRICAL PLAN**

DRAWN BY: **RAHUL** SCALE: **N.T.S.** DATE: **21-02-2019**

CHECKED BY: **NEERAV GUPTA** NORTH: SHEET: **04**

NOTES:
THE COPYRIGHT AND PROPERTY OF THIS DESIGN AND DRAWING
BELONGS TO **NEERAV GUPTA**. IT MUST NOT BE COPIED OR
REPRODUCED IN ANY FORM OR BY ANY MEANS WITHOUT THE WRITTEN
CONSENT. A LEGAL ACTION AS FOR LAW MAY BE INITIATED
AGAINST THE OFFENDER.