


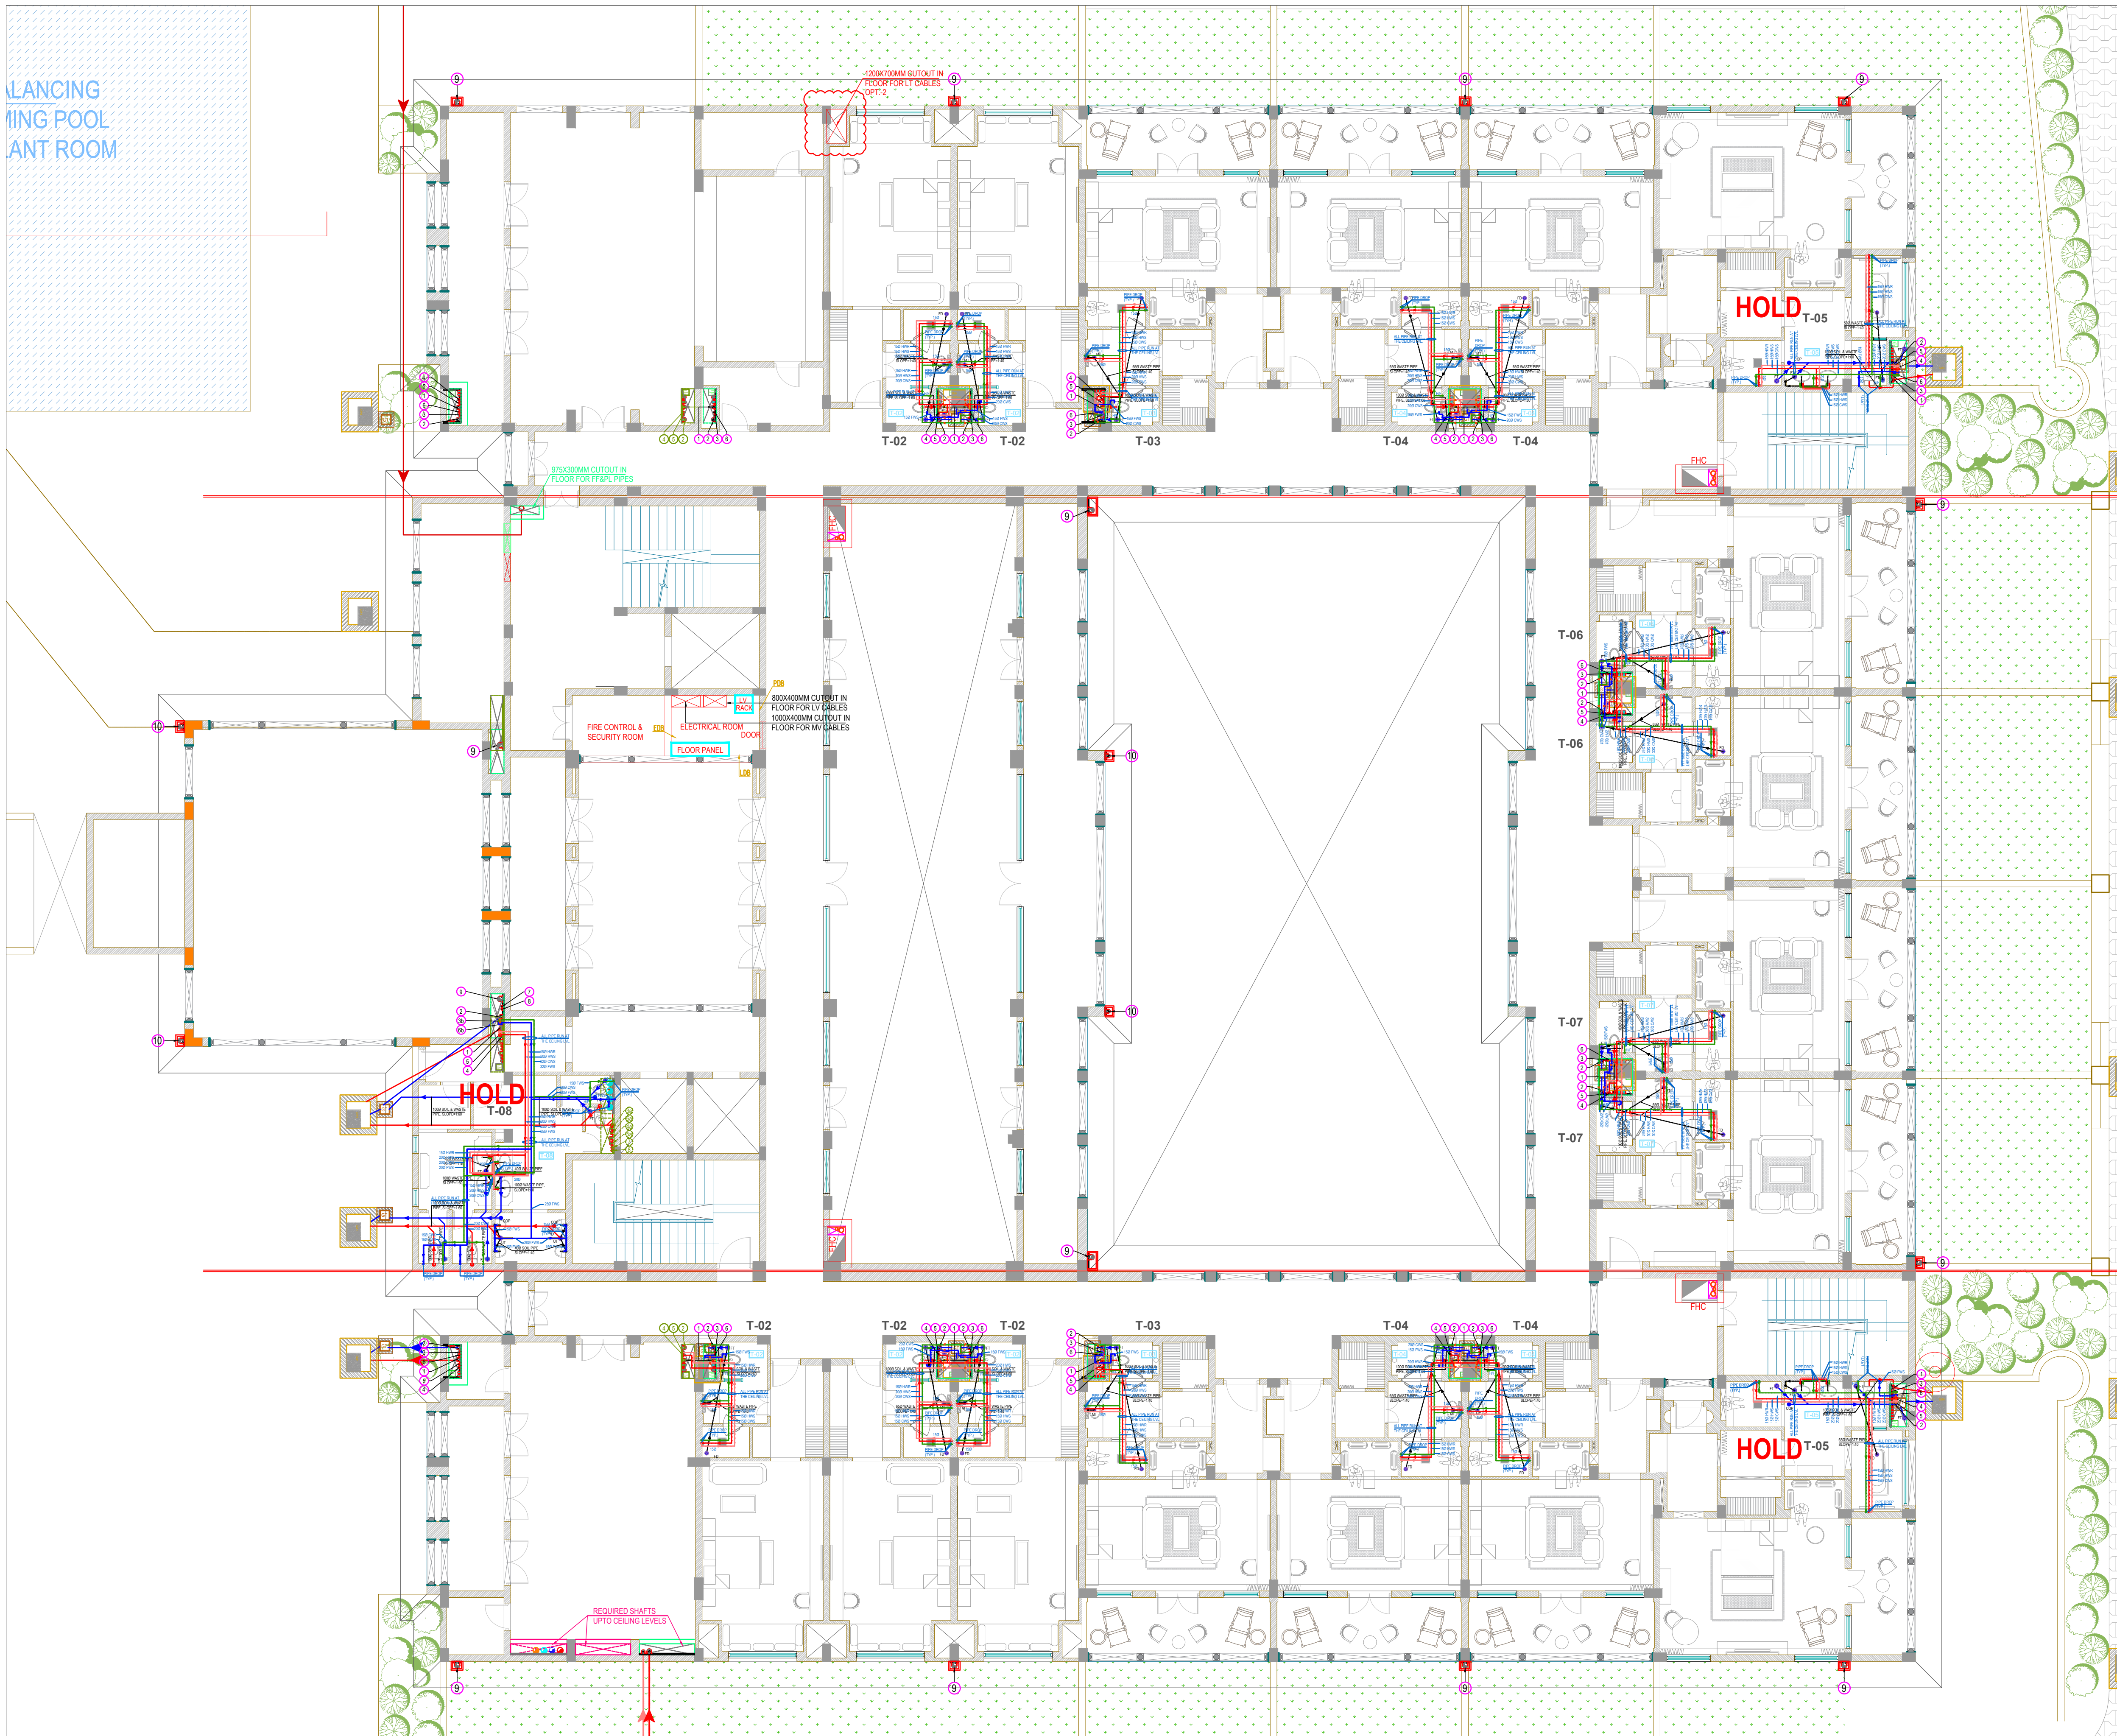

| PLUMBING LEGEND |                                                                                            |
|-----------------|--------------------------------------------------------------------------------------------|
| ①               | 1000 SOIL VERTICAL & VENT PIPE                                                             |
| ②               | 1000 WASTE VERTICAL & VENT PIPE                                                            |
| ③               | COLD WATER SUPPLY PIPE FROM W.T.P. PLANT ROOM (HYDRO-PNEUMATIC SYSTEM) FOR GR. & 1ST FLOOR |
| ③a              | COLD WATER SUPPLY PIPE FROM W.T.P. PLANT ROOM (HYDRO-PNEUMATIC SYSTEM) FOR 2ND & 3RD FLOOR |
| ③b              | COLD WATER SUPPLY PIPE TO PUBLIC TOILETS FROM O.H. TANK (BY GRAVITY)                       |
| ④               | HOT WATER SUPPLY PIPE FROM CENTRALISED HOT WATER SYSTEM FOR GR. & 1ST FLOOR                |
| ④a              | HOT WATER SUPPLY PIPE FROM CENTRALISED HOT WATER SYSTEM FOR 2ND & 3RD FLOOR                |
| ⑤               | HOT WATER RETURN PIPE TO CENTRALISED HOT WATER SYSTEM FOR GR. & 1ST FLOOR                  |
| ⑤a              | HOT WATER RETURN PIPE TO CENTRALISED HOT WATER SYSTEM FOR 2ND & 3RD FLOOR                  |
| ⑥               | FLUSHING WATER SUPPLY PIPE FROM O.H. TANK FOR GR. & 1ST FLOOR                              |
| ⑥a              | FLUSHING WATER SUPPLY PIPE FROM O.H. TANK FOR 2ND & 3RD FLOOR                              |
| ⑥b              | FLUSHING WATER SUPPLY PIPE TO PUBLIC TOILETS FROM O.H. TANK (BY GRAVITY)                   |
| ⑦               | COLD RISER PIPE FOR O.H. TANK FILLING                                                      |
| ⑧               | FLUSHING RISER PIPE FOR O.H. TANK FILLING                                                  |
| ⑨               | 1500 RAIN WATER VERTICAL PIPE                                                              |
| ⑩               | 1000 RAIN WATER VERTICAL PIPE                                                              |
| →               | SOIL PIPE (RUN IN SUNKEN / CEILING)                                                        |
| →               | WASTE PIPE (RUN IN SUNKEN / CEILING)                                                       |
| FT              | FLOOR TRAP 100X100MM ('P' TRAP) WITH S.S GRATING                                           |
| FD              | FLOOR DRAIN (100X50MM) WITH S.S GRATING                                                    |
| MT              | MULTI TRAP (75X50MM) WITH S.S GRATING                                                      |
| WB TO FT        | 320 WASTE PIPE                                                                             |
| FD TO FT        | 500 / 650 WASTE PIPE                                                                       |
| FT TO MAIN PIPE | 1000 WASTE PIPE                                                                            |
| UT TO MAIN PIPE | 1000 SOIL PIPE                                                                             |
| WC TO MAIN PIPE | 1000 SOIL PIPE                                                                             |

G.F.C (ADVANCE COPY)

REVISION NO.- R0

MEPF CONSULTANT:  
NEWTECH CONSULTING ENGINEERS  
C-137/1, 3rd Floor, Vijay Vihar Phase - II  
(Rohini Sec.-1), New Delhi - 110085, (India)

ARCHITECT:  
**RAVI KUMAR GUPTA**  
CA/83/7739  
L-1, KRISHNA MARG, C- SCHEME,  
JAIPUR (302001), RAJASTHAN.  
PH.0141-2360825 E-Mail-ravigupta\_15@yahoo.com

DRAWING TITLE:  
**TOILET DETAILS FOR GROUND  
FLOOR (DRAINAGE & WATER  
SUPPLY LAYOUT)**

PROJECT:  
**LAXMI PALACE AT JAIPUR**

|                   |        |                   |
|-------------------|--------|-------------------|
| DRAWN BY:         | NORTH: | DATE:             |
| <b>SONU KUMAR</b> |        | <b>19-02-2024</b> |

|                    |                    |        |
|--------------------|--------------------|--------|
| CHECKED BY:        | DRAWING NO.:       | SCALE: |
| <b>VIJAY KUMAR</b> | <b>PL-TD-GF-01</b> | 1:50   |

NOTES:  
THE COPYRIGHT AND PROPERTY OF THIS DESIGN AND DRAWING  
BELONGS TO **RAVI KUMAR GUPTA**. IT MUST NOT BE COPIED OR  
REPRODUCED IN ANY MANNER WITHOUT THEIR WRITTEN  
CONSENT. A LEGAL ACTION AS PER LAW MAY BE INITIATED  
AGAINST THE OFFENDER. 02

STRUCTURE CO. :  
**SANRACHANA**