


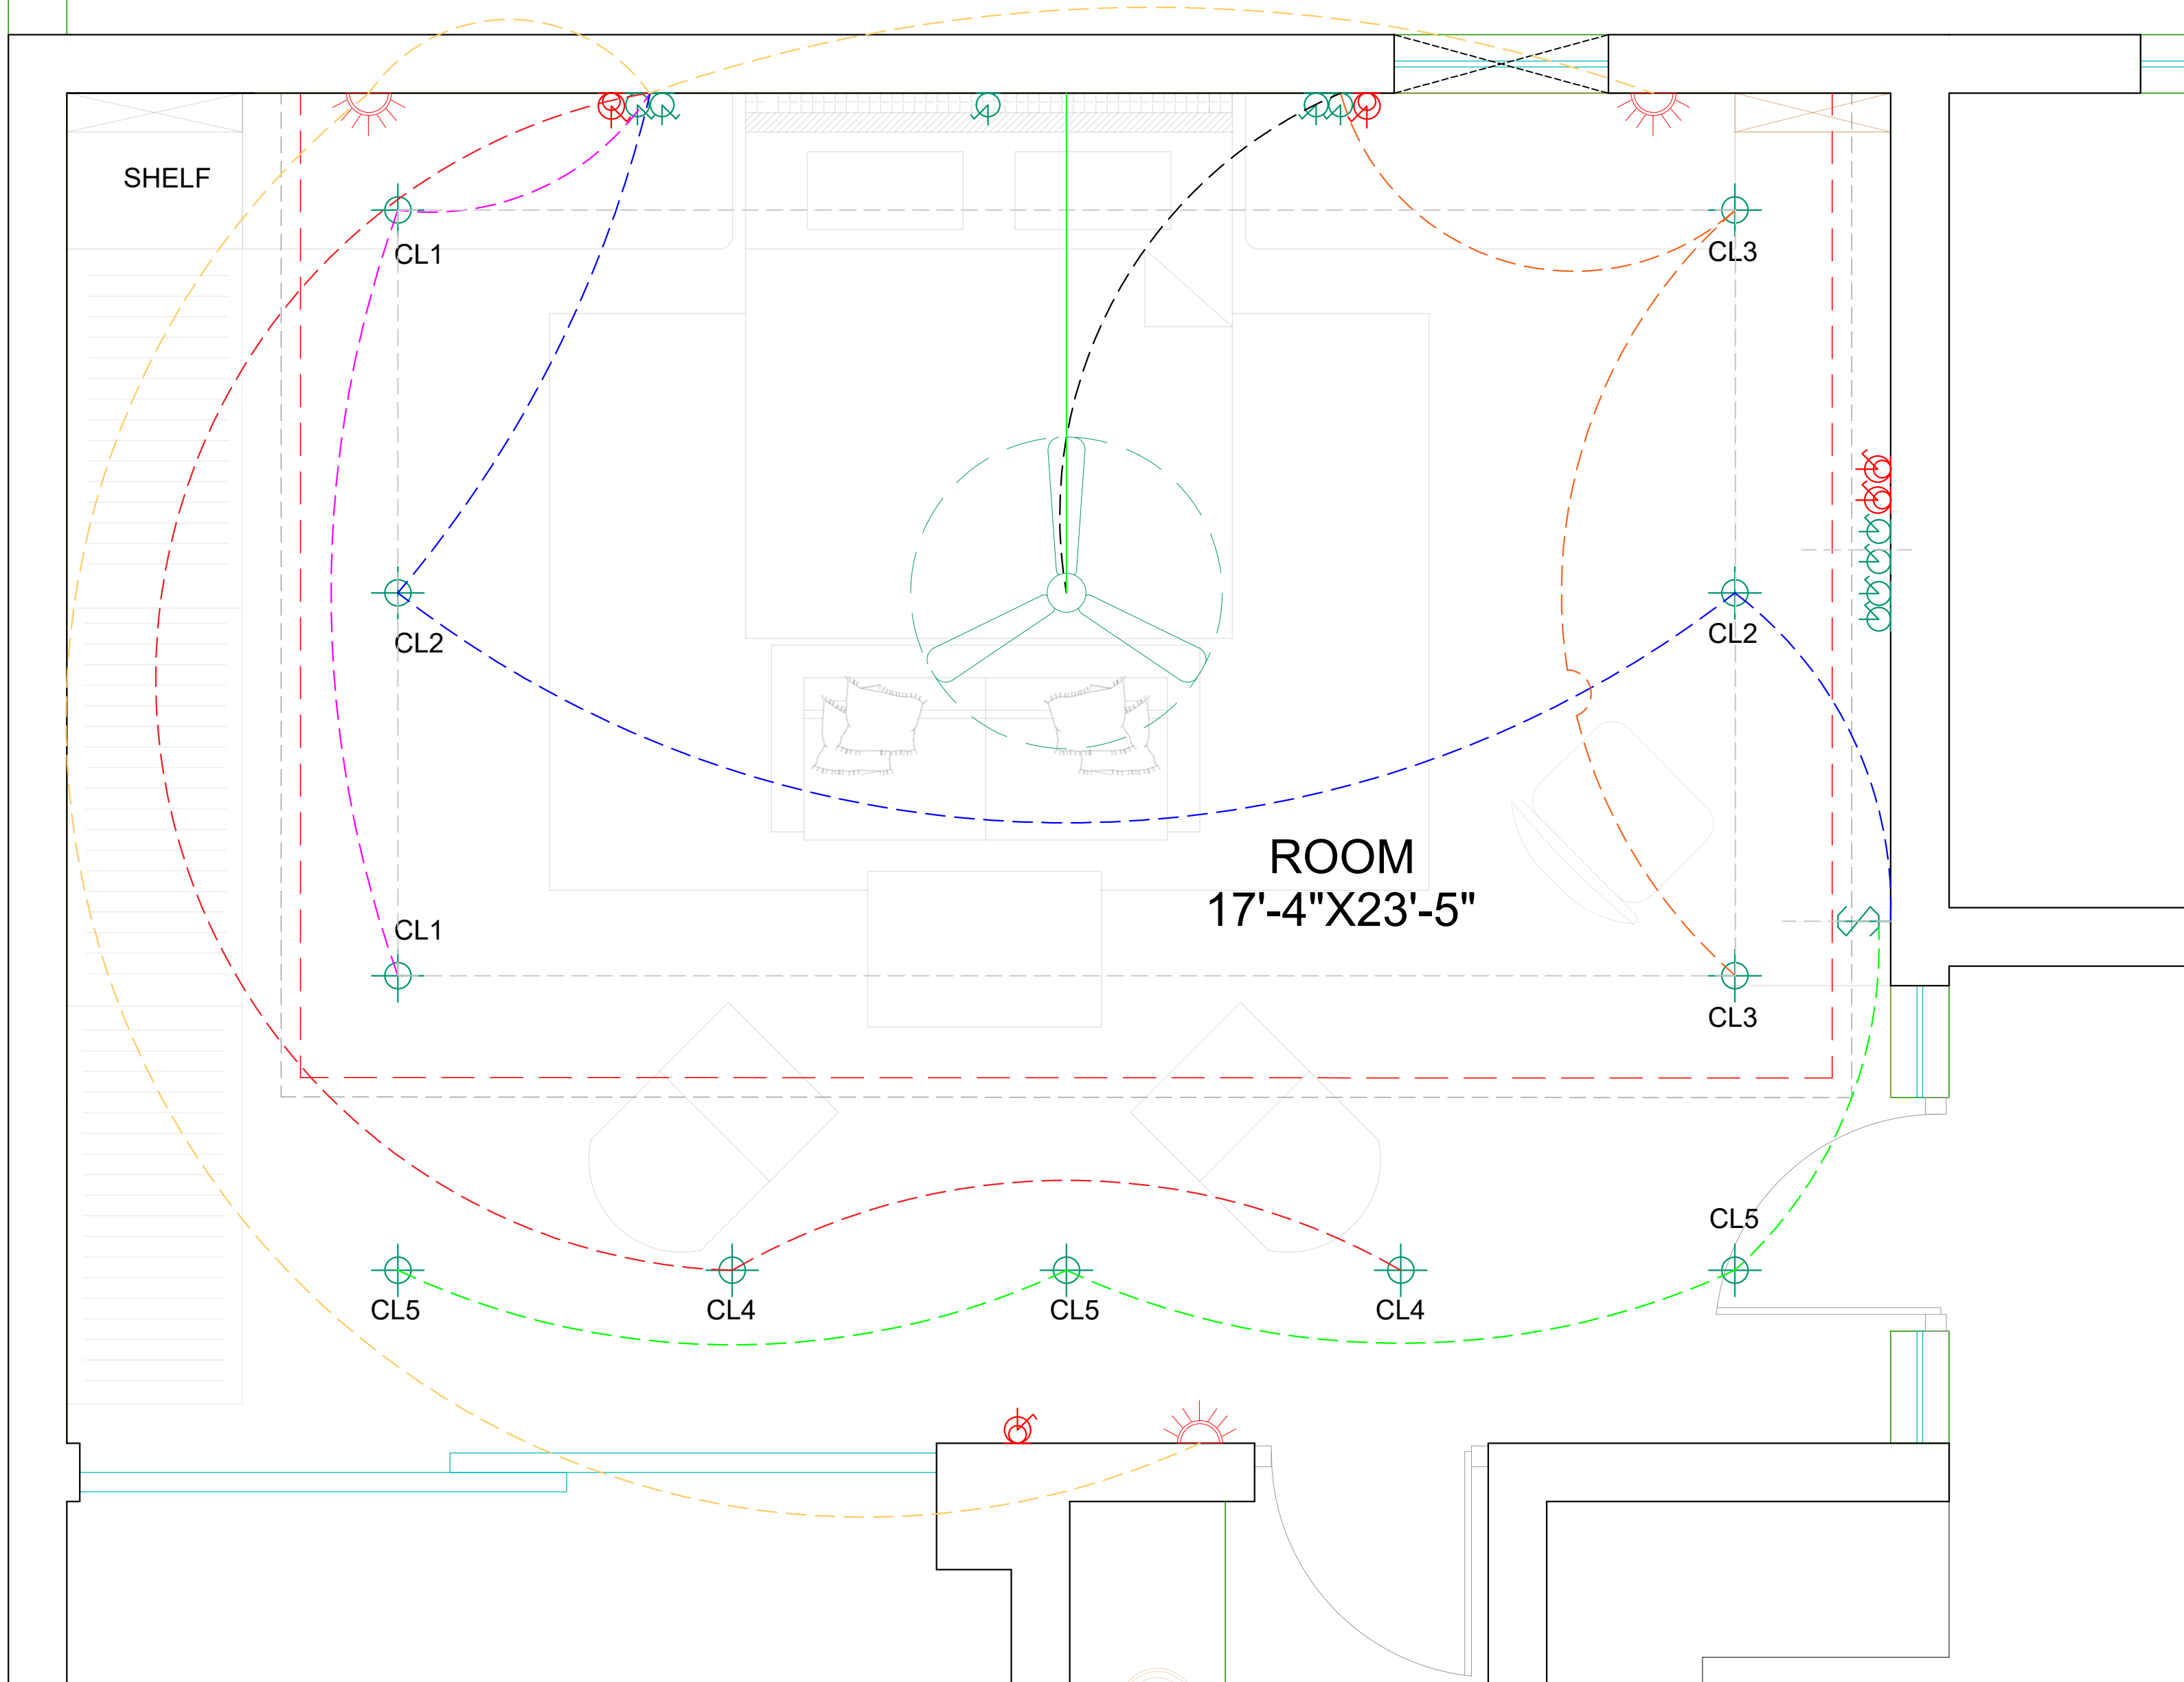

ELECTRICAL LAYOUT PLAN
LOOPING

LEGEND - ELECTRICAL

S.NO.	SYMBOL	DESCRIPTION OF ITEM	HT.
1		CEILING FAN	
2		SWITCH BOARD	
3		INDOOR NIGHT LIGHT	0'-6"
4		SPOT LIGHT	
5		BRACKET LIGHT	6'-6"
6		SWITCH SOCKET 6A.	
7		SWITCH SOCKET 16A.	
8		ANTENNA	

ARCHITECT:

NEERAV GUPTA

L-1, KRISHNA MARG, C- SCHEME,
JAIPUR (302001), RAJASTHAN.

PH.0141-2360825 E-Mail-ravigupta_15@yahoo.com

PROJECT:

**INTERIOR FOR
MRS. SHIVANGI**

DRAWING TITLE:

**ROOM RCP &
ELECTRICAL**

DRAWN BY:

PRIYANK

SCALE:

DATE:

29/11/2021

CHECKED BY:

**NEERAV
GUPTA**

NORTH:

DRAWING NO.:

NOTES: