


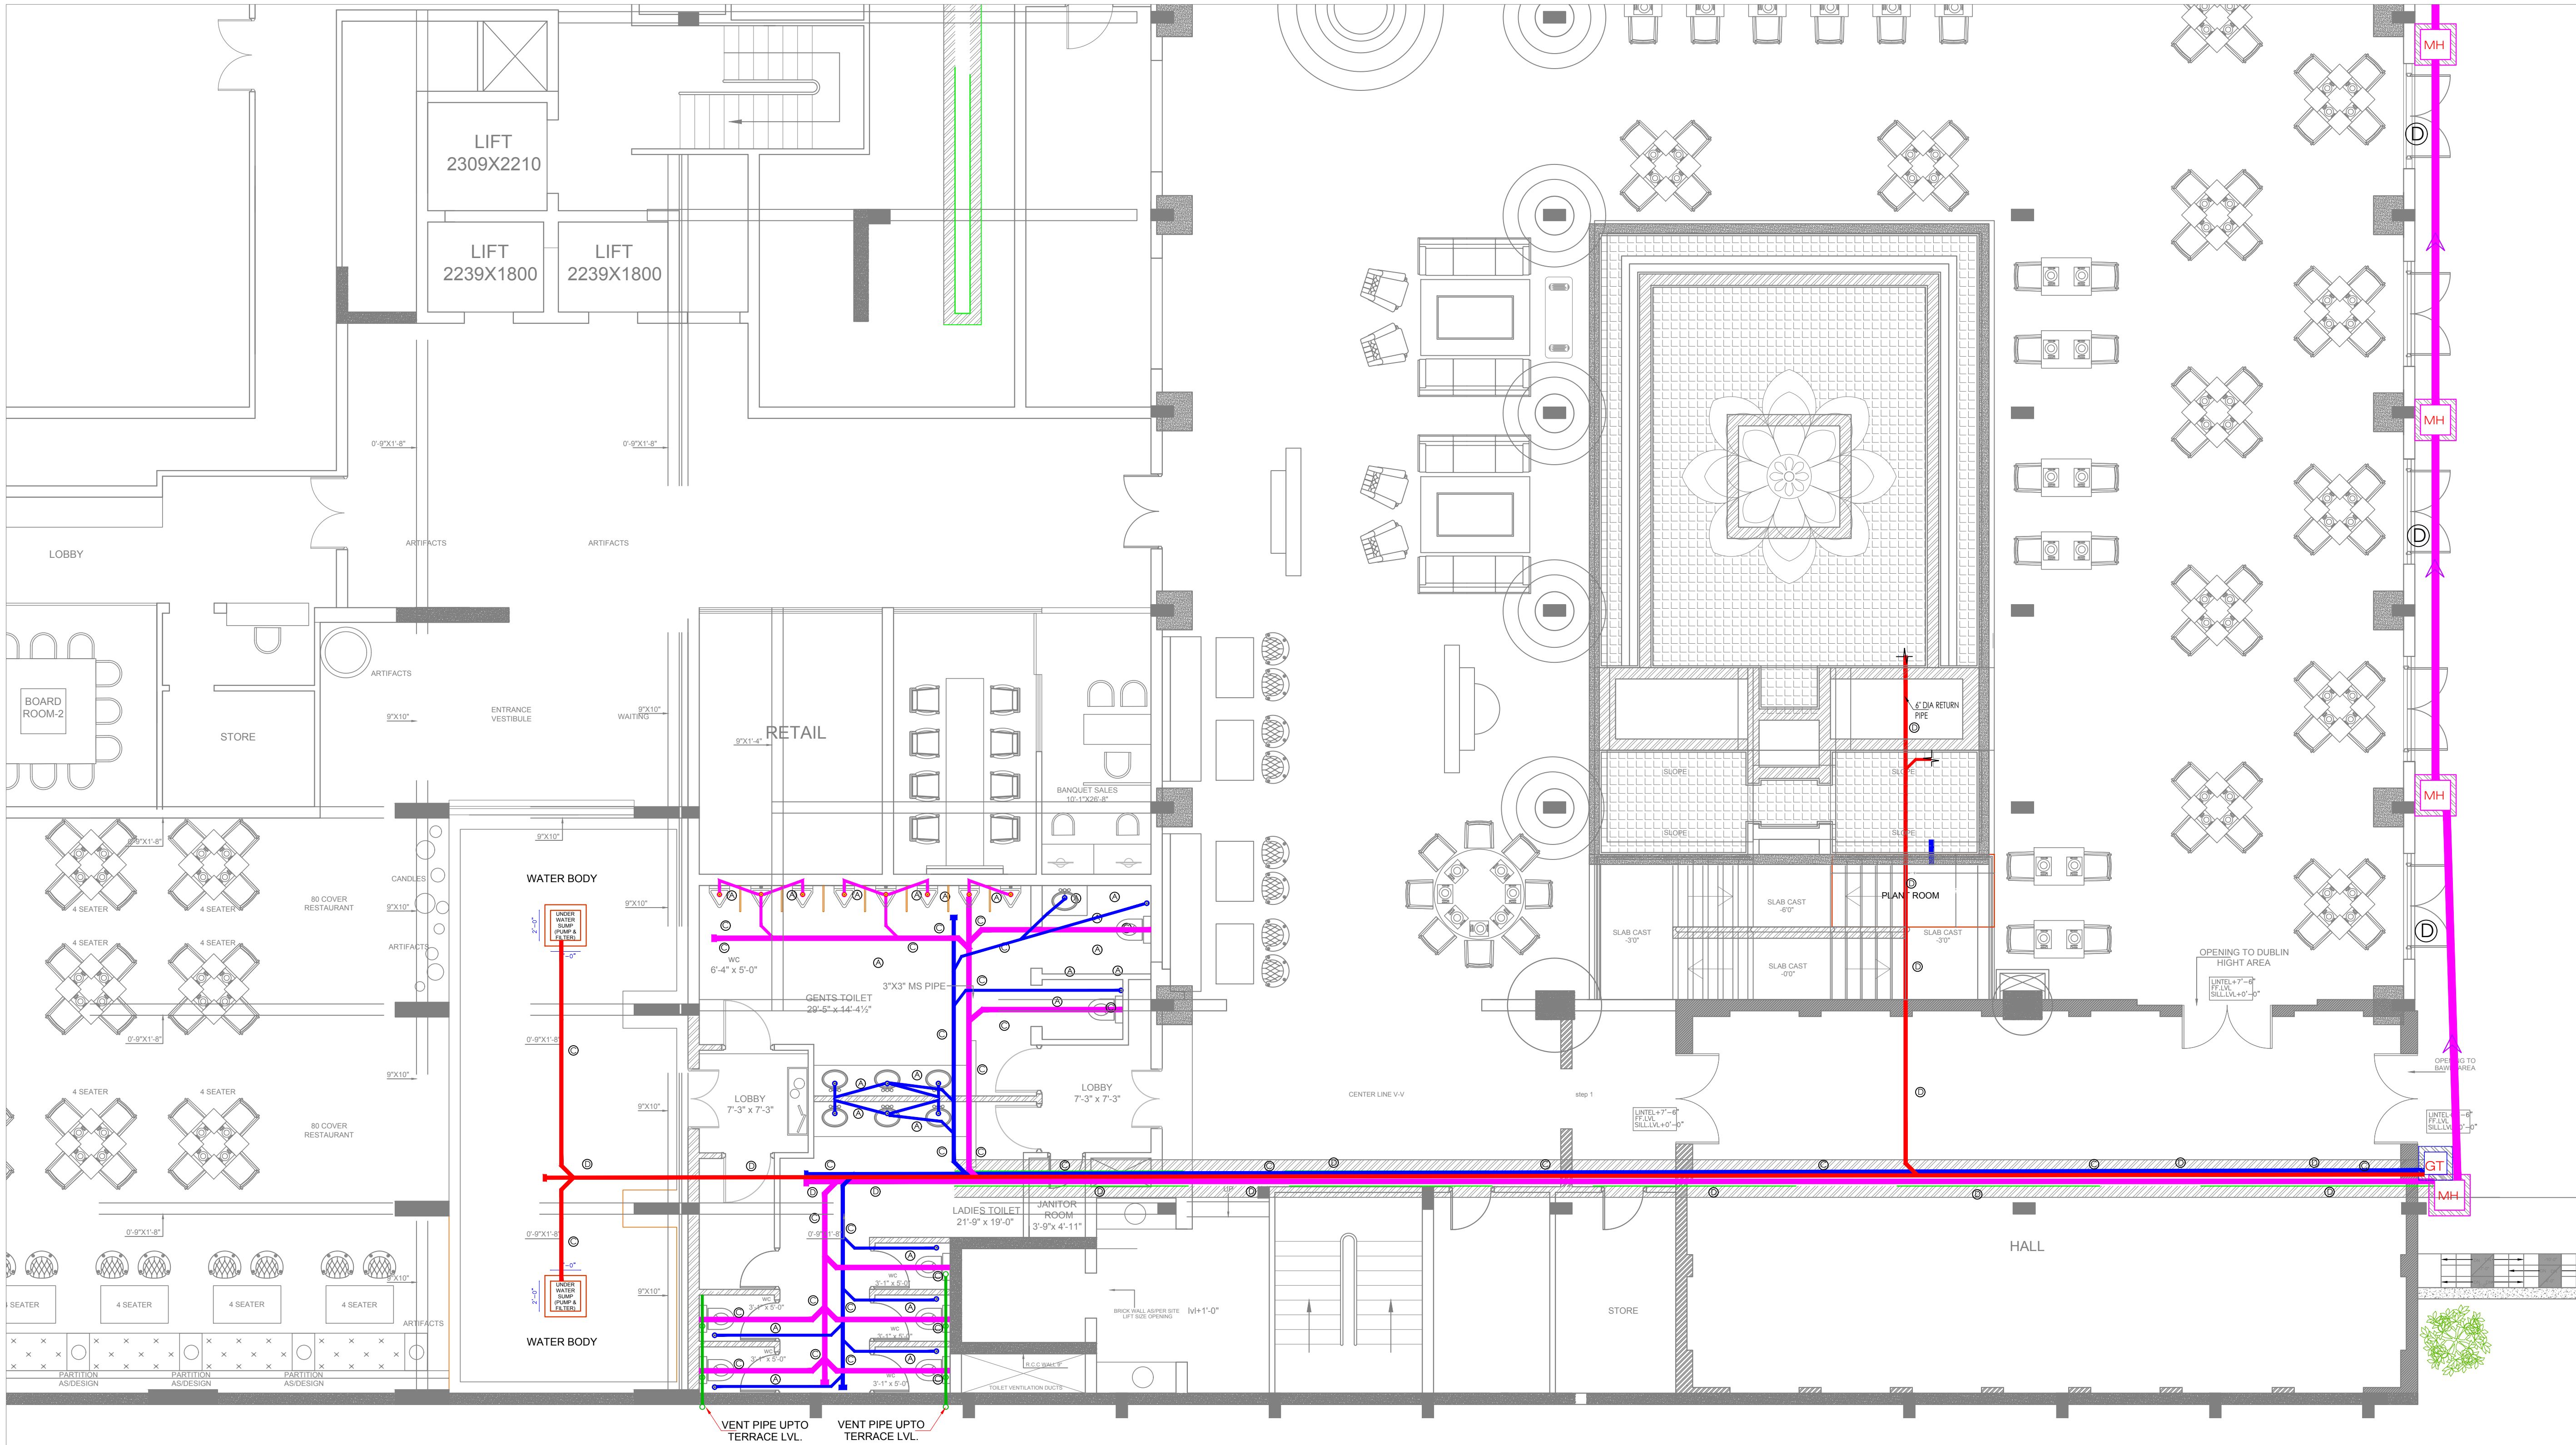

LEGEND:-

- 1. SOIL PIPE
- 2. WATER PIPE
- 3. KITCHEN DRAIN PIPE
- 4. F. TRAP
- 5. DRAIN POINT
- 6. COLD WATER SUPPLY
- 7. HOT WATER SUPPLY
- 8. HOT WATER RETURN
- 9. RAIN WATER PIPE LINE
- 10. AIR VENT PIPE
- 11. FLOOR CLEAN OUT PLUG (FCO)
- 12. CLEAN OUT PLUG (COP)
- 13. MANHOLE FOR SEWER LINE 2'-0" x 2'-0"
- 14. GULLY TRAP 1'-6" x 1'-6"
- 15. RAIN WATER COLLECTION MANHOLE 2'-0" x 2'-0"
- 16. KITCHEN DRAIN WATER MANHOLE 2'-0" x 2'-0"
- 17. WATER BODY DRAIN PIPE

RAIN WATER PVC PIPE SCHEDULE

PIPE NO.	SIZE	SLOPE
①	150Ø	1:200
②	200Ø	1:250
③	300Ø	1:300

WATER DRAINAGE PIPE SCHEDULE

PIPE NO.	SIZE	SLOPE
A	50Ø	1:90
B	75Ø	1:110
C	110Ø	1:110
D	150Ø	1:200

HOTEL CLARKS,
LUCKNOW

ARCHITECTS
NEERAV GUPTA
L-1, KRISHNA MARG, C- SCHEME,
JAIPUR (302001), RAJASTHAN.
PH.0141-2360825
E-Mail- architect_neeravgupta@yahoo.com

**BASEMENT FLOOR
WATER BODY AREA
DRAINAGE LAYOUT**

SCALE: N.T.S.
PROJECT NO.41
DRAWING NO:
NG/HCL/PLU/05C
REVISION NO.03
27.06.2019

SAN ENGINEERS & CONSULTANTS
G-2, 1055, CHITRAKOOT SCHEME, NEAR PRAGATI STADIUM,
VARDHANA, JAIPUR-302021, RAJASTHAN.
PH.0141-4028831
E-mail: info@saneepl.com