



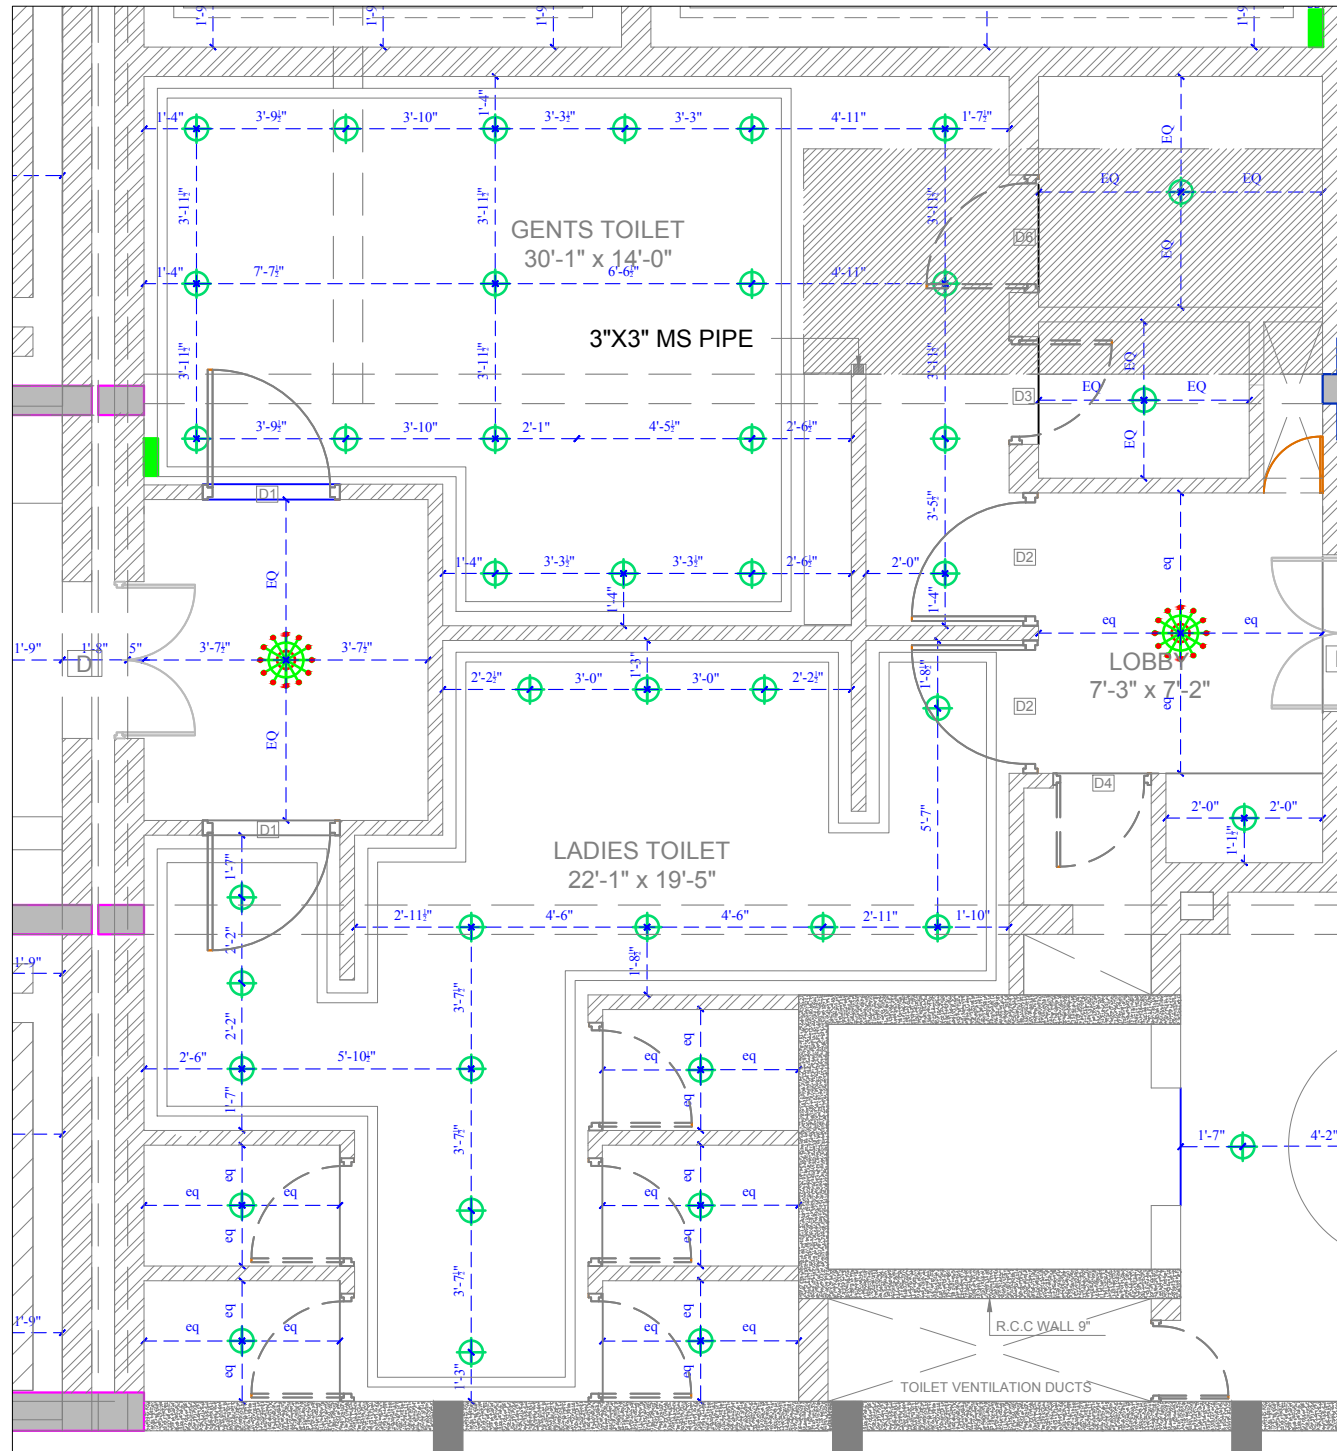

TOILET REFLECTED CEILING ELECTRICAL PLAN

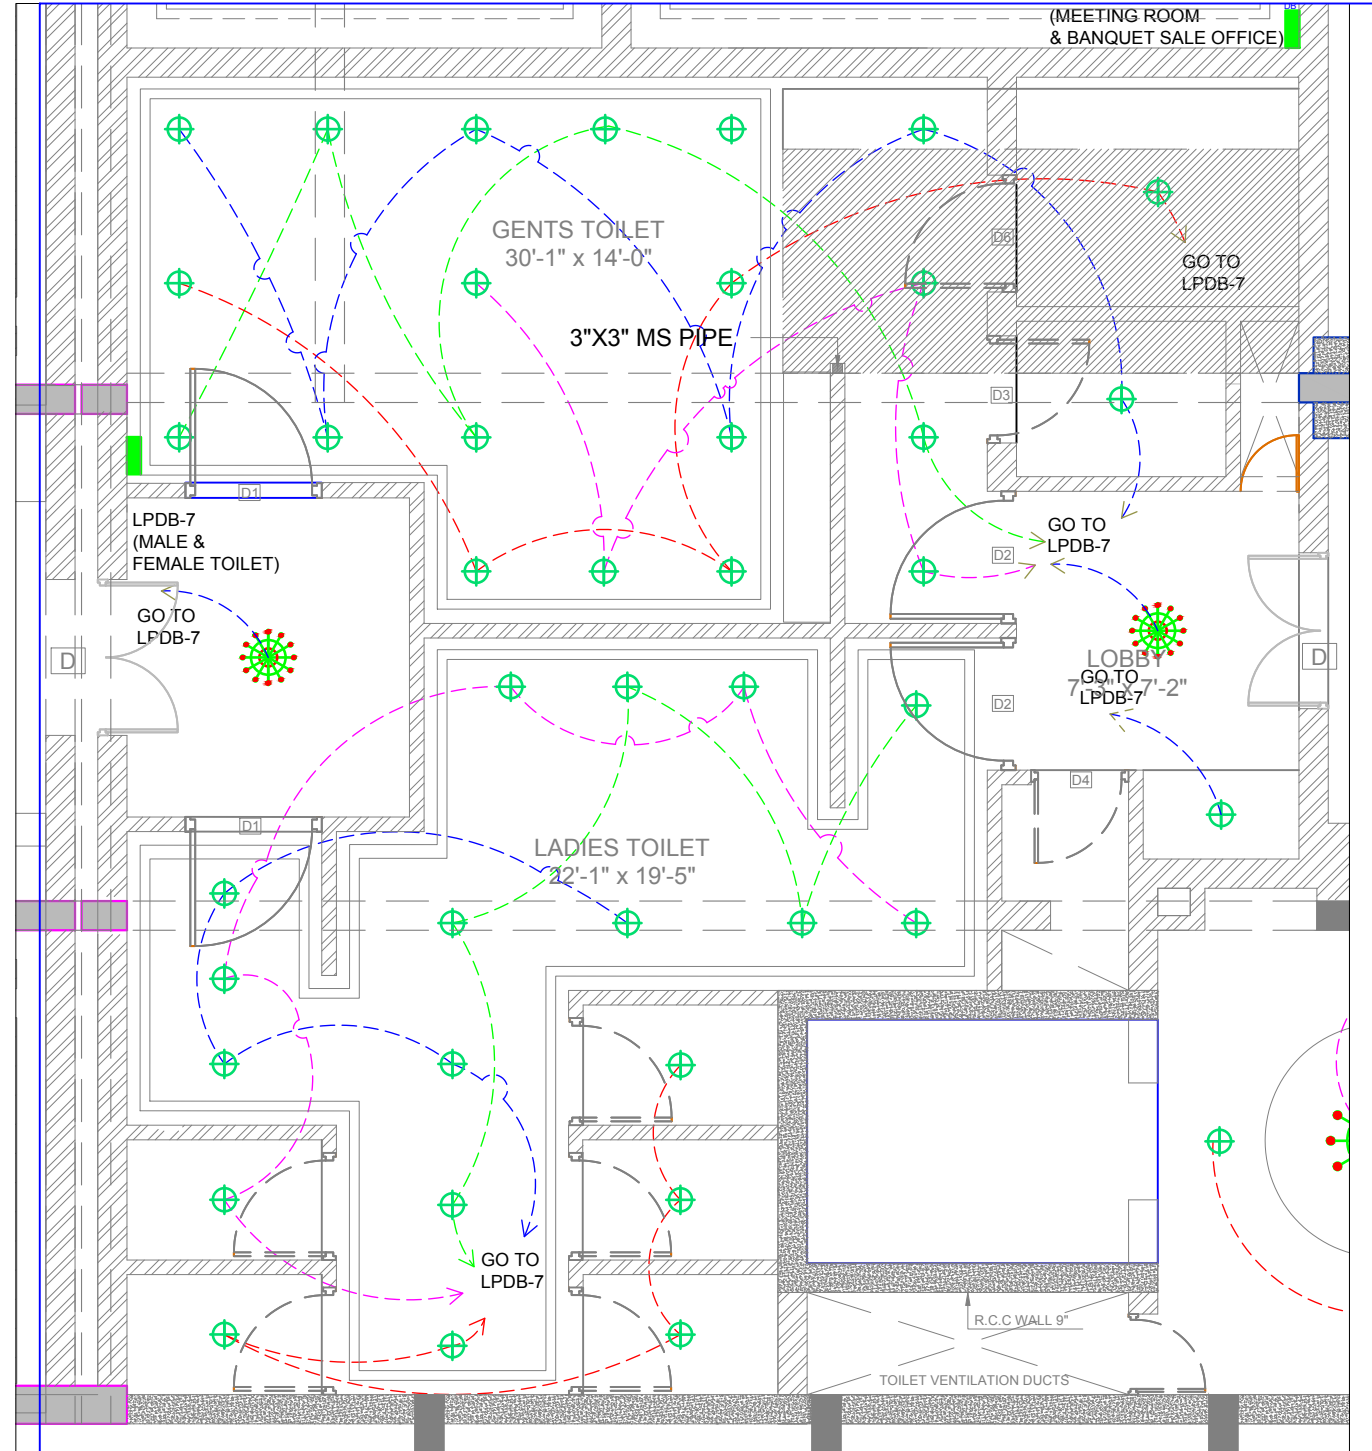

TOILET CEILING WIRE DIAGRAM

LEGEND - ELECTRICAL

S.NO.	SYMBOL	DESCRIPTION OF ITEM	WT.
1		CEILING FAN	
2		SWITCH BOARD	
3		BRACKET LIGHT	6'-0"
4		RETROFIT CFL INTEGRATED	
5		SWITCH SOCKET 6A.	
6		SWITCH SOCKET 16A.	
7		ANTENNA	
8		CHANDELLIER	
9		DISTRIBUTION BOX	
10		PICTURE LIGHT	
11		HANGING LIGHT	
12		CHANDELLIER	
13		UPLIGHTERS	
14		DOWNLIGHTERS	
15		DO NOT DISTURB (DND)	
16		CARD HOLDER	
17		AIR CONDITIONER	
18		FOOT LIGHT	
19			

ARCHITECT:
NEERAV GUPTA
L-1, KRISHNA MARG, C- SCHEME,
JAPUR (202001), RAJASTHAN,
PIN-304112-206002
E-Mail-architect_neeravgupta@yahoo.com

PROJECT:
CLARKS

DRAWING TITLE:
TOILET ELECTRICAL

DRAWN BY: DEEPIKA
CHECKED BY: NEERAV GUPTA

SCALE: N.T.S.
NORTH: -

DATE: 13-3-2019
PROJECT: CABA/TOILEL/01

NOTES:
THE COPYRIGHT AND PROPERTY OF THIS DESIGN AND DRAWING BELONGS TO NEERAV GUPTA. IT MUST NOT BE COPIED OR REPRODUCED IN ANY MANNER WITHOUT THEIR WRITTEN CONSENT. A LEGAL ACTION AS PER LAW MAY BE INITIATED AGAINST THE OFFENDER.