


P.O.P FALSE CEILING @2500MM HT. FROM FFL

PROVISION FOR CURTAIN AND CURTAIN RODS AS PER SELECTION

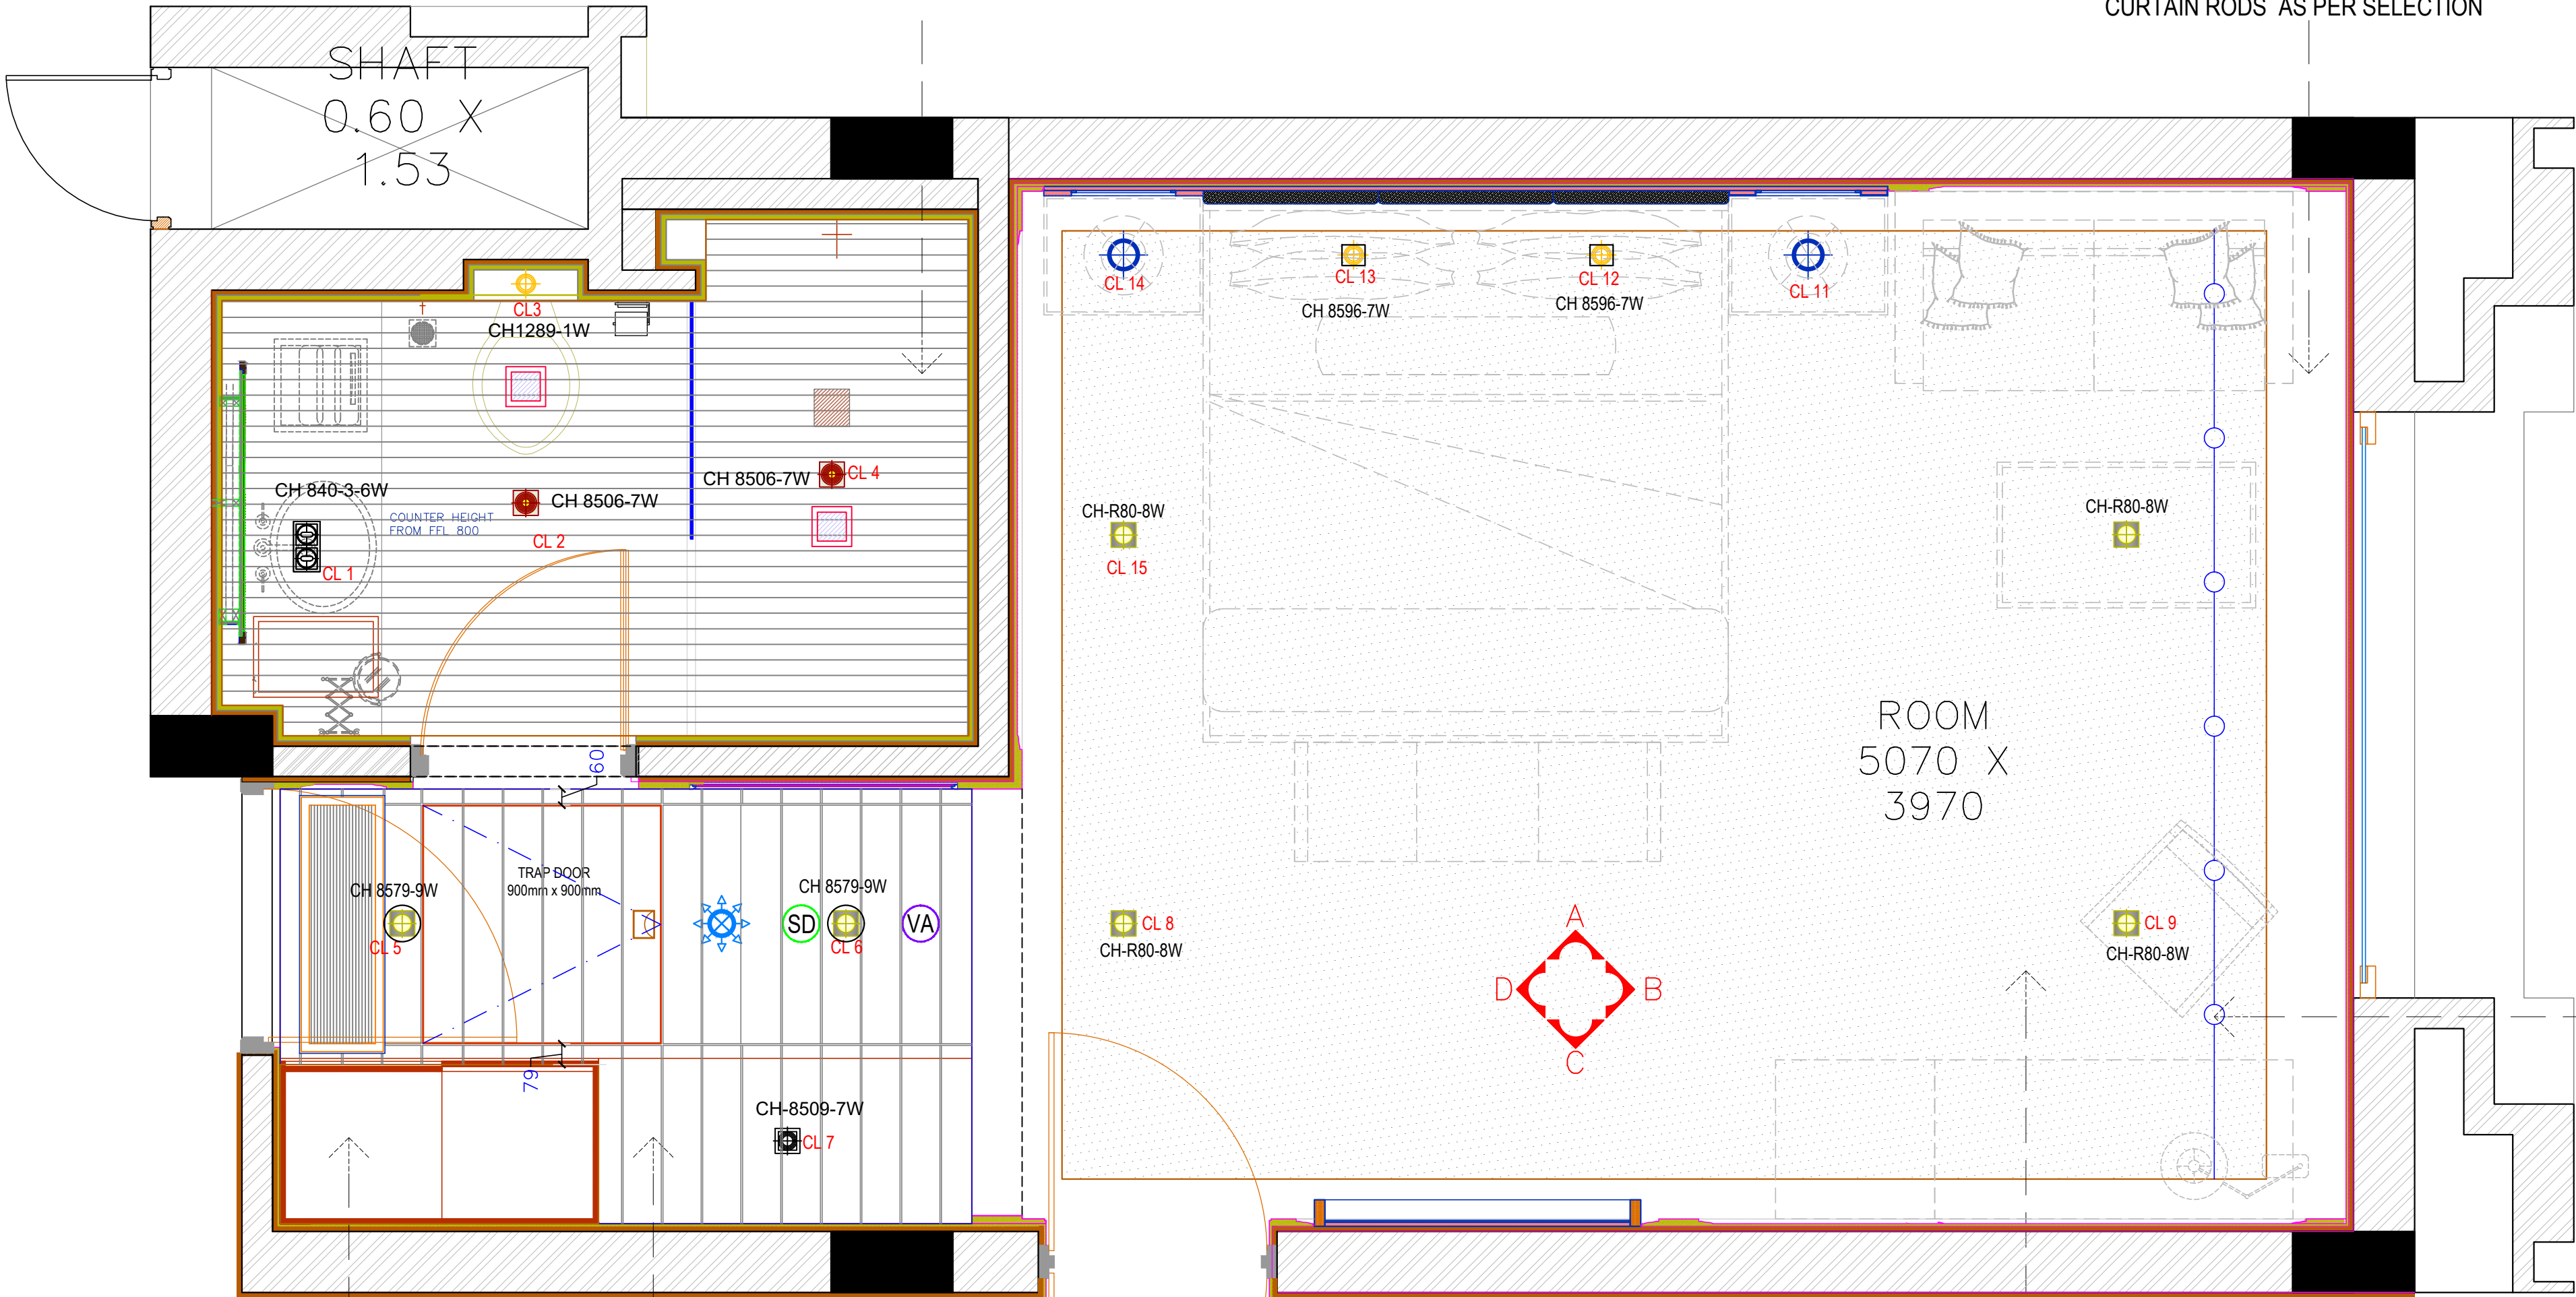

WOODEN PANEL WITHOUT VENEER

FALSE CEILING @2500MM HT. FROM FFL FINISHED IN APP. VENEER TREATED WITH MELAMINE POLISH 6MM GROVES AT 150MMC/C

P.O.P MESH CEILING @2845MM HT. FROM F.F.L FINISHED IN APP. SHADE OF PAINT

SR. NO.			SYMBOL			DESCRIPTION		
1						ADJUSTABLE DOWN LIGHT (7W)		
2						8 WATT DOWN LIGHT		
3						ADJUSTABLE PIN SPOT (1 W)		
4						HANGING LIGHT		
5						IP 65 RATED DOWN LIGHT (7W)		
6						ADJUSTABLE (8W) DUAL WALL WASHER		
7						9 WATT DOWN LIGHT		
8						ADJUSTABLE PIN SPOT (1 W)		
9						VOICE ANNUNCIATION CEILING SPEAKER		
10						SMOKE DETECTOR		
11						CEILING SPRINKLER		
12						EXTENDED COVERAGE SIZE WALL SPRINKLER (2000MM X 1000MM)		

ARCHITECT:				
RAVI KUMAR GUPTA				
CA/83/7739				
L-1, KRISHNA MARG, C-SCHEME, JAI PUR (302001), RAJASTHAN, PH. 0141-2360825				
© Ravi Kumar Gupta. All Rights Reserved.				
PROJECT:				
RESORTS OF MAKERS CHAMBER				
LOCATION:		JAI PUR		
DRAWING TITLE:				
KING ROOM TYPE 1 REFLECTED CEILING PLAN				
DRAWN BY:		SCALE:	DATE:	NORTH:
DEEPIKA		N.T.S	02-01-20	
CHECKED BY:		DRAWING NO.		
NEERAY GUPTA		G/R/M/E/1		
NOTE:				
THIS DRAWING IS THE PROPERTY OF THE ARCHITECT AND SHOULD NOT BE REPRODUCED OR COPIED IN ANY FORM OR BY ANY MEANS WITHOUT THE WRITTEN CONSENT OF THE ARCHITECT. ANY VIOLATION OF THIS LAW MAY BE PROSECUTED AGAINST THE OFFENDER.				