


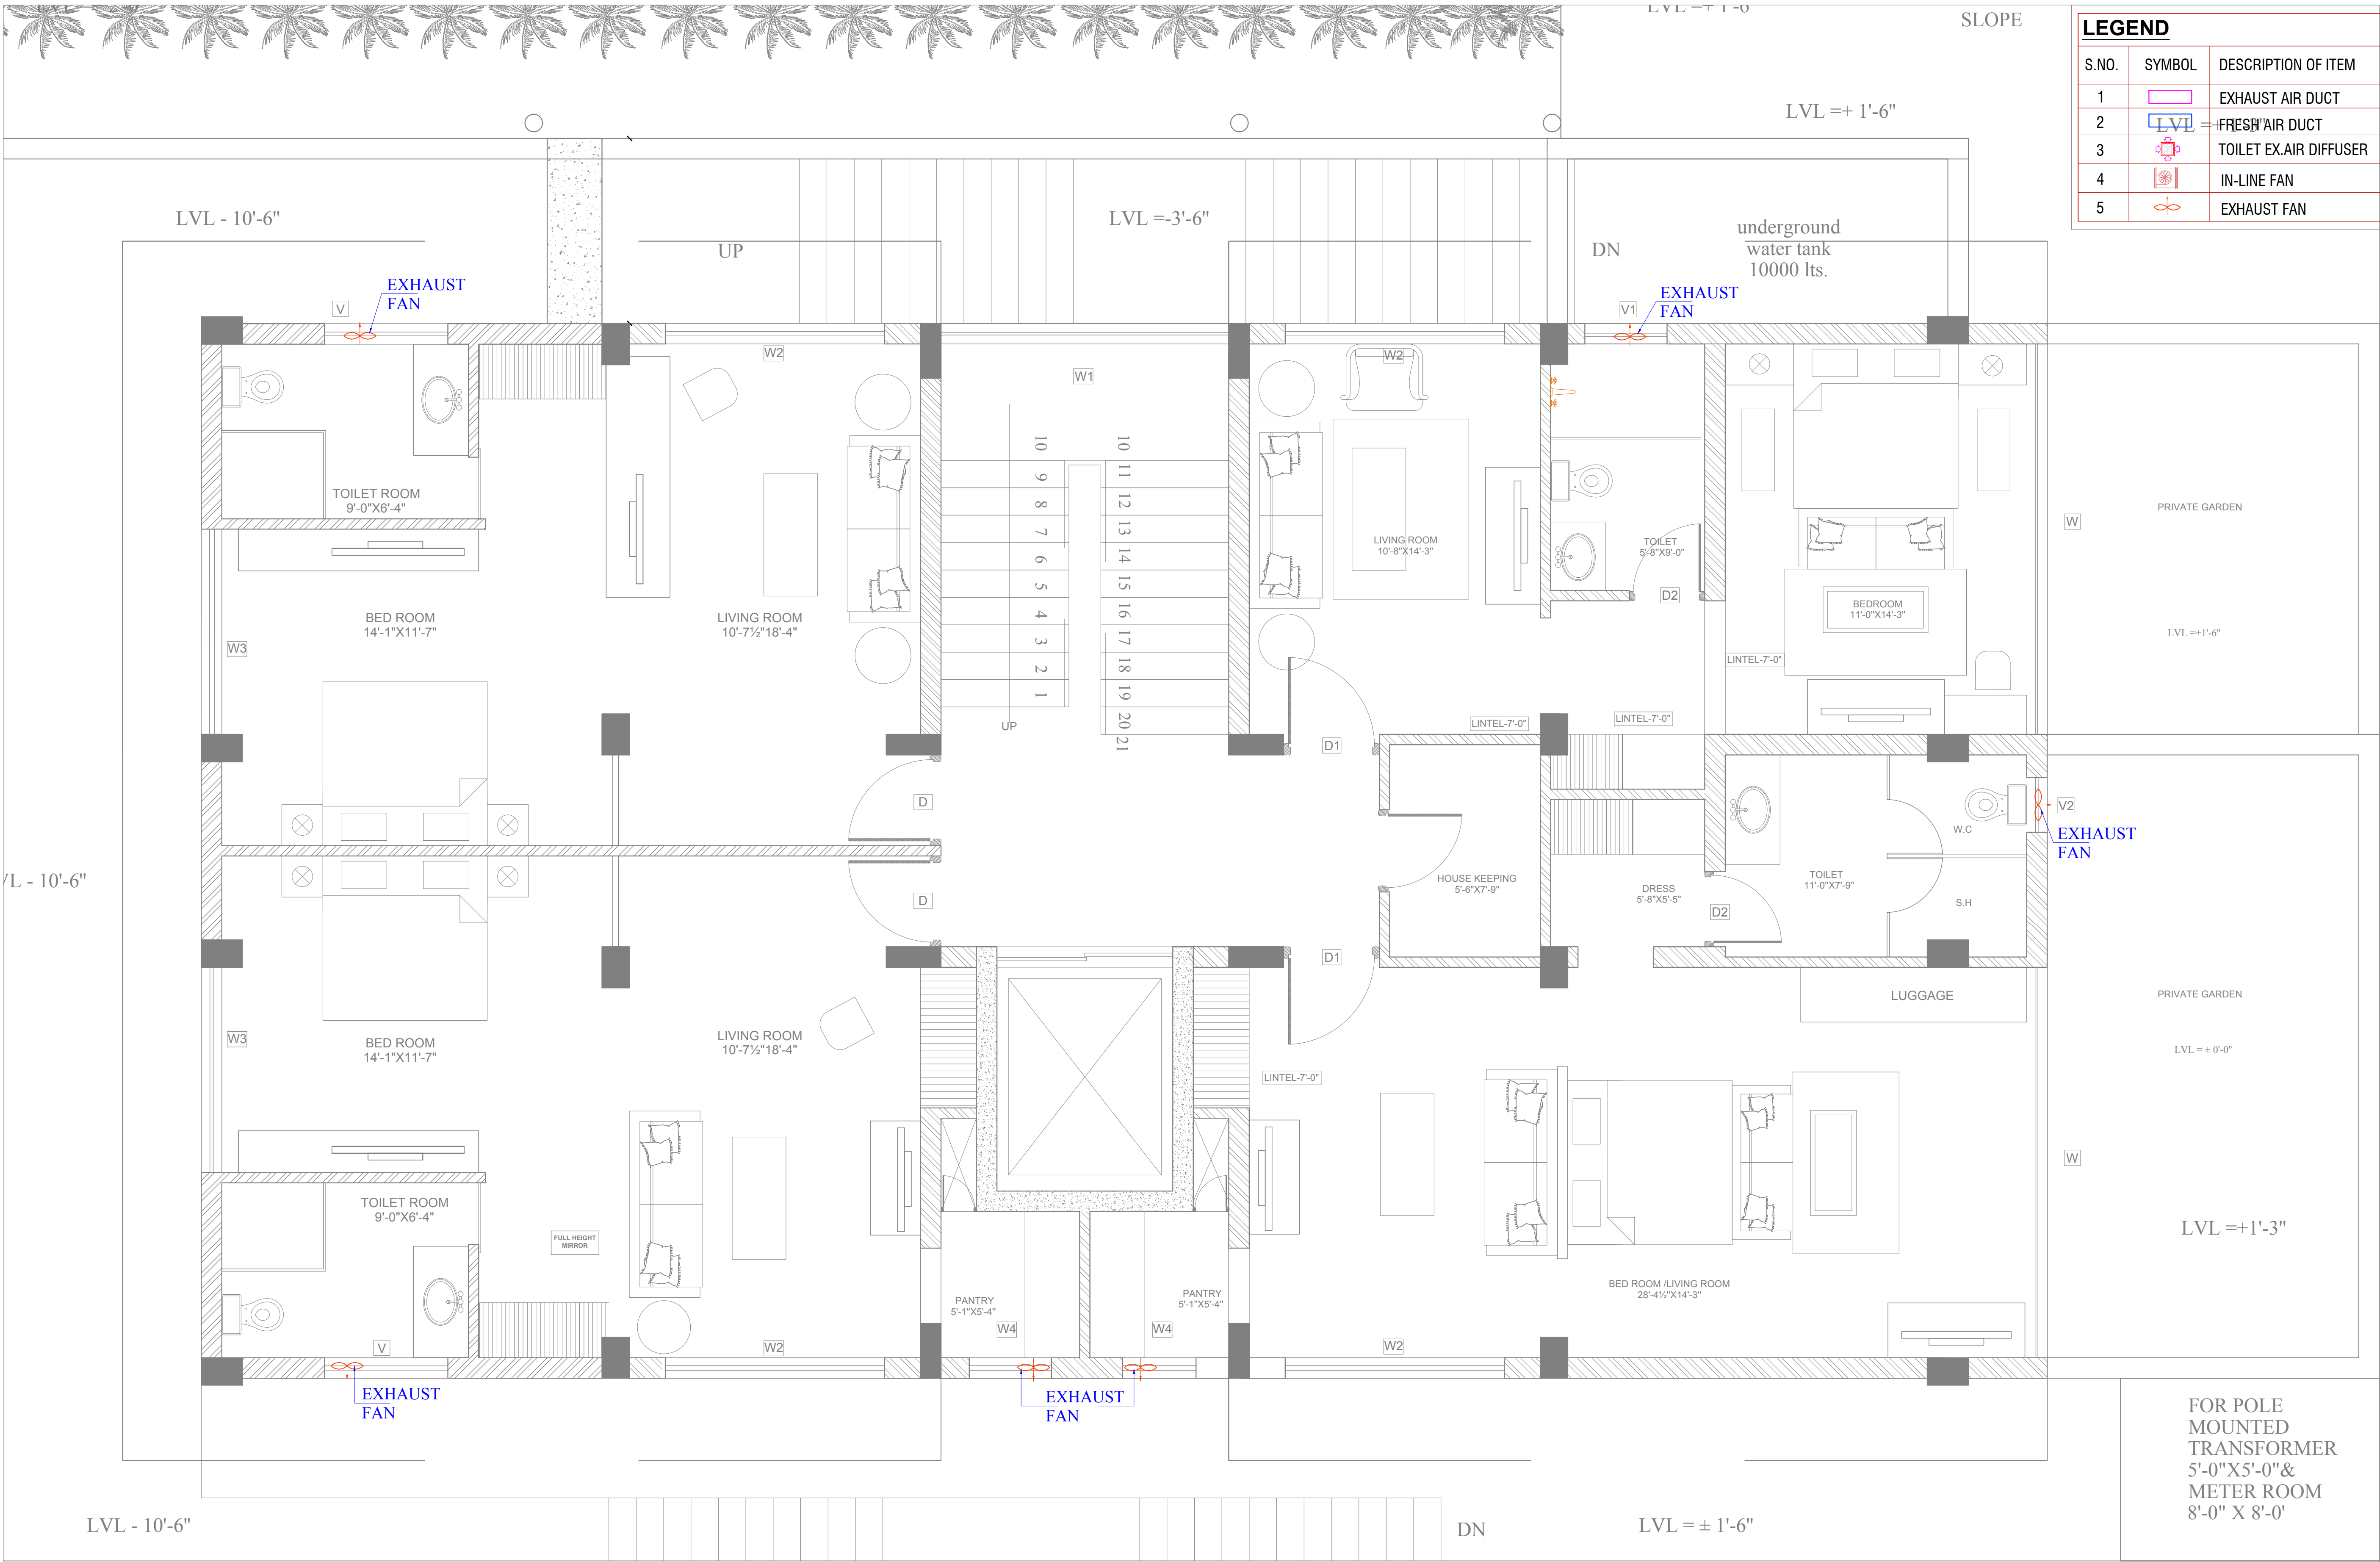

(R-12)-REVISED GROUND FLOOR PLAN
DATE-22-12-2018


HOTEL CLARKS,
JAIPUR

ARCHITECTS
NEERAV GUPTA
L-1, KRISHNA MARG, C- SCHEME,
JAIPUR (302001), RAJASTHAN.
PH.0141-2360825
E-Mail- architect_neeravgupta@yahoo.com

GROUND FLOOR
TOILET EXHAUST LAYOUT

SCALE: N.T.S.

PROJECT NO-42
DRAWING NO:
NGHCHVAC02
REVISION NO:
16.01.2019

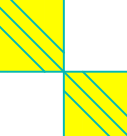
SAN ENGINEERS & CONSULTANTS
G-2, 1055, CHITRAKOOT SCHEME, NEAR PRATAP STADIUM,
OPPOSITE TAGORE FOUNDATION SCHOOL, VAISHALI NAGAR,
E-mail- info@sancpl.com