


SYMBOL	DESCRIPTION
	SUPPLY AIR DUCT
	EXHAUST AIR DUCT
	FRESH AIR DUCT
	SUPPLY AIR DIFFUSER
	RETURN AIR DIFFUSER
	EXHAUST AIR GRILLE
	RETURN AIR DUCT
	CHW SUPPLY PIPE
	CHW RETURN PIPE
	DRAIN PIPE

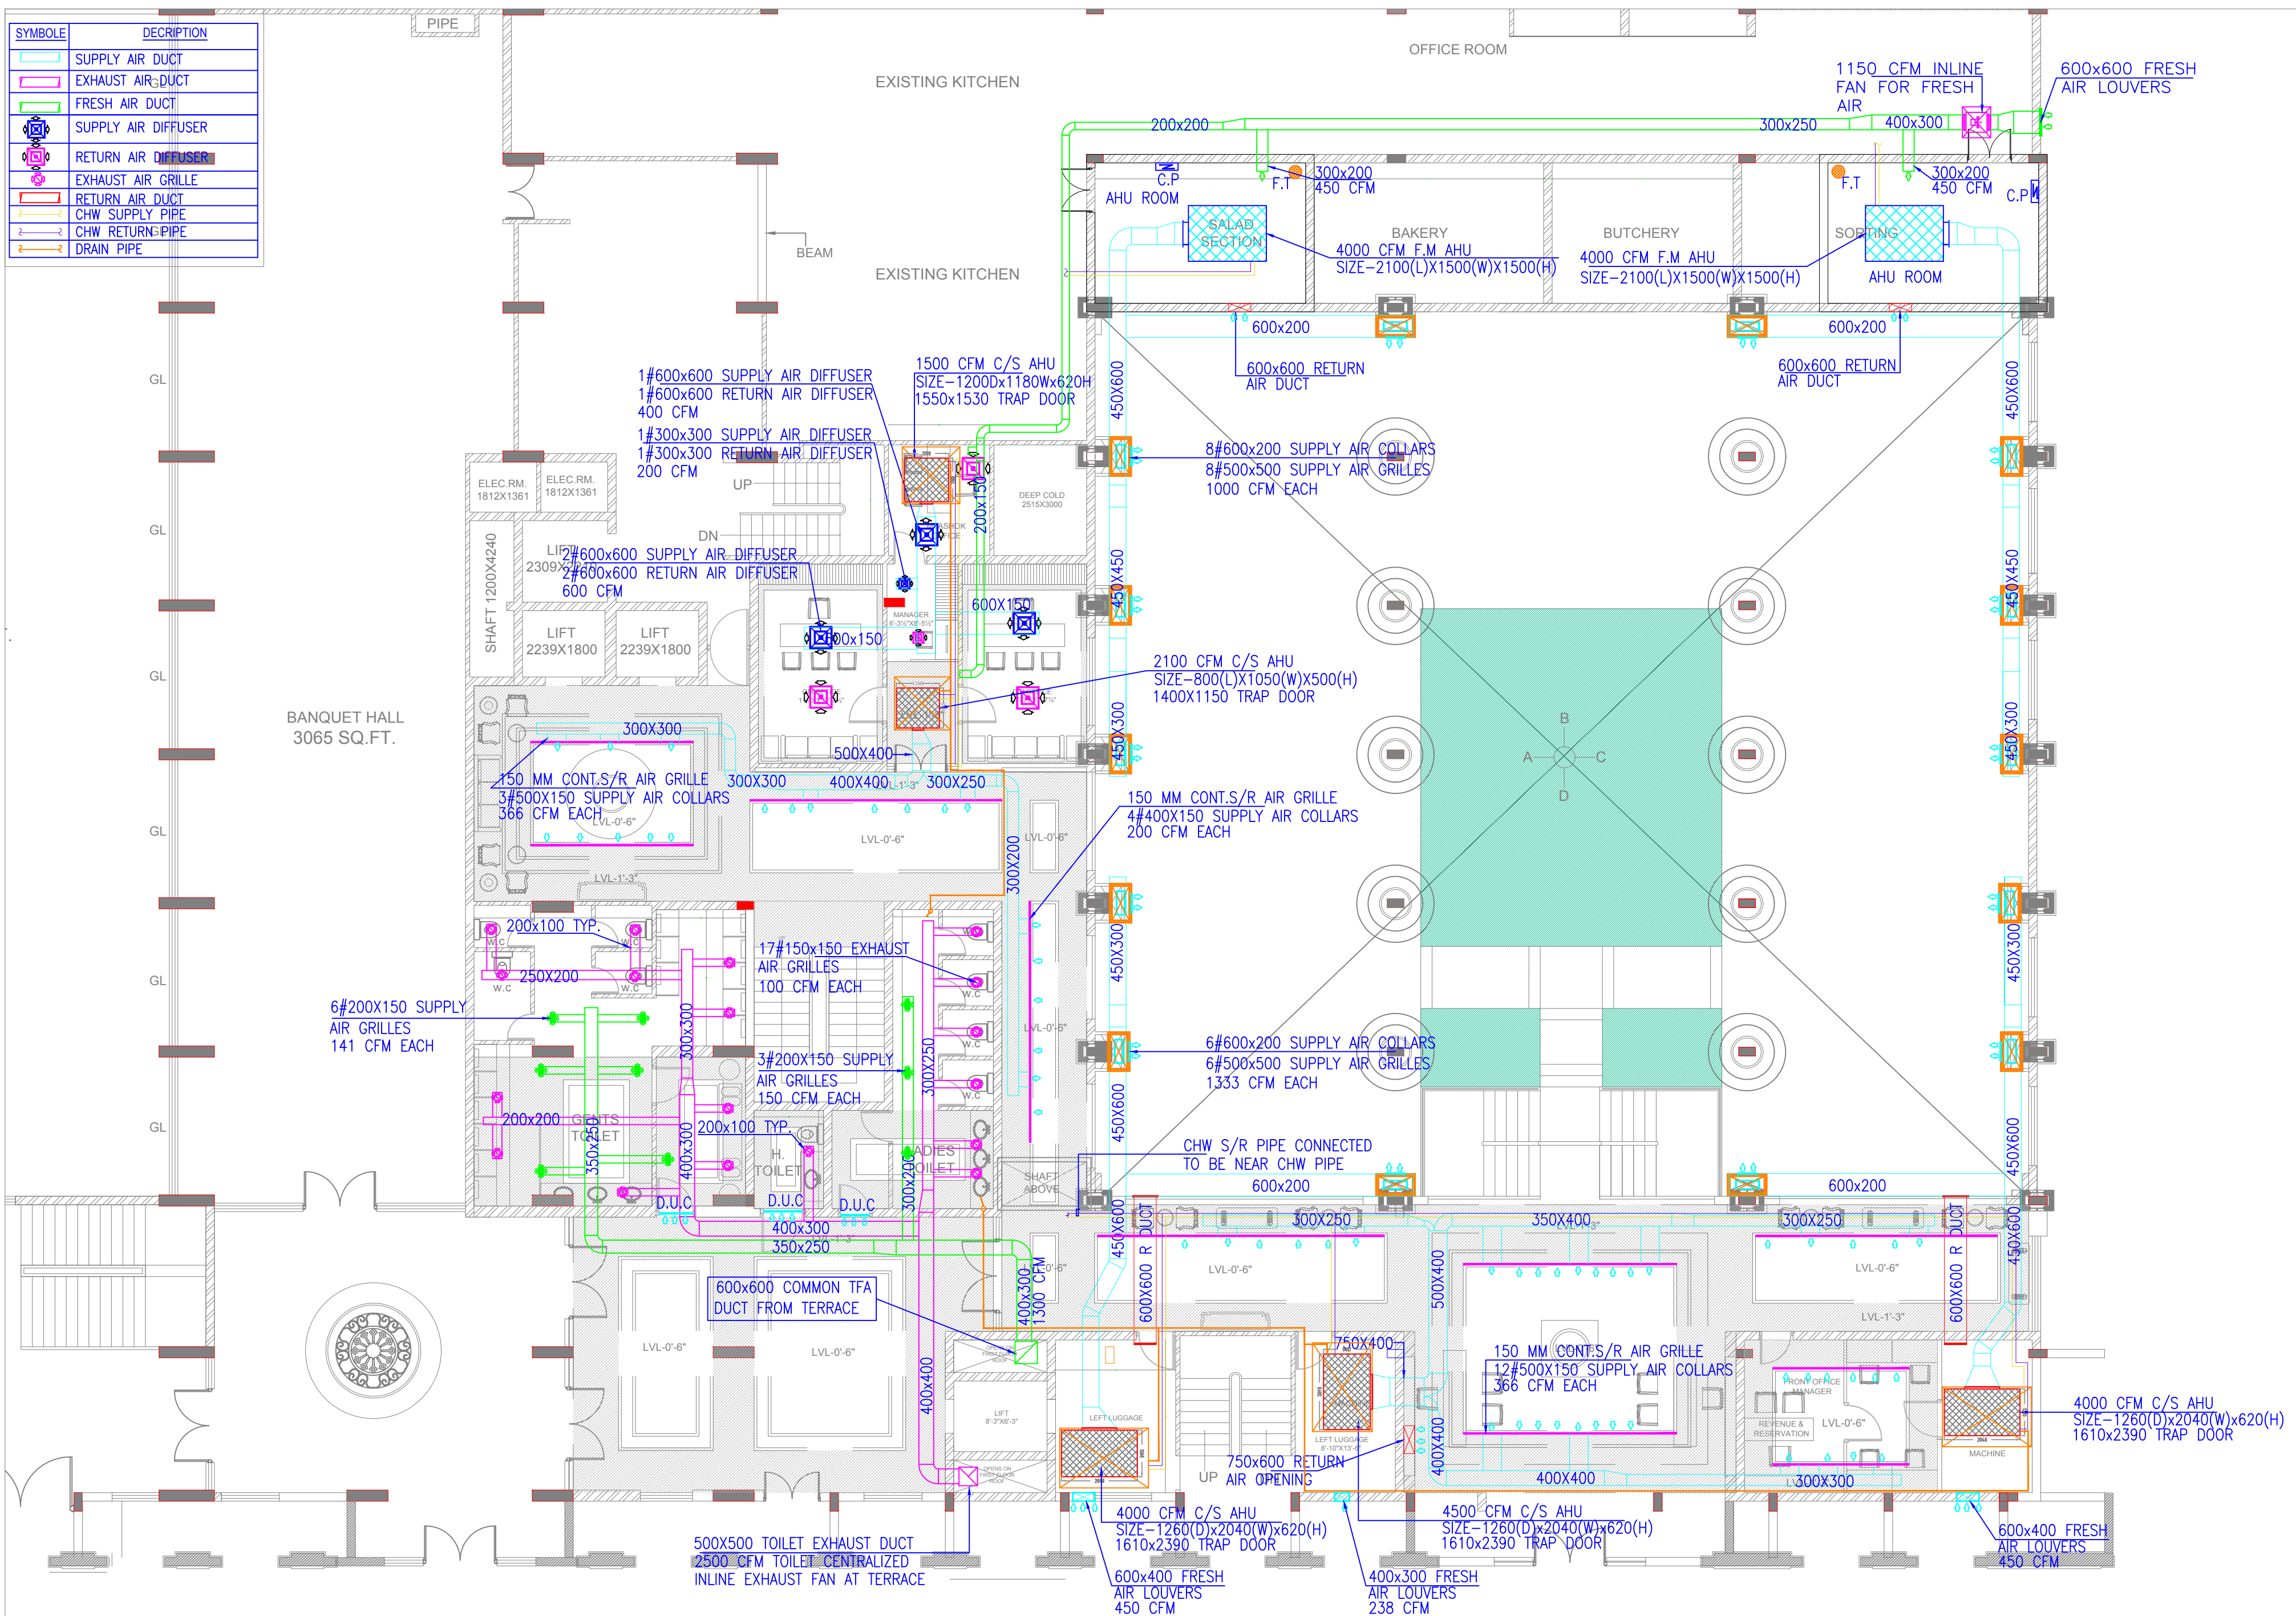

HOTEL CLARKS, LUCKNOW

NEERAV GUPTA
L-1, KRISHNA MARG, C- SCHEME,
JAIPUR (302001), RAJASTHAN.
PH.0141-23680825
E-Mail- architect_neeravgupta@yahoo.com

GROUND FLOOR HVAC LAYOUT

SCALE: N.1.1.3.

DRAWING NO:
NG/HCL/HVAC/02

REVISION NO:01

08.06.2018



SAN ENGINEERS & CONSULTANTS
 G-2, 10/55 CHITRAKOOT SCHEME, NEAR PRATAP STADIUM,
 VASHALI NAGAR, JAIPUR
 +91-141-4026831
 E mail: saneept@gmail.com