




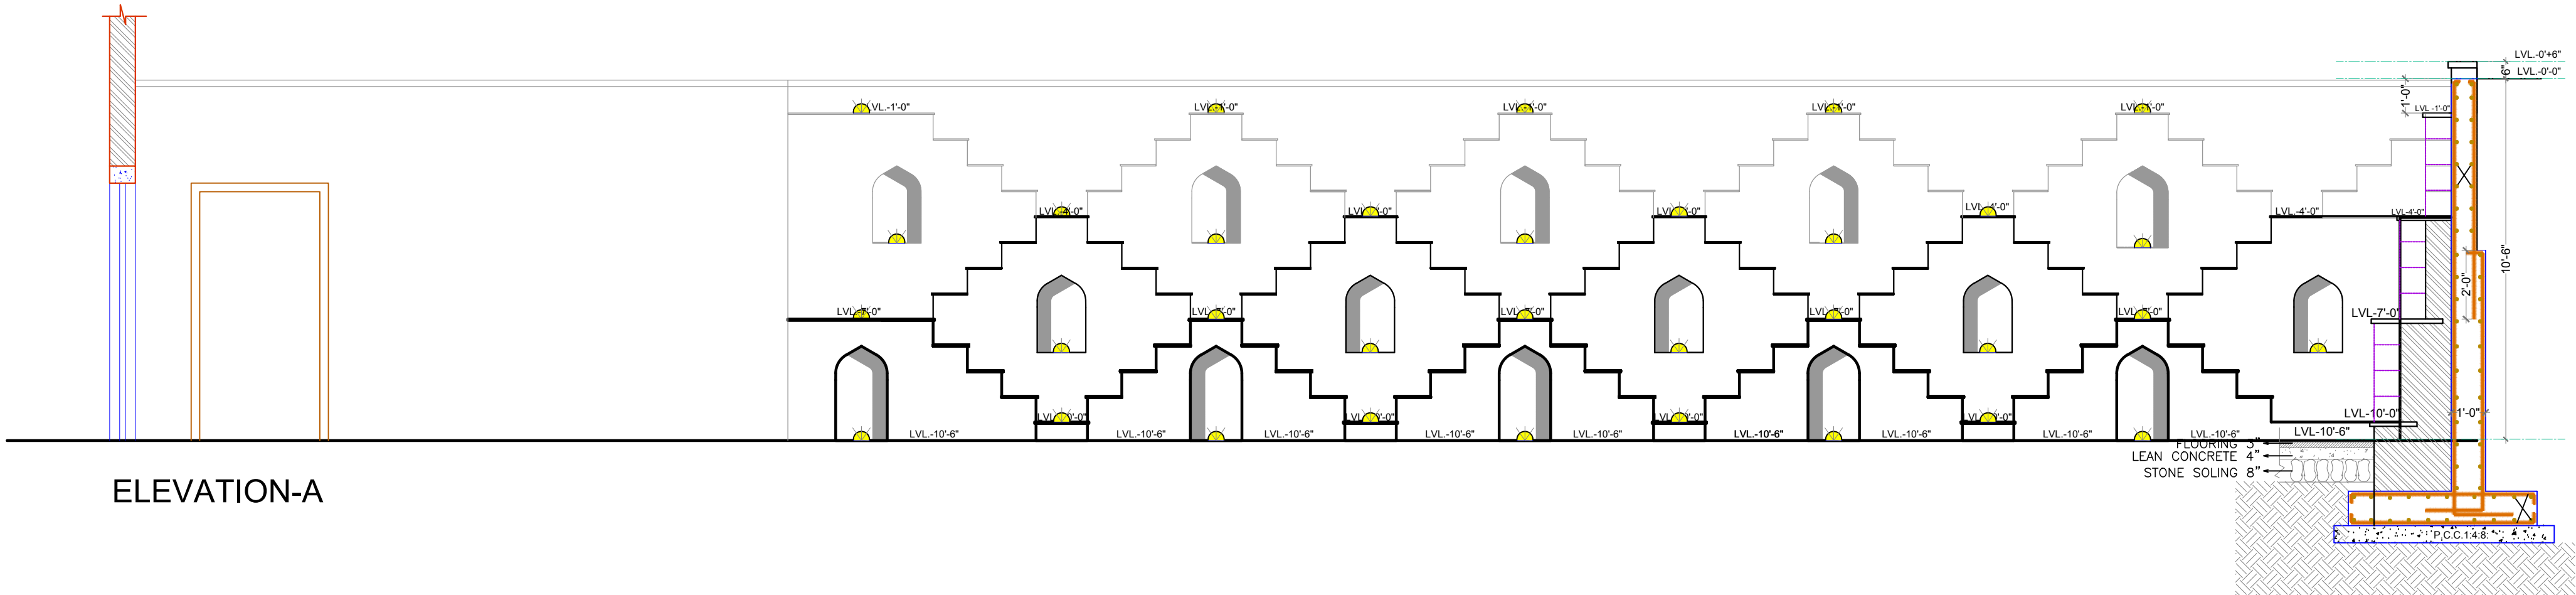

ELEVATION-A

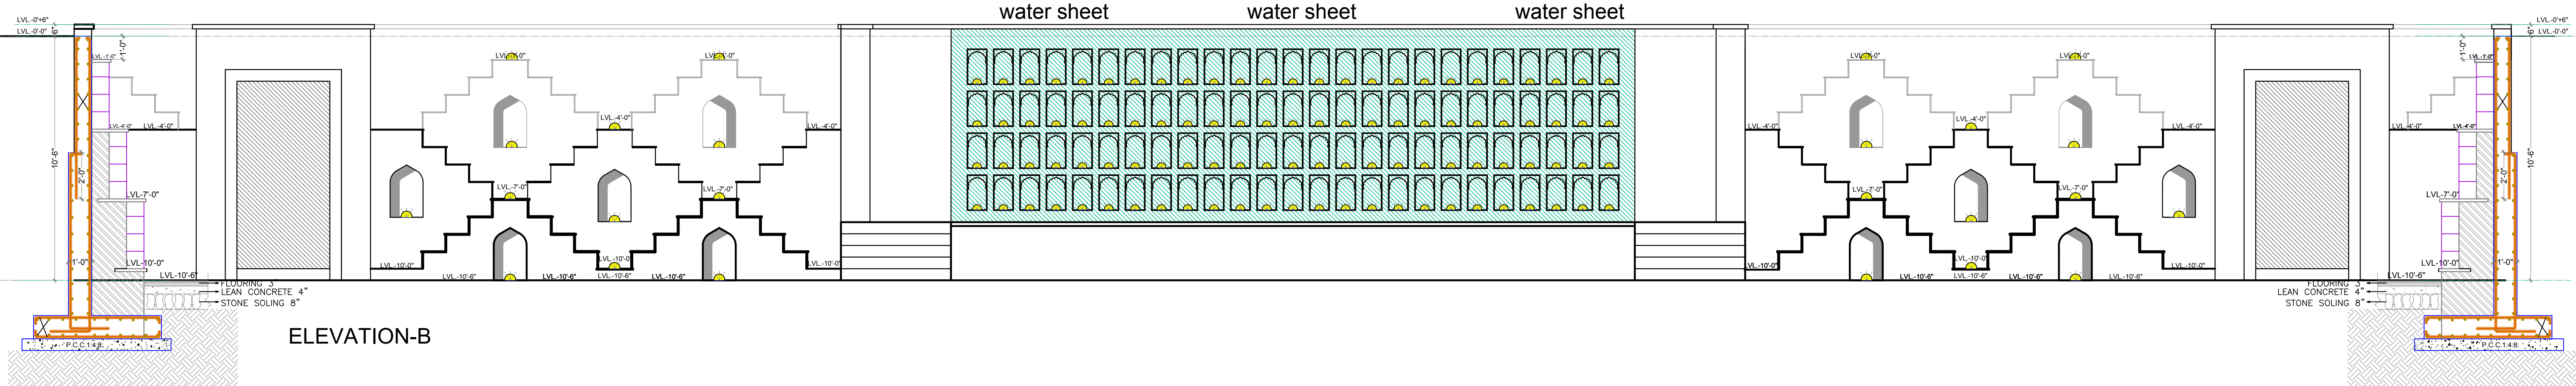

ELEVATION-B

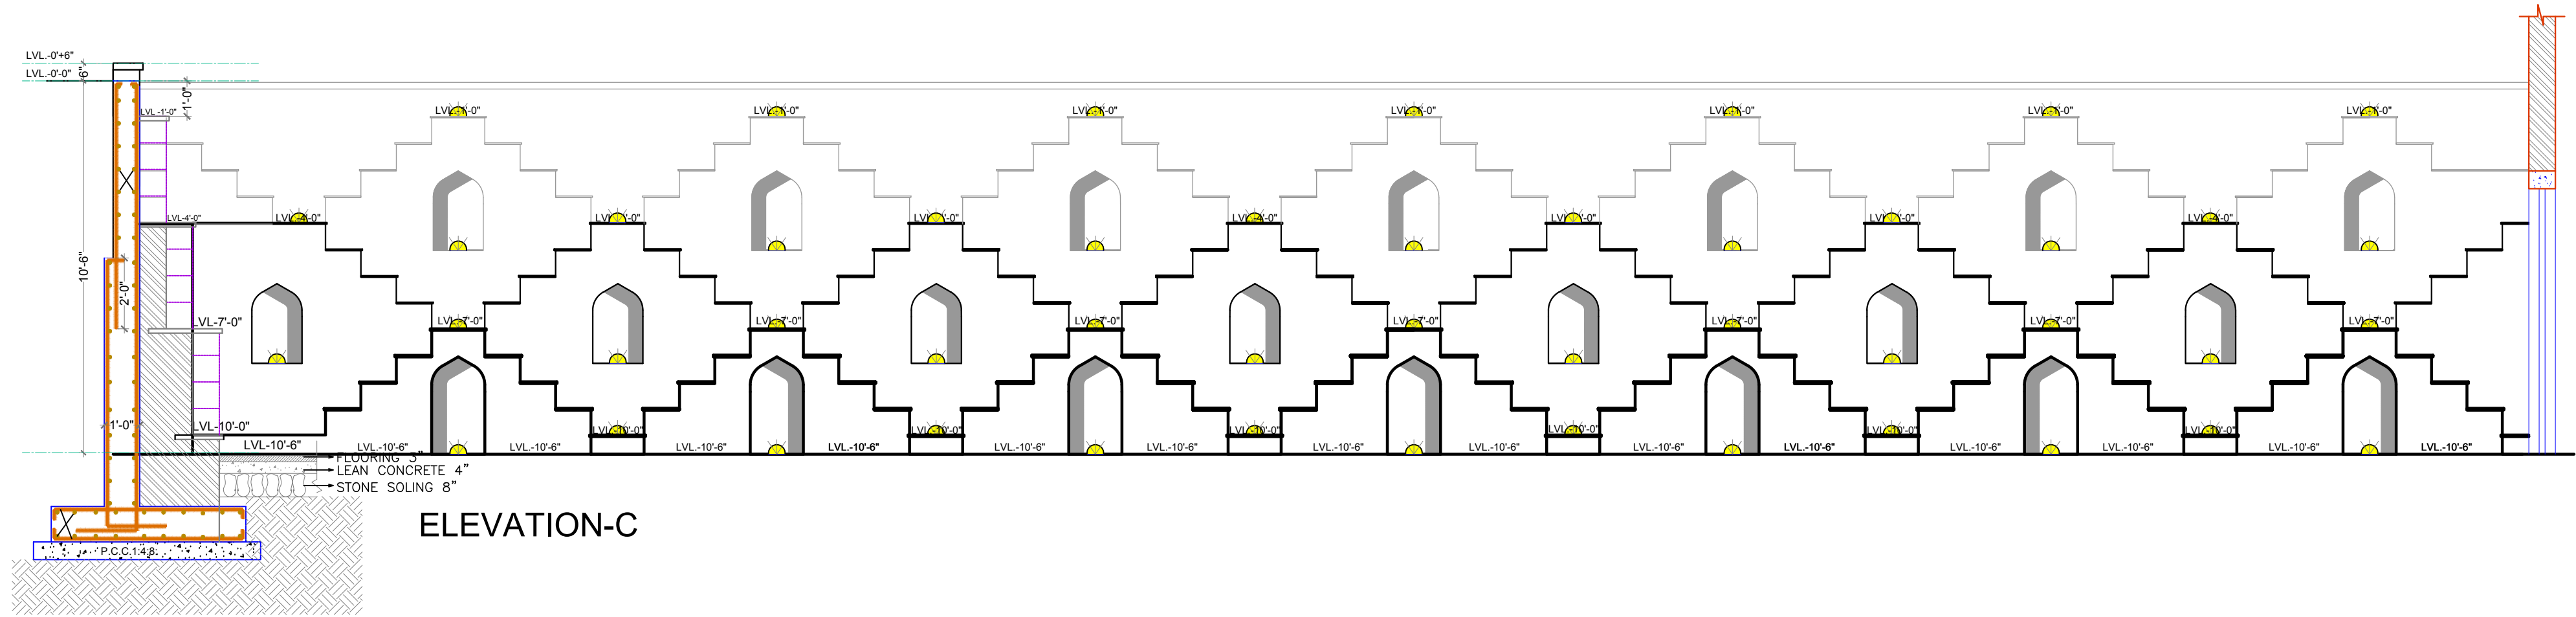

ELEVATION-C

ARCHITECT:
NEERAV GUPTA
L-1, KRISHNA MARG, C-SCHEME,
JAIPUR (302001), RAJASTHAN
PH:0141-236633
E-Mail:architect_neeravgupta@yahoo.com

PROJECT:
CLARKS

DRAWING TITLE:
BAWADI WALL
ELECTRICAL PLAN ELEVATION

DRAWN BY: **RAHUL** SCALE: **N.T.S.** DATE: **02-03-2019**

CHECKED BY: **NEERAV GUPTA** NORTH:  SHEET: **04**

NOTES:
THE COPYRIGHT AND PROPERTY OF THIS DESIGN AND DRAWING
BELONGS TO NEERAV GUPTA. IT MUST NOT BE COPIED OR
REPRODUCED IN ANY MANNER WITHOUT THEIR WRITTEN
CONSENT. A LITIGAL ACTION AS PER LAW MAY BE INITIATED
AGAINST THE OFFENDERS.