


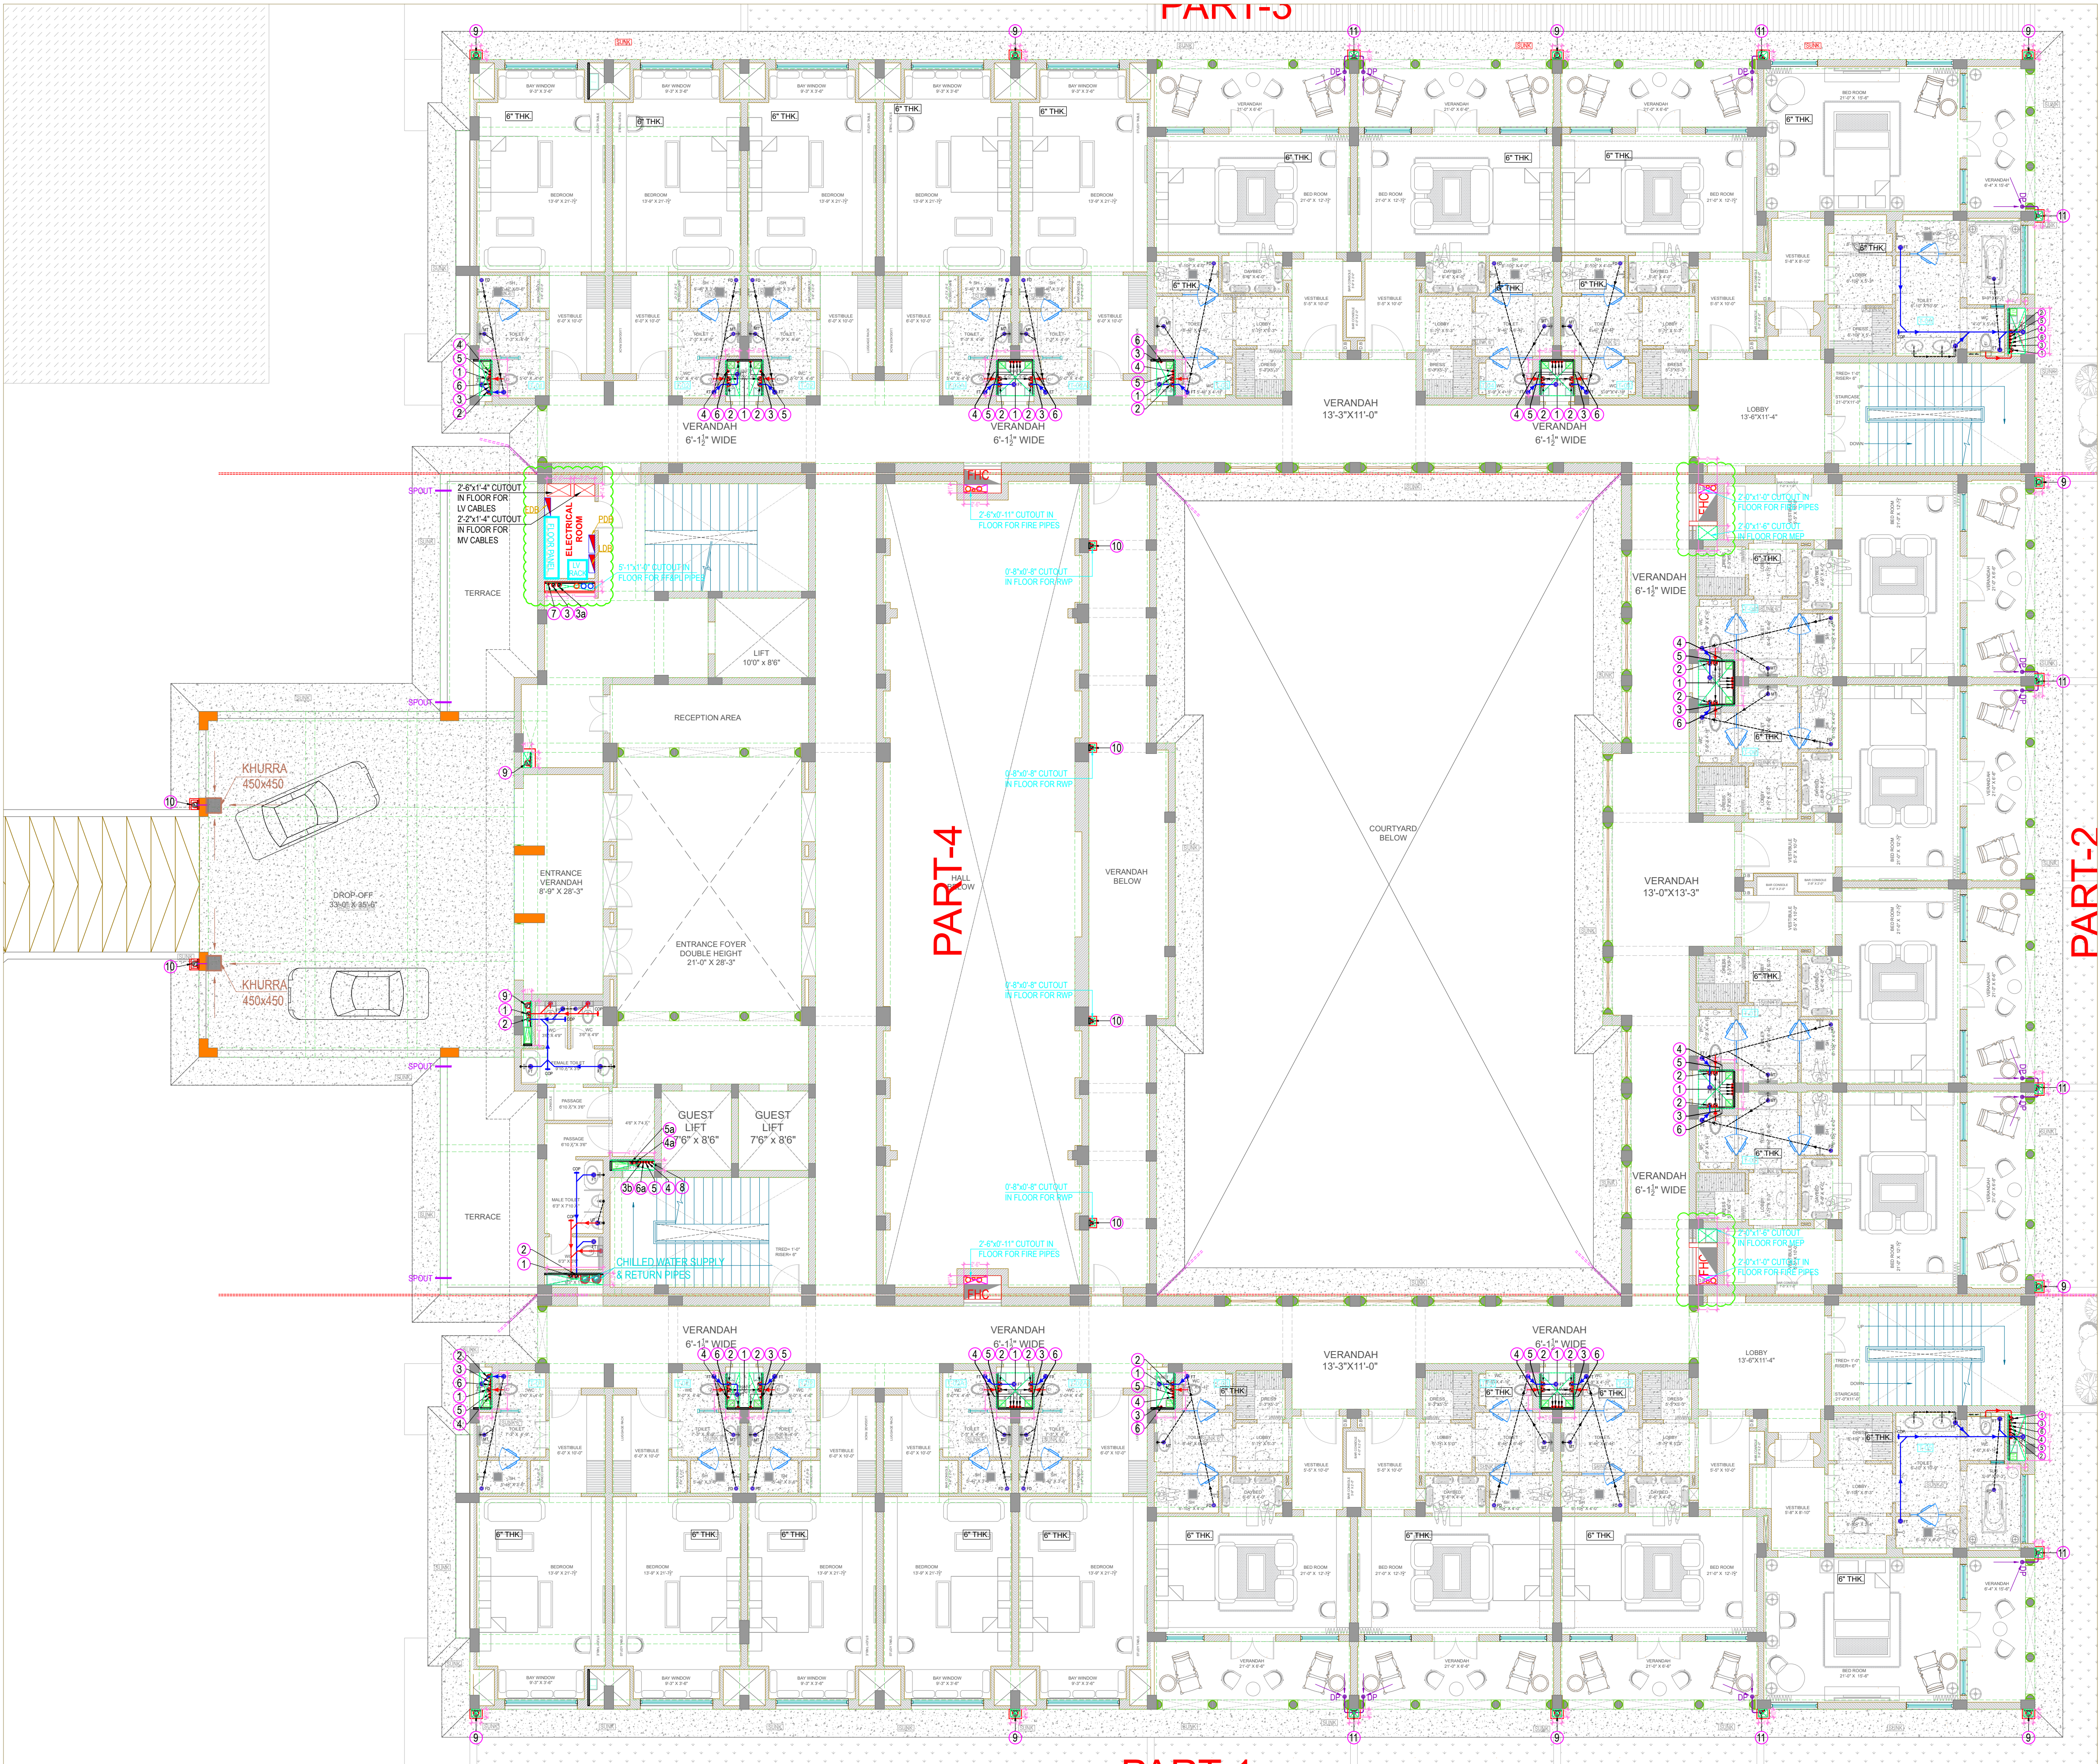

NOTE:- ALL PIPE DIAMETER, MANHOLE SIZES, GULLY TRAP, CHAMBER, MEP PLANTS ETC. SHOWN IN MM FOR PLUMBING AND FIRE FIGHTING WORKS (EXCEPT SHAFT SIZES).

PLUMBING LEGEND	
①	1000 SOIL VERTICAL & VENT PIPE
②	1000 WASTE VERTICAL & VENT PIPE
③	COLD WATER SUPPLY PIPE FROM W.T.P. PLANT ROOM (HYDRO-PNEUMATIC SYSTEM) FOR GR. & 1ST FLOOR
③a	COLD WATER SUPPLY PIPE FROM W.T.P. PLANT ROOM (HYDRO-PNEUMATIC SYSTEM) FOR 2ND & 3RD FLOOR
③b	COLD WATER SUPPLY PIPE TO PUBLIC TOILETS FROM O.H. TANK (BY GRAVITY)
④	HOT WATER SUPPLY PIPE FROM CENTRALISED HOT WATER SYSTEM FOR GR. & 1ST FLOOR
④a	HOT WATER SUPPLY PIPE FROM CENTRALISED HOT WATER SYSTEM FOR 2ND & 3RD FLOOR
⑤	HOT WATER RETURN PIPE TO CENTRALISED HOT WATER SYSTEM FOR GR. & 1ST FLOOR
⑤a	HOT WATER RETURN PIPE TO CENTRALISED HOT WATER SYSTEM FOR 2ND & 3RD FLOOR
⑥	FLUSHING WATER SUPPLY PIPE FROM O.H. TANK FOR GR. & 1ST FLOOR
⑥a	FLUSHING WATER SUPPLY PIPE TO PUBLIC TOILETS FROM O.H. TANK (BY GRAVITY)
⑦	COLD RISER PIPE FOR O.H. TANK FILLING
⑧	FLUSHING RISER PIPE FOR O.H. TANK FILLING
⑨	1500 RAIN WATER VERTICAL PIPE
⑩	1000 RAIN WATER VERTICAL PIPE
⑪	750 RAIN WATER VERTICAL PIPE
→	SOIL PIPE (RUN IN SUNKEN / CEILING)
→	WASTE PIPE (RUN IN SUNKEN / CEILING)
⊠ FT	FLOOR TRAP 100X100MM (P' TRAP) WITH S.S GRATING
● FD	FLOOR DRAIN (100X50MM) WITH S.S GRATING
WB TO FT	320 WASTE PIPE
FD TO FT	500 / 650 WASTE PIPE
FT TO MAIN PIPE	1000 WASTE PIPE
UT TO MAIN PIPE	1000 SOIL PIPE
WC TO MAIN PIPE	1000 SOIL PIPE

NOTE:- ALL PIPE DIAMETER, MANHOLE SIZES, GULLY TRAP, CHAMBER, MEP PLANTS ETC. SHOWN IN MM

GOOD FOR CONSTRUCTION
(ADVANCE COPY)

REVISION NO.- R1

MEPF
NEWTECH CONSULTING ENGINEERS
C-137/1, 3rd Floor, Vijay Vihar Phase - II
(Rohini Sec.-1), New Delhi - 110085, (India)

ARCHITECT:
RAVI KUMAR GUPTA
CA/83/7739
L-1, KRISHNA MARG, C- SCHEME,
JAIPUR (302001), RAJASTHAN.
PH.0141-2360825 E-Mail-ravigupta_15@yahoo.com

DRAWING TITLE:
**1ST FLOOR PLAN
(PLUMBING LAYOUT)**

PROJECT:
LAXMI PALACE / HOTEL

DRAWN BY:	NORTH:	DATE:
SONU KUMAR		20-03-2024
CHECKED BY:	DRAWING NO.:	SCALE:
VIJAY KUMAR	PL-02	1:100

NOTES:
THE COPYRIGHT AND PROPERTY OF THIS DESIGN AND DRAWING BELONGS TO **RAVI KUMAR GUPTA**. IT MUST NOT BE COPIED OR REPRODUCED IN ANY MANNER WITHOUT THEIR WRITTEN CONSENT. A LEGAL ACTION AS PER LAW MAY BE INITIATED AGAINST THE OFFENDER. 02

STRUCTURE CO. :
SANRACHANA

1ST FLOOR PLAN