


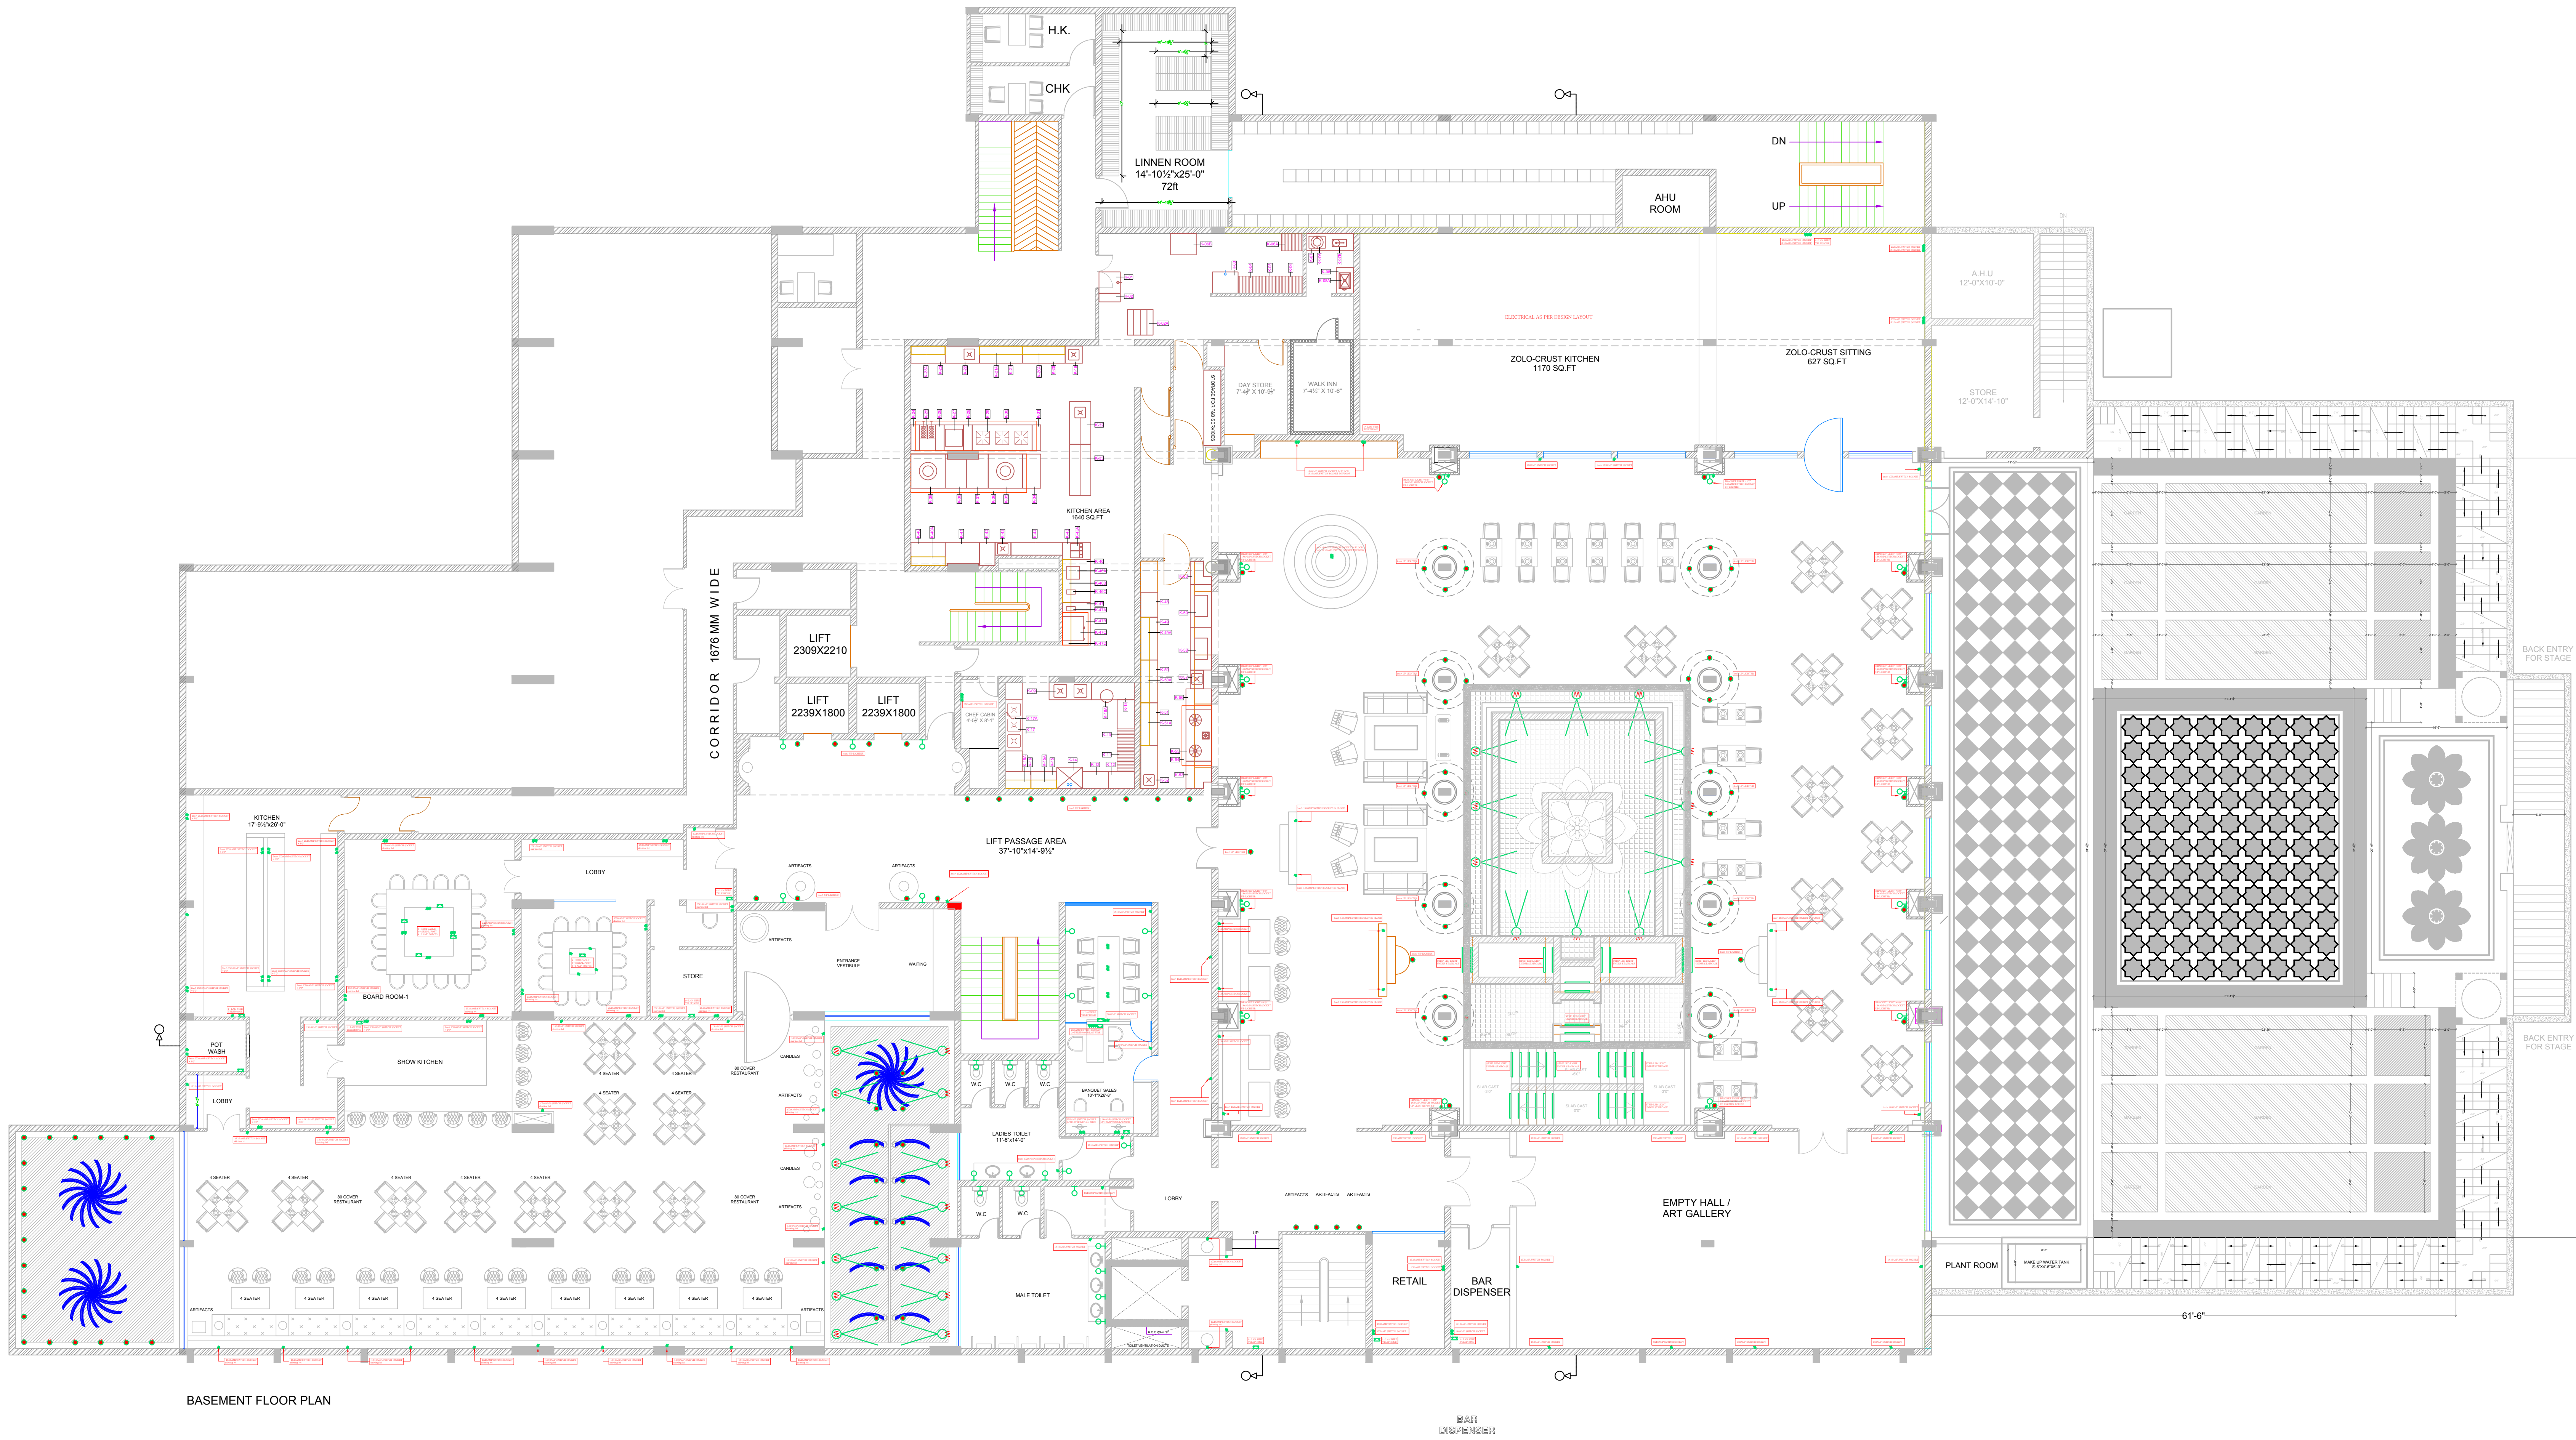

BASEMENT FLOOR PLAN

LEGEND - ELECTRICAL

S.NO.	SYMBOL	DESCRIPTION OF ITEM
1		CHANDWILIER
2		CEILING FAN
3		SWITCH BOARD
4		CEILING LIGHT
5		BRACKET LIGHT H 8" FROM FINISH FLOOR LVL.
6		SWITCH SOCKET 6A.
7		SWITCH SOCKET 15A.
8		ANTENNA
9		TELEPHONE/LINEWIRE
10		EXHAUST FAN
11		DISTRIBUTION BOX
12		TUBE LIGHT
13		PICTURE LIGHT
14		AC POINTS
15		UPLIGHTER

ARCHITECT:
NEERAV GUPTA
L-1, KIRISHNA MARG, C- SCHEME,
JAIPUR (302001), RAJASTHAN.
PH:0141-2368225
E-Mail:architect_neeravgupta@yahoo.com

PROJECT:

CLARKS

DRAWING TITLE:
BASEMENT FLOOR WALL
ELECTRICAL PLAN

DRAWN BY: RAHUL
SCALE: N.T.S.
DATE: 25-08-2017
CHECKED BY: NEERAV GUPTA
SHEET NO.: C/AV/B.F./EL/02

NOTES:
THE COPYRIGHT AND PROPERTY OF THIS DESIGN AND DRAWINGS
BELONGS TO NEERAV GUPTA. IT MUST NOT BE COPIED OR
REPRODUCED IN ANY MANNER WITHOUT THEIR WRITTEN
CONSENT. A LEGAL ACTION AS PER LAW MAY BE INITIATED
AGAINST THE OFFENDER.