


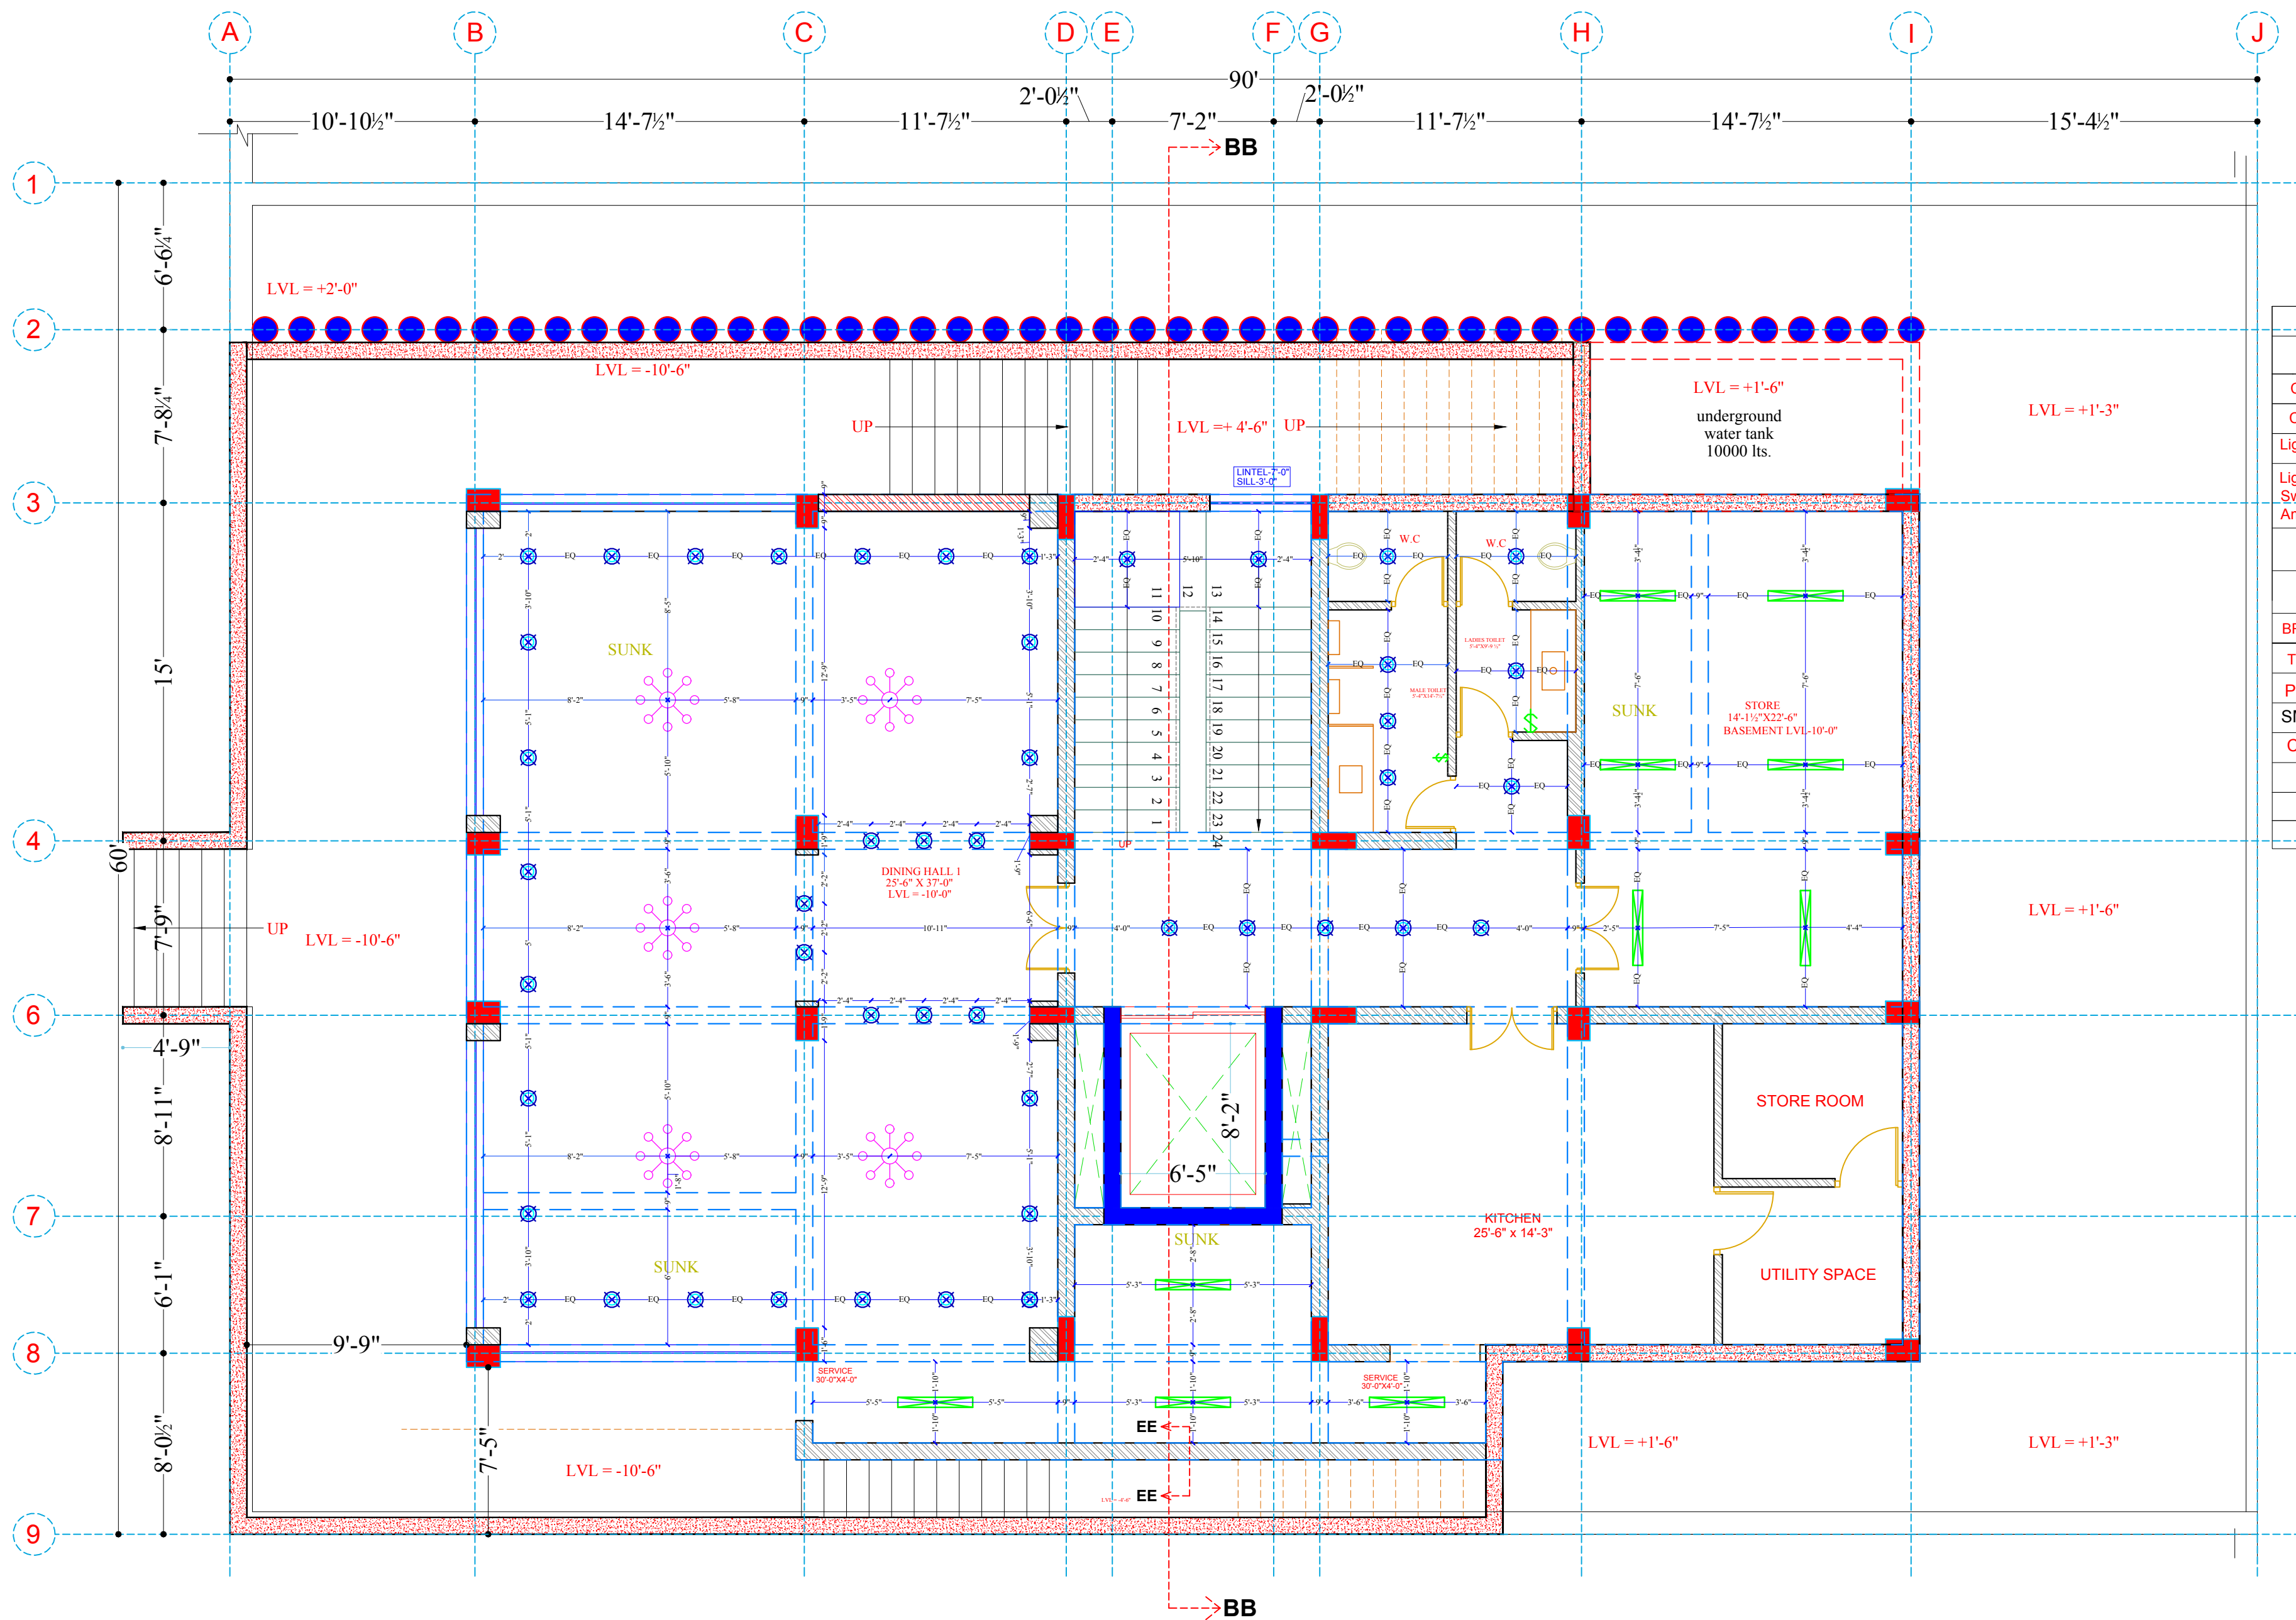

Legend:			
Description	Symbol	Symbol	Height from FFL
Ceiling Light			Ceiling
Chandelier Light			Ceiling
Light Switch Board @ 4'-0"		SB-A	AS PER INTERIORS
Light & Fan Regulator Switch Board With 6 Amp Socket @ 4'-0"		SB-B	AS PER INTERIORS
6 Amp Switch/Socket @ SKIRTING			BOTTOM OF SKIRTING LVL
SWITCH SOCKET 16A			BOTTOM OF SKIRTING LVL
BRACKET LIGHT +7'-0"			7'
TUBE LIGHT			Ceiling
PENDENT SPRINKLER			Ceiling
SMOKE DETECTOR			Ceiling
CEILING SPEAKER			Ceiling
TELEPHONE			3' HT
UPLIGHTER			FLOOR
FOOT LIGHT			BOTTOM OF SKIRTING LVL

BASEMENT FLOOR CEILING ELECTRICAL

ARCHITECT:
NEERAV GUPTA
CA/2009/44766
L-1, KRISHNA MARG, C- SCHEME,
JAIPUR (302001), RAJASTHAN PH 0141-2360825
E-Mail: architect_neeravgupta@yahoo.com

PROJECT:
HOTEL CLARKS

DRAWING TITLE:
**CEILING ELECTRICAL
BASEMENT FLOOR PLAN**

DRAWN BY: RISHABH	SCALE: N.T.S	DATE: 14-08-18
CHECKED BY: NEERAV GUPTA	DRAWING NO.: 30/C/EL/01	

NOTES:
THE COPYRIGHT AND PROPERTY OF THIS DESIGN AND DRAWING BELONGS TO RAVI KUMAR GUPTA. IT MUST NOT BE COPIED OR REPRODUCED IN ANY MANNER WITHOUT THEIR WRITTEN CONSENT. A LEGAL ACTION AS PER LAW MAY BE INITIATED AGAINST THE OFFENDER.