


LEGEND:-

- 1. SOIL PIPE
- 2. WASTE PIPE
- 3. KITCHEN DRAIN PIPE
- 4. P-TRAP
- 5. DRAIN POINT
- 6. COLD WATER SUPPLY
- 7. HOT WATER SUPPLY
- 8. HOT WATER RETURN
- 9. COLD WATER SUPPLY LINE
- 10. HOT WATER SUPPLY LINE
- 11. HOT WATER RETURN
- 12. RO WATER SUPPLY
- 13. ISOLATING VALVE
- 12. FLOOR CLEAN OUT PLUG (FCO)
- 13. CLEAN OUT PLUG (COP)
- 14. MANHOLE FOR SEWER LINE 2'-0" x 2'-0"
- 15. GULLY TRAP 1'-6" x 1'-6"

WATER DRAINAGE PIPE SCHEDULE

PIPE NO.	SIZE	SLOPE
(A)	50Ø	1:90
(B)	75Ø	1:110
(C)	110Ø	1:110
(D)	150Ø	1:200

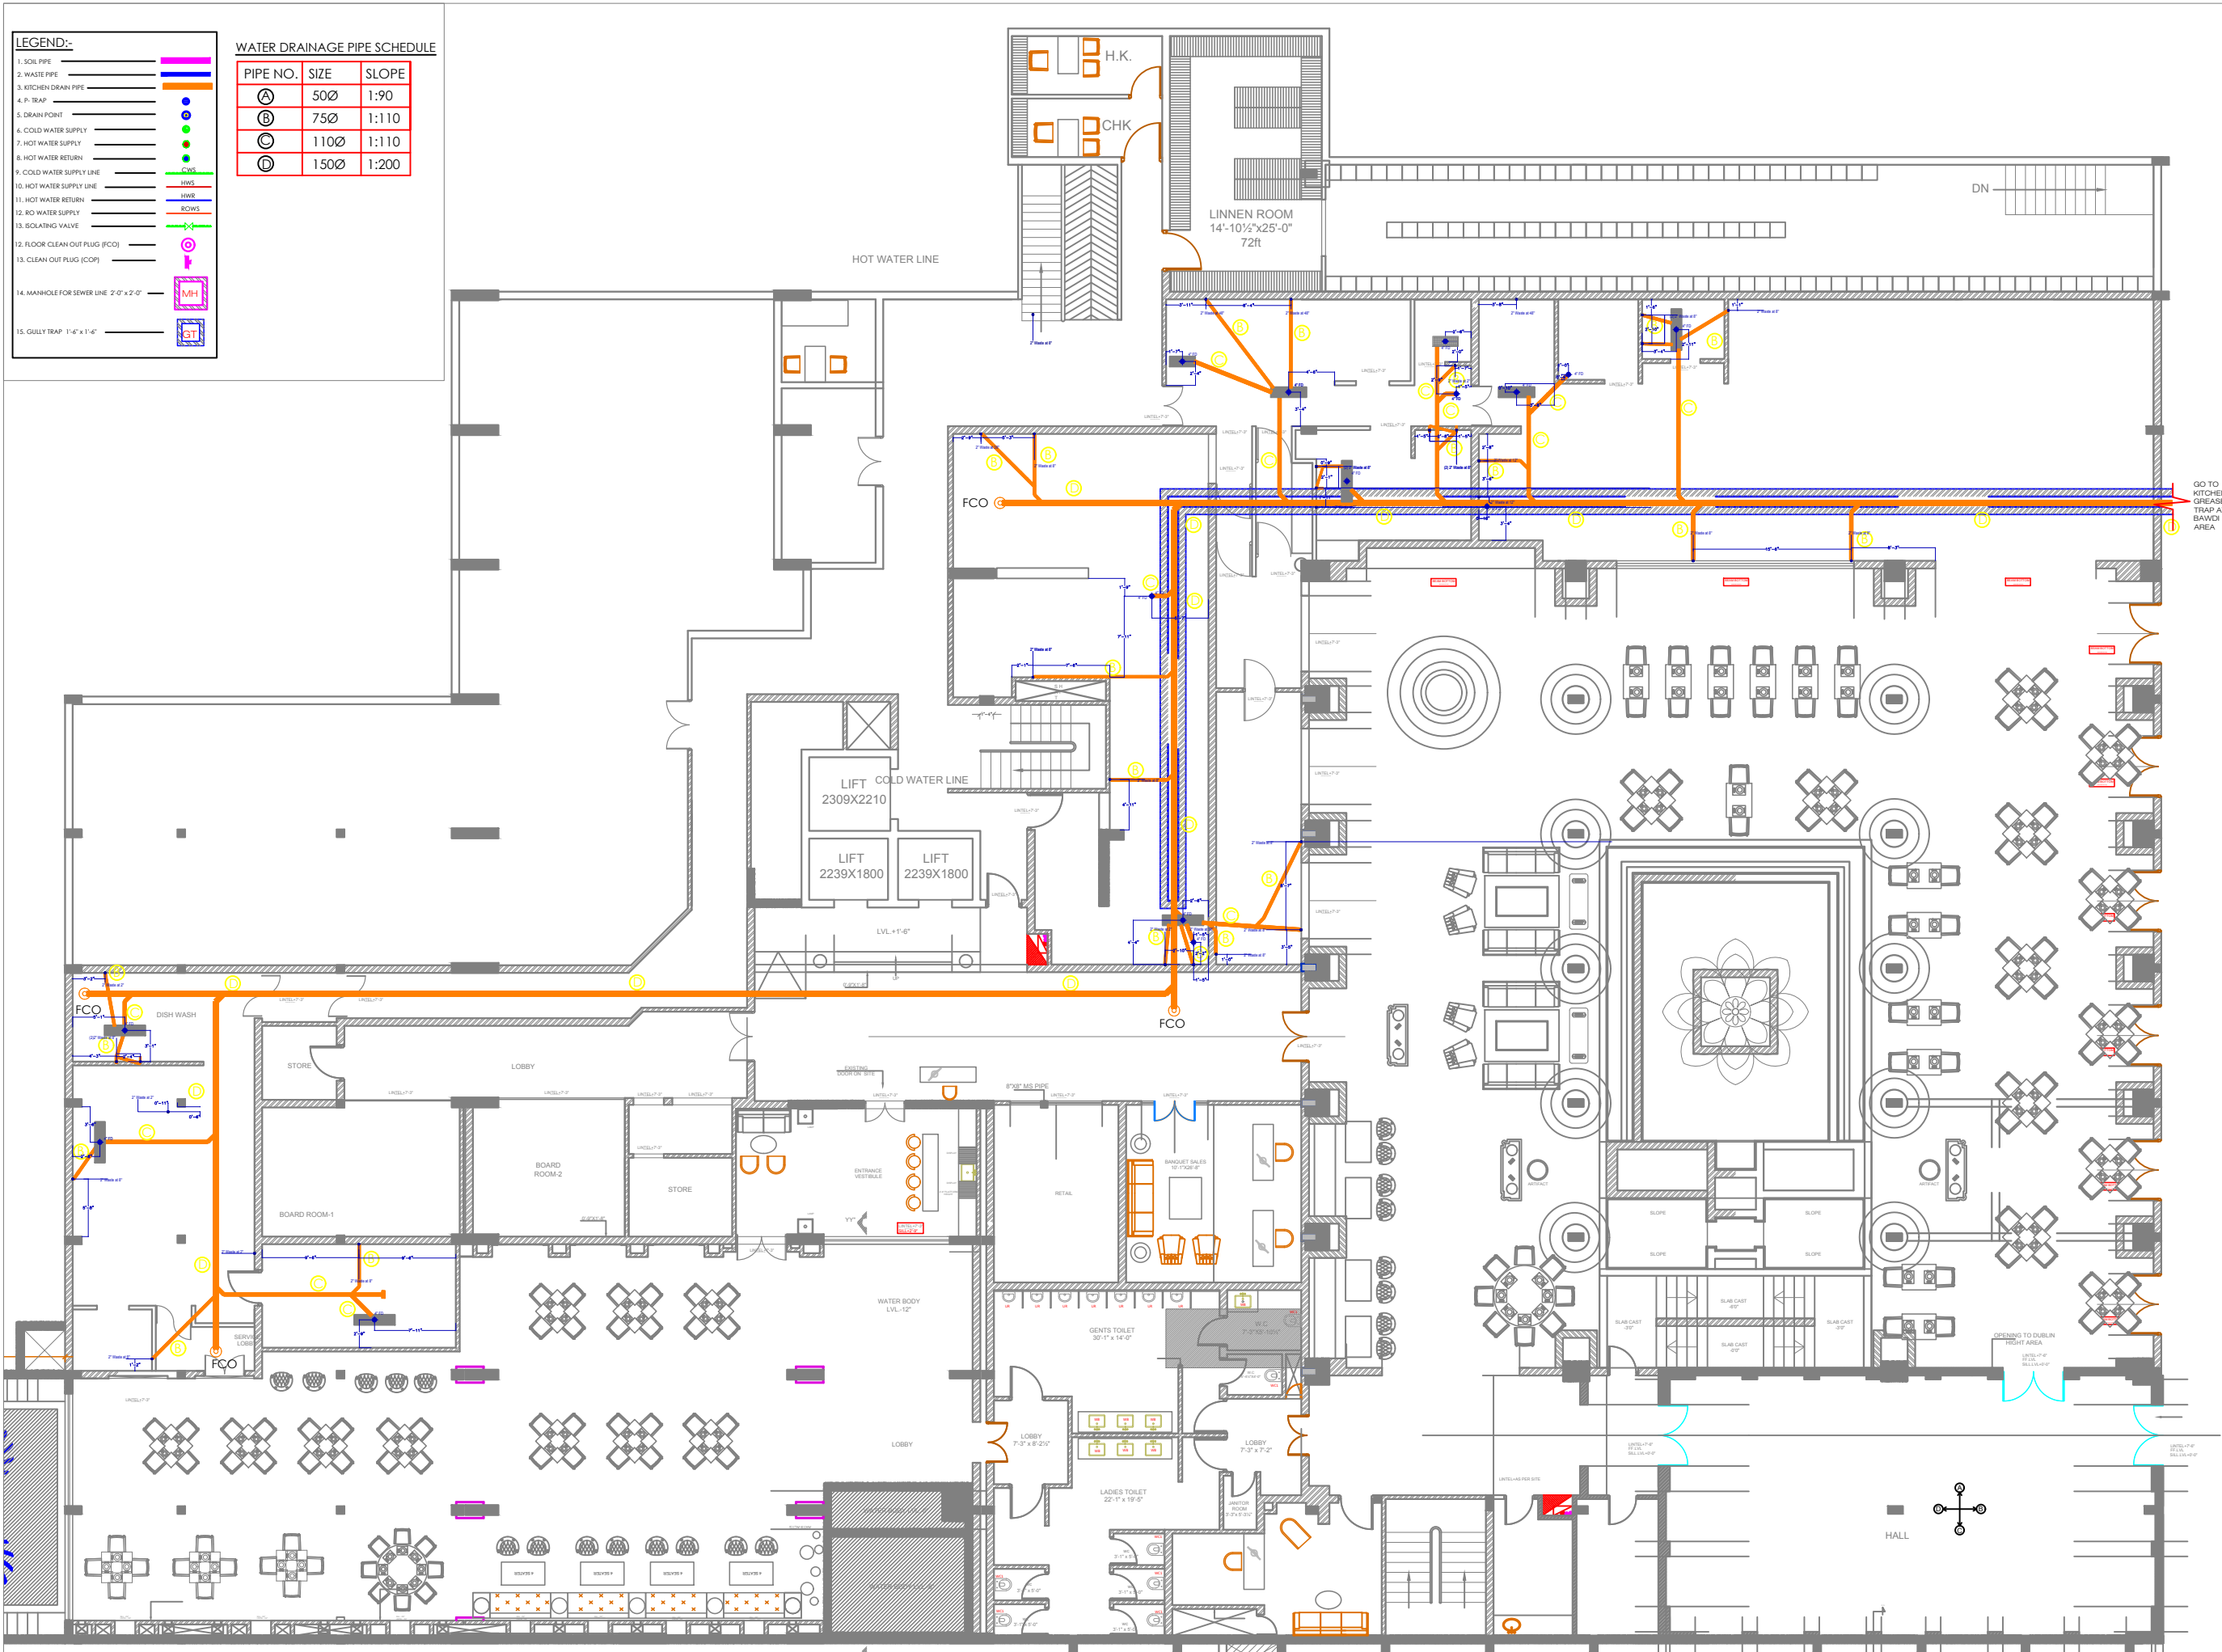

**HOTEL CLARK'S,
LUCKNOW**

ARCHITECTS
NEERAV GUPTA
L-1, KRISHNA MARG, C- SCHEME,
JAIPUR (302001), RAJASTHAN.
PH.0141-2360825
E-Mail- architect_neeravgupta@yahoo.com

**FALAKNUMA , ALL DAY DINNING &
JOLO-CRUST KITCHEN PLUMBING
DRAINAGE LAYOUT**

SCALE: N.T.S.

PROJECT NO:41

DRAWING NO: NG/HCL/KIT/PLU/01A
REVISION NO:01
16.11.2019

SAN ENGINEERS & CONSULTANTS
G-10, KALKAJI MARG, KALKAJI, NEW DELHI-110019.
VATSAL ANAND, RESISTE, TAGORE FARMATION, SEC-10, DELHI.
JAPR/18-30021, +91-11-44-402831
E-mail: info@sanepl.com

ARCHITECT
NEERAV GUPTA
L-1, KRISHNA MARG, C- SCHEME, JAIPUR (302001), RAJASTHAN.
E-Mail- architect_neeravgupta@yahoo.com

PROJECT:
FALAKNUMA , ALL DAY DINNING & JOLO-CRUST KITCHEN PLUMBING DRAINAGE LAYOUT

DRAWING:
REVISED BY: RAHUL
KITCHEN

DRAWN BY:
RAHUL

CHECKED BY:
NEERAV GUPTA

NOTES:
THE COPYRIGHT AND BELONGS TO NEERAV GUPTA. NO PART OF THIS DRAWING CAN BE REPRODUCED OR TRANSMITTED IN ANY FORM OR BY ANY MEANS, ELECTRONIC OR MECHANICAL, WITHOUT PERMISSION IN WRITING FROM THE ARCHITECT.