


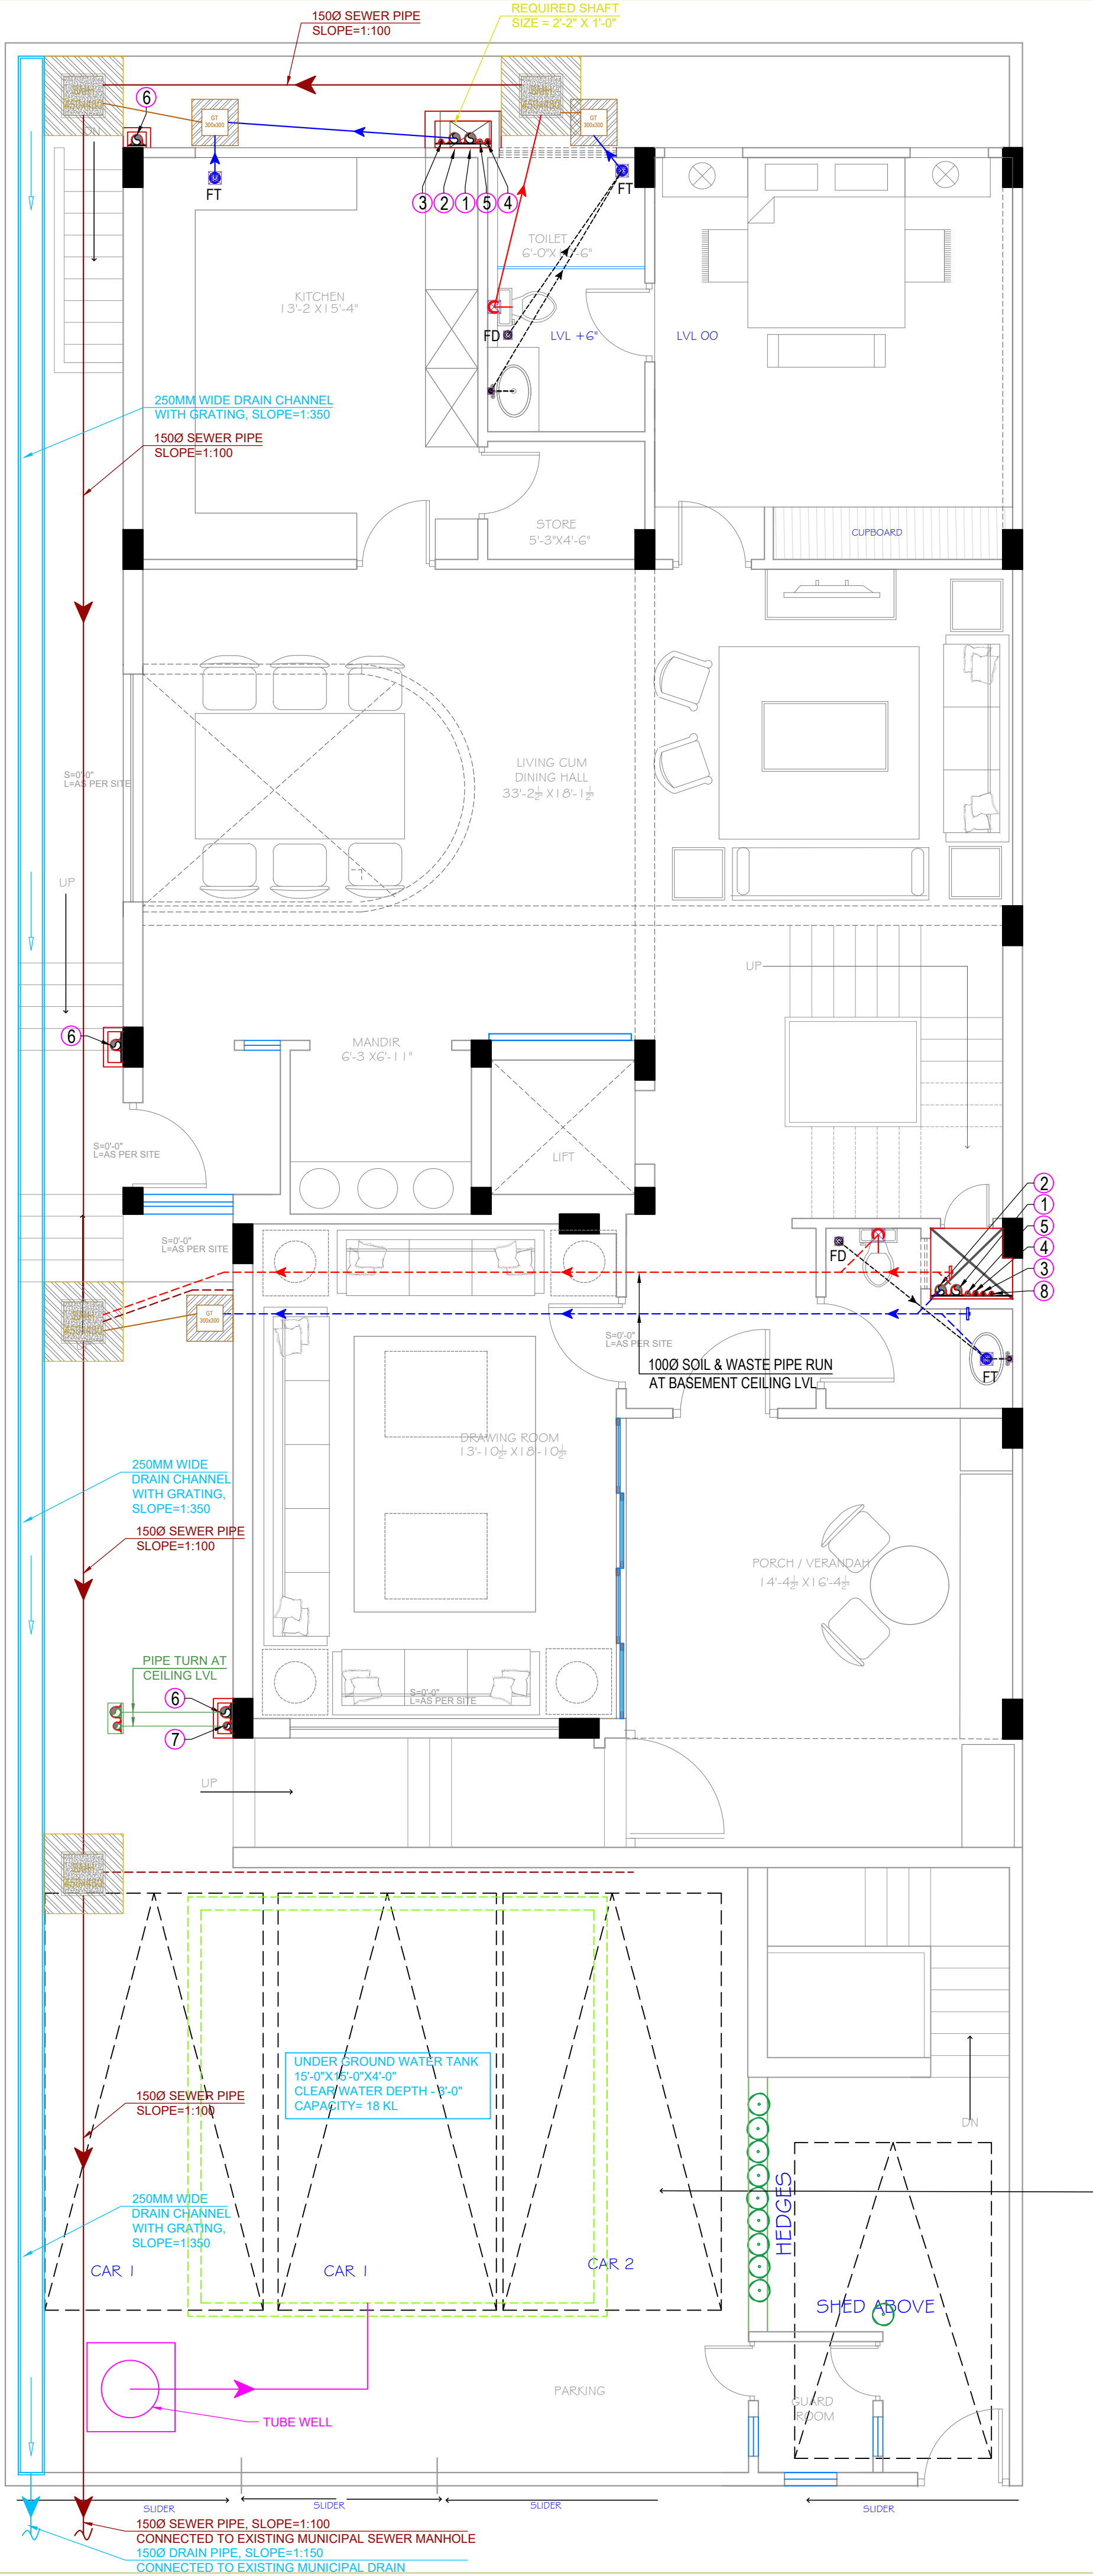

PLUMBING LEGEND	
①	1000 SOIL VERTICAL & VENT PIPE
②	1000 WASTE VERTICAL & VENT PIPE
③	COLD WATER SUPPLY PIPE FROM O.H. TANK (BY BOOSTER PUMP)
④	HOT WATER SUPPLY PIPE FROM CENTRALISED HOT WATER SYSTEM
⑤	HOT WATER RETURN PIPE TO CENTRALISED HOT WATER SYSTEM
⑥	1000 RAIN WATER FROM TERRACE
⑦	750 RAIN WATER FROM BALCONY
⑧	DOMESTIC WATER SUPPLY RISER PIPE FOR O.H. TANK FILLING
	SOIL PIPE (RUN IN SUNKEN / CEILING)
	WASTE PIPE (RUN IN SUNKEN / CEILING)
	FLOOR TRAP 100X100mm (uPVC 'P' OR 'S' TRAP) WITH S.S GRATING
	FLOOR DRAIN (100X50mm) WITH S.S GRATING
WB TO FT	320 WASTE PIPE
FD TO FT	500 WASTE PIPE
FT TO MAIN PIPE	1000 WASTE PIPE
WC TO MAIN PIPE	1000 SOIL PIPE

ARCHITECT:
NEERAV GUPTA
CA/2009/44766
L-1, KRISHNA MARG, C- SCHEME,
JAIPUR (302001), RAJASTHAN.PH.0141-2360825
E-Mail-architect_neeravgupta@yahoo.com

PROJECT:
**FATHEPURIA
RESIDENCE**

DRAWING TITLE:
**GROUND FLOOR
PLUMBING**

DRAWN BY:	SCALE:	DATE:
PRIYANK	N.T.S	11-12-21
CHECKED BY:	DRAWING NO.:	
NEERAV GUPTA		

NOTES:
THE COPYRIGHT AND PROPERTY OF THIS DESIGN AND DRAWING
BELONGS TO **RAVI KUMAR GUPTA**. IT MUST NOT BE COPIED OR
REPRODUCED IN ANY MANNER WITHOUT THEIR WRITTEN
CONSENT. A LEGAL ACTION AS PER LAW MAY BE INITIATED
AGAINST THE OFFENDER.