


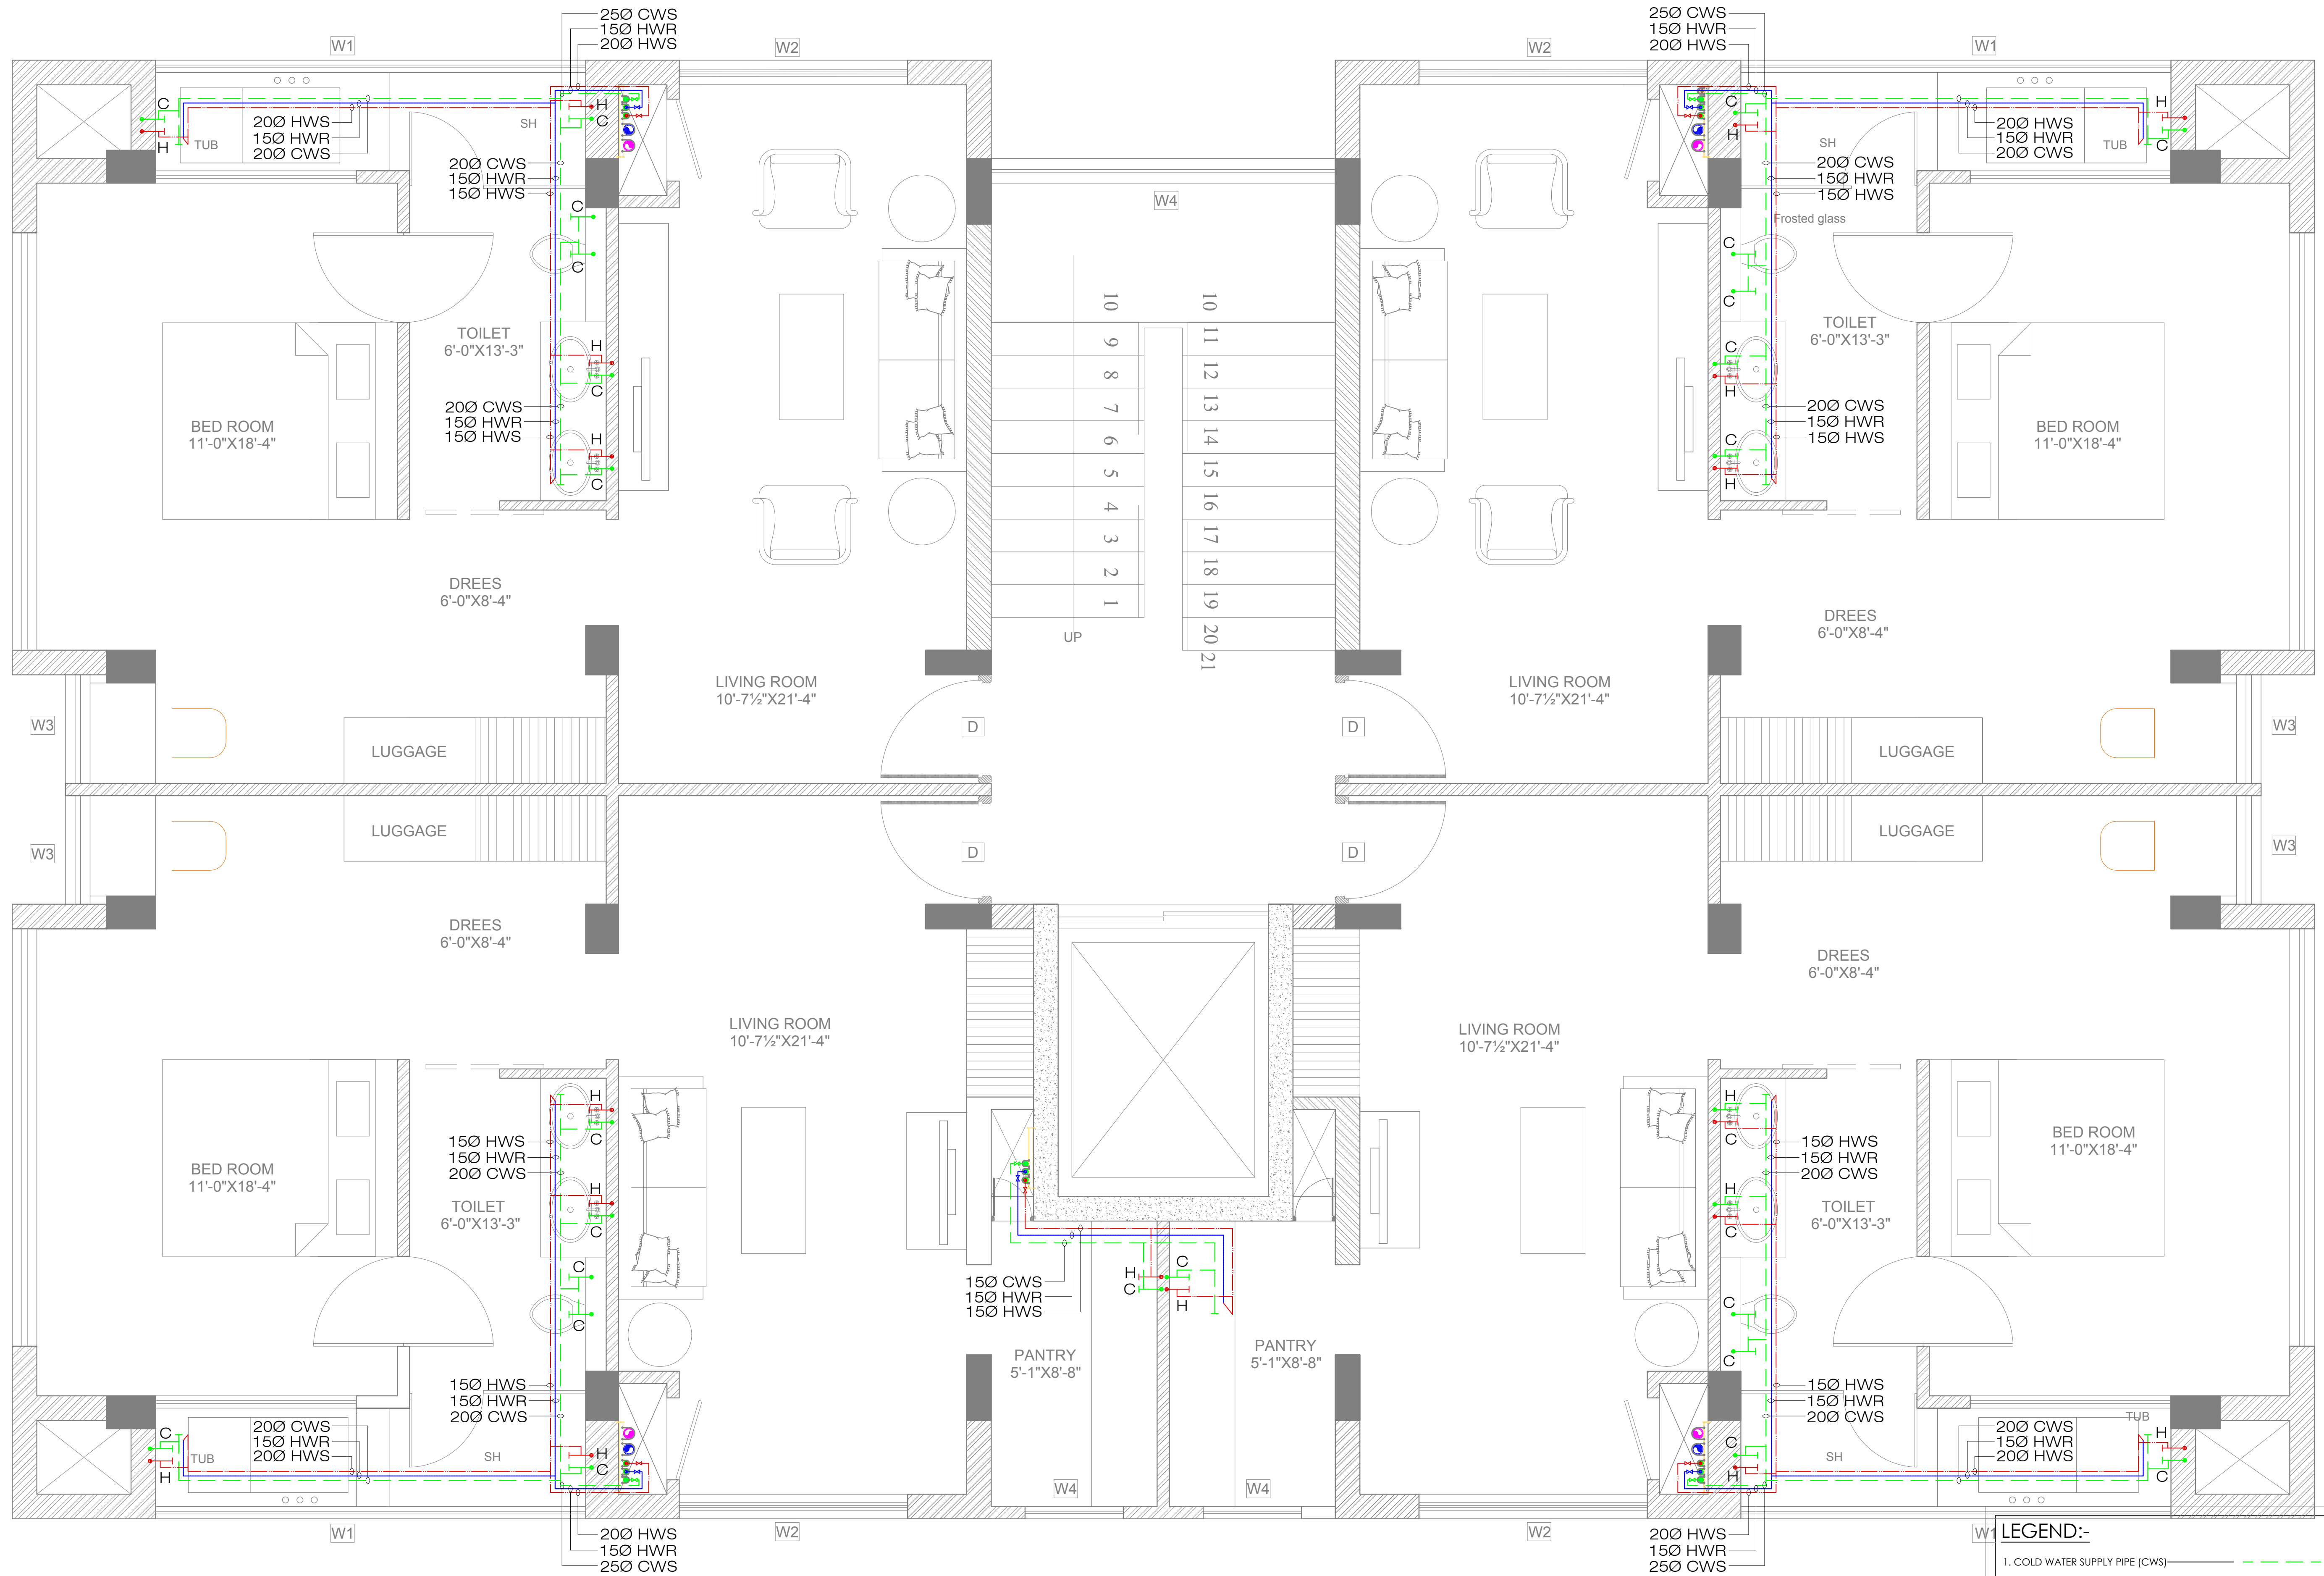

(R-12)-REVISED TYPICAL FLOOR PLAN  
DATE-22-12-2018

**LEGEND:-**

- 1. COLD WATER SUPPLY PIPE (CWS) ————
- 2. HOT WATER SUPPLY PIPE (HWS) ————
- 3. HOT WATER RETURN PIPE (HWR) ————
- 4. IRRIGATION WATER SUPPLY PIPE (IWS) ————
- 5. ISOLATING VALVE ————


HOTEL CLARKS,  
JAIPUR

ARCHITECTS  
**NEERAV GUPTA**  
L-1, KRISHNA MARG, C- SCHEME,  
JAIPUR (302001), RAJASTHAN.  
PH.0141-2360825  
E-Mail- architect\_neeravgupta@yahoo.com

TYPICAL GUEST FLOOR  
PLUMBING WATER SUPPLY  
LAYOUT

SCALE: N.T.S.

PROJECT NO-42  
DRAWING NO-  
NGHC/PLU/03A  
REVISION NO-  
12.02.2019

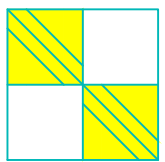  
**SAN ENGINEERS & CONSULTANTS**  
G-2, 1055, CHITRAKOOT SCHEME, NEAR PRATAP STADIUM,  
OPPOSITE TAGORE FOUNDATION SCHOOL, VAISHALI NAGAR,  
JAIPUR-302015  
E-mail- info@sancpl.com