


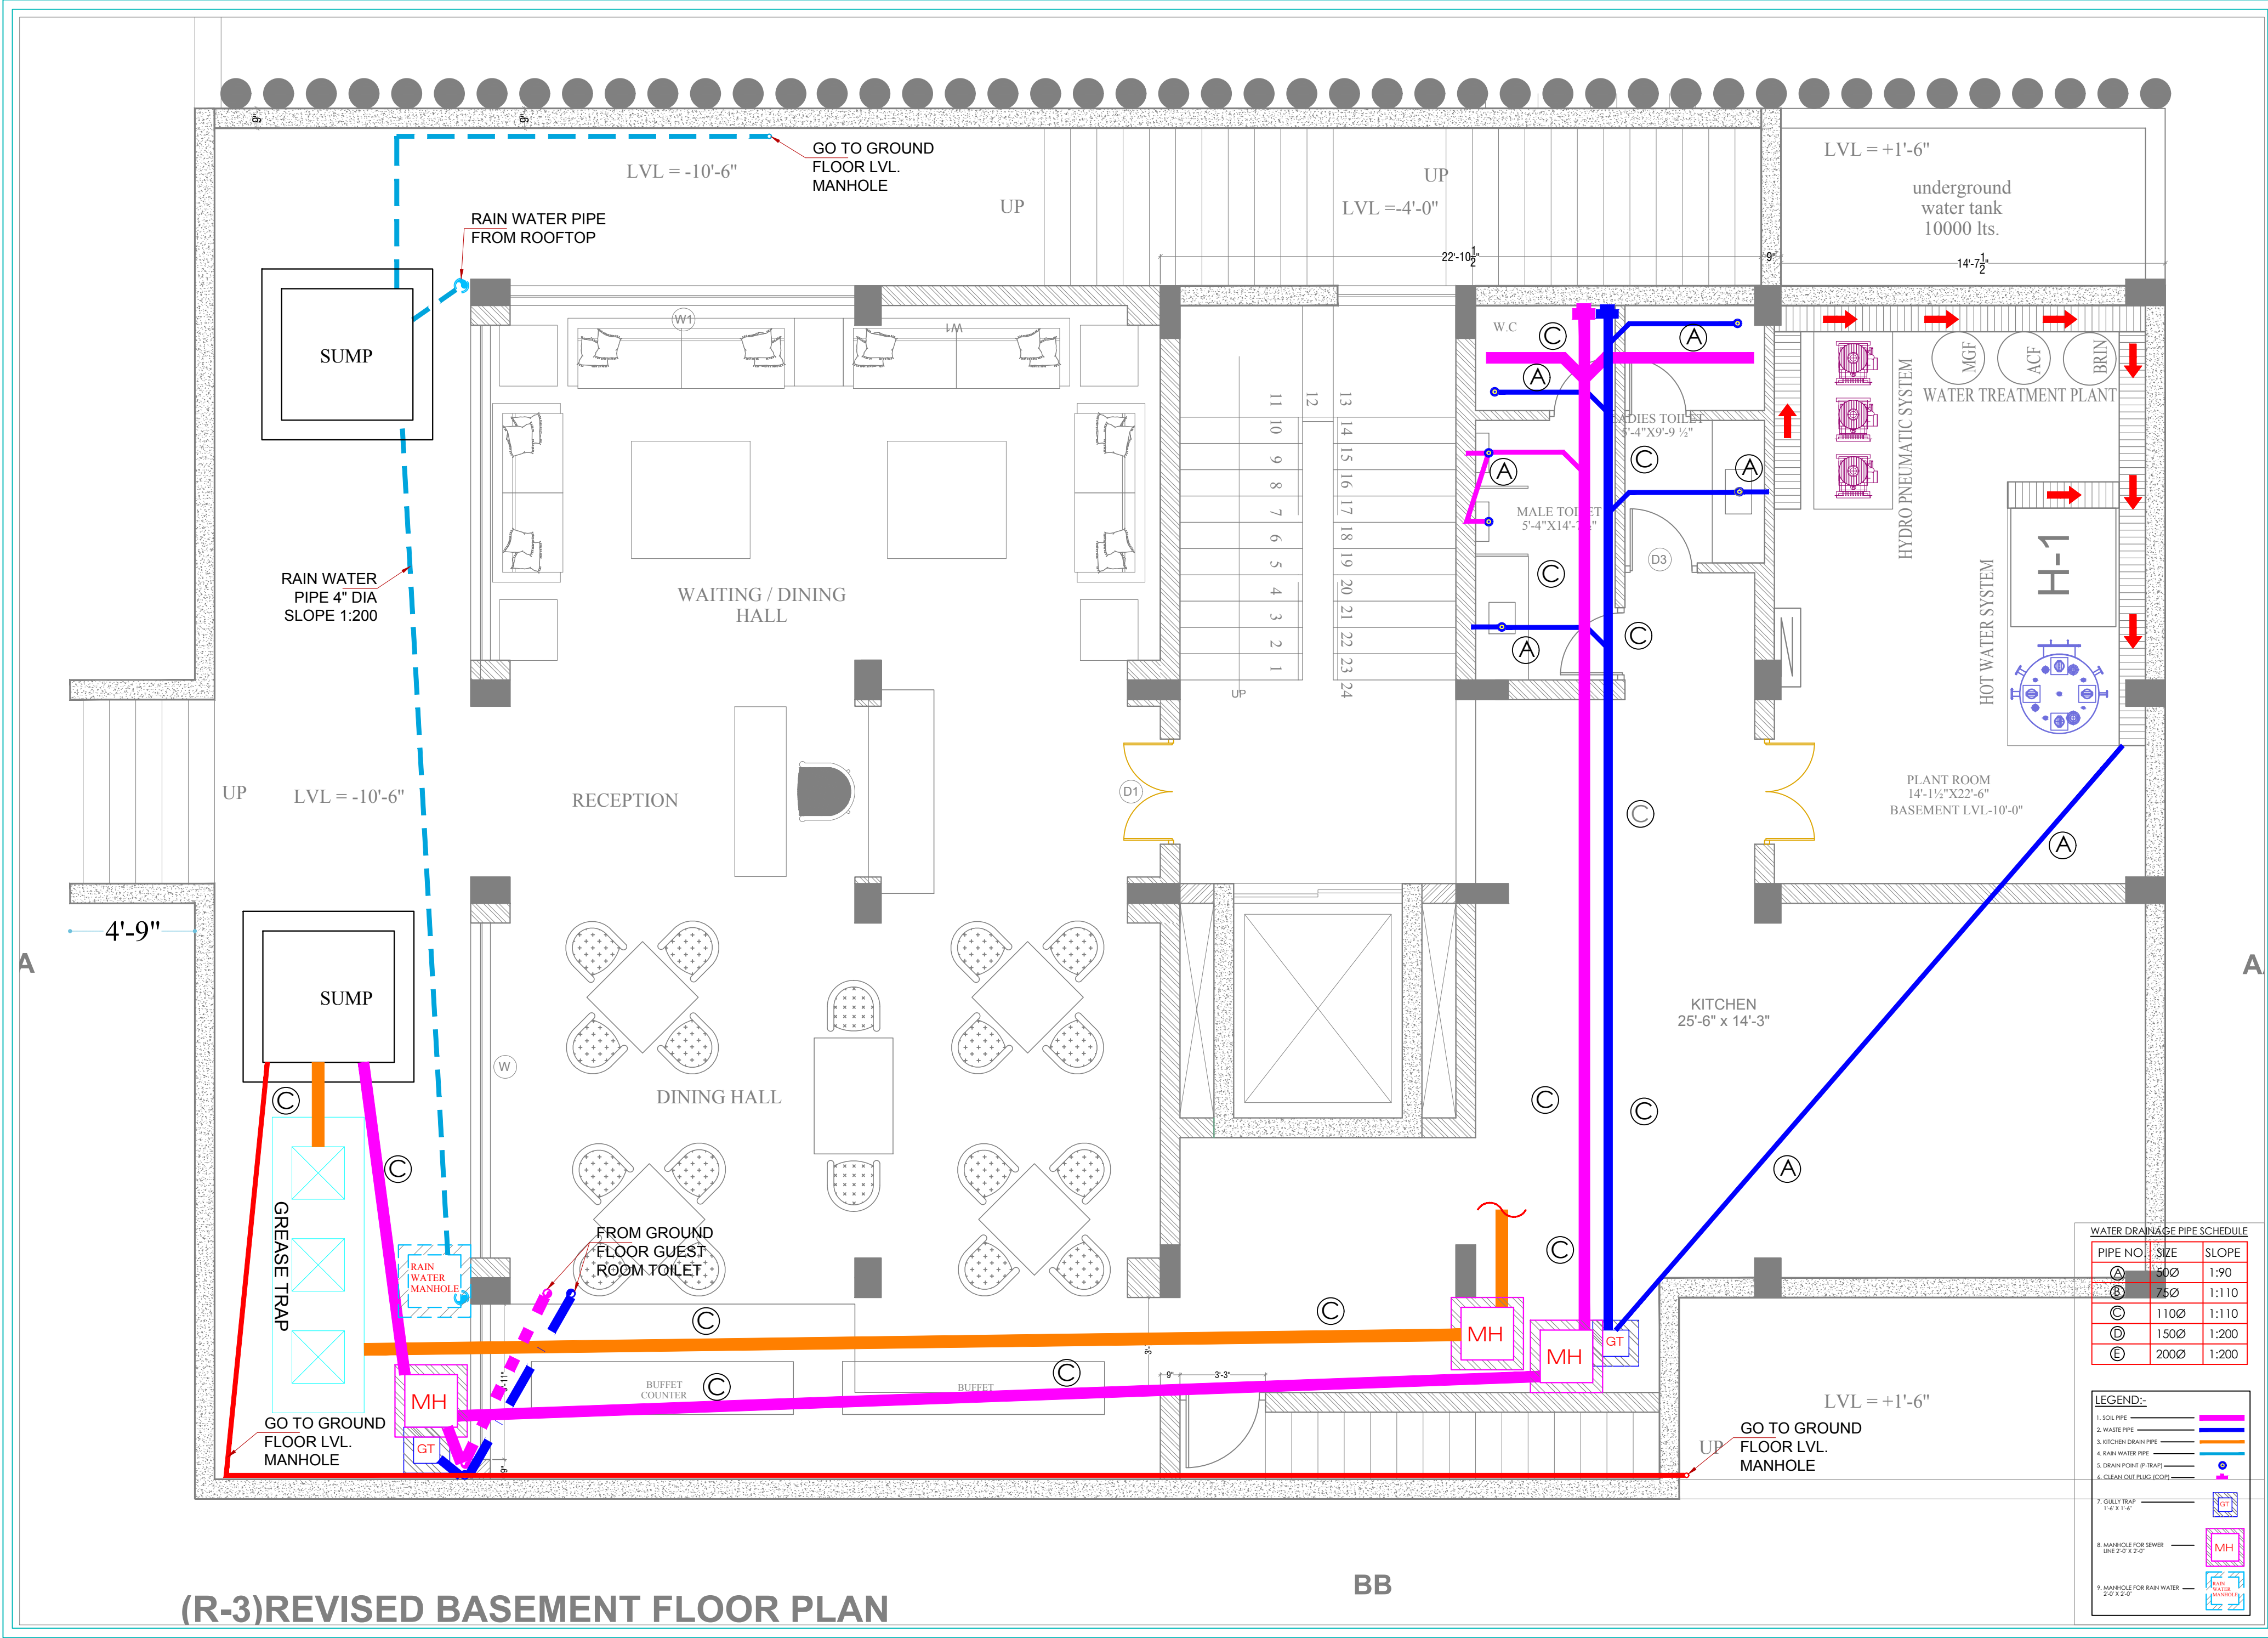

(R-3)REVISED BASEMENT FLOOR PLAN

**HOTEL CLARKS,
JAIPUR**

ARCHITECTS
NEERAV GUPTA
L-1, KRISHNA MARG, C- SCHEME,
JAIPUR (302001), RAJASTHAN.
PH.0141-2360825
E-Mail- architect_neeravgupta@yahoo.com

**BASEMENT FLOOR
PLUMBING DRAINAGE
LAYOUT**

SCALE: N.T.S.

PROJECT NO.42
DRAWING NO:
NGHCIP/L/01
REVISION NO.02
03.01.2019

SAN ENGINEERS & CONSULTANTS
G-2, 1855, GATEWAY FOUNDATION SCHOOL, NEAR PRATAP STADIUM,
OPPOSITE TAGORE FOUNDATION SCHOOL, VAISHALI NAGAR,
JAIPUR - 302021
E-mail: info@sanecsl.com