


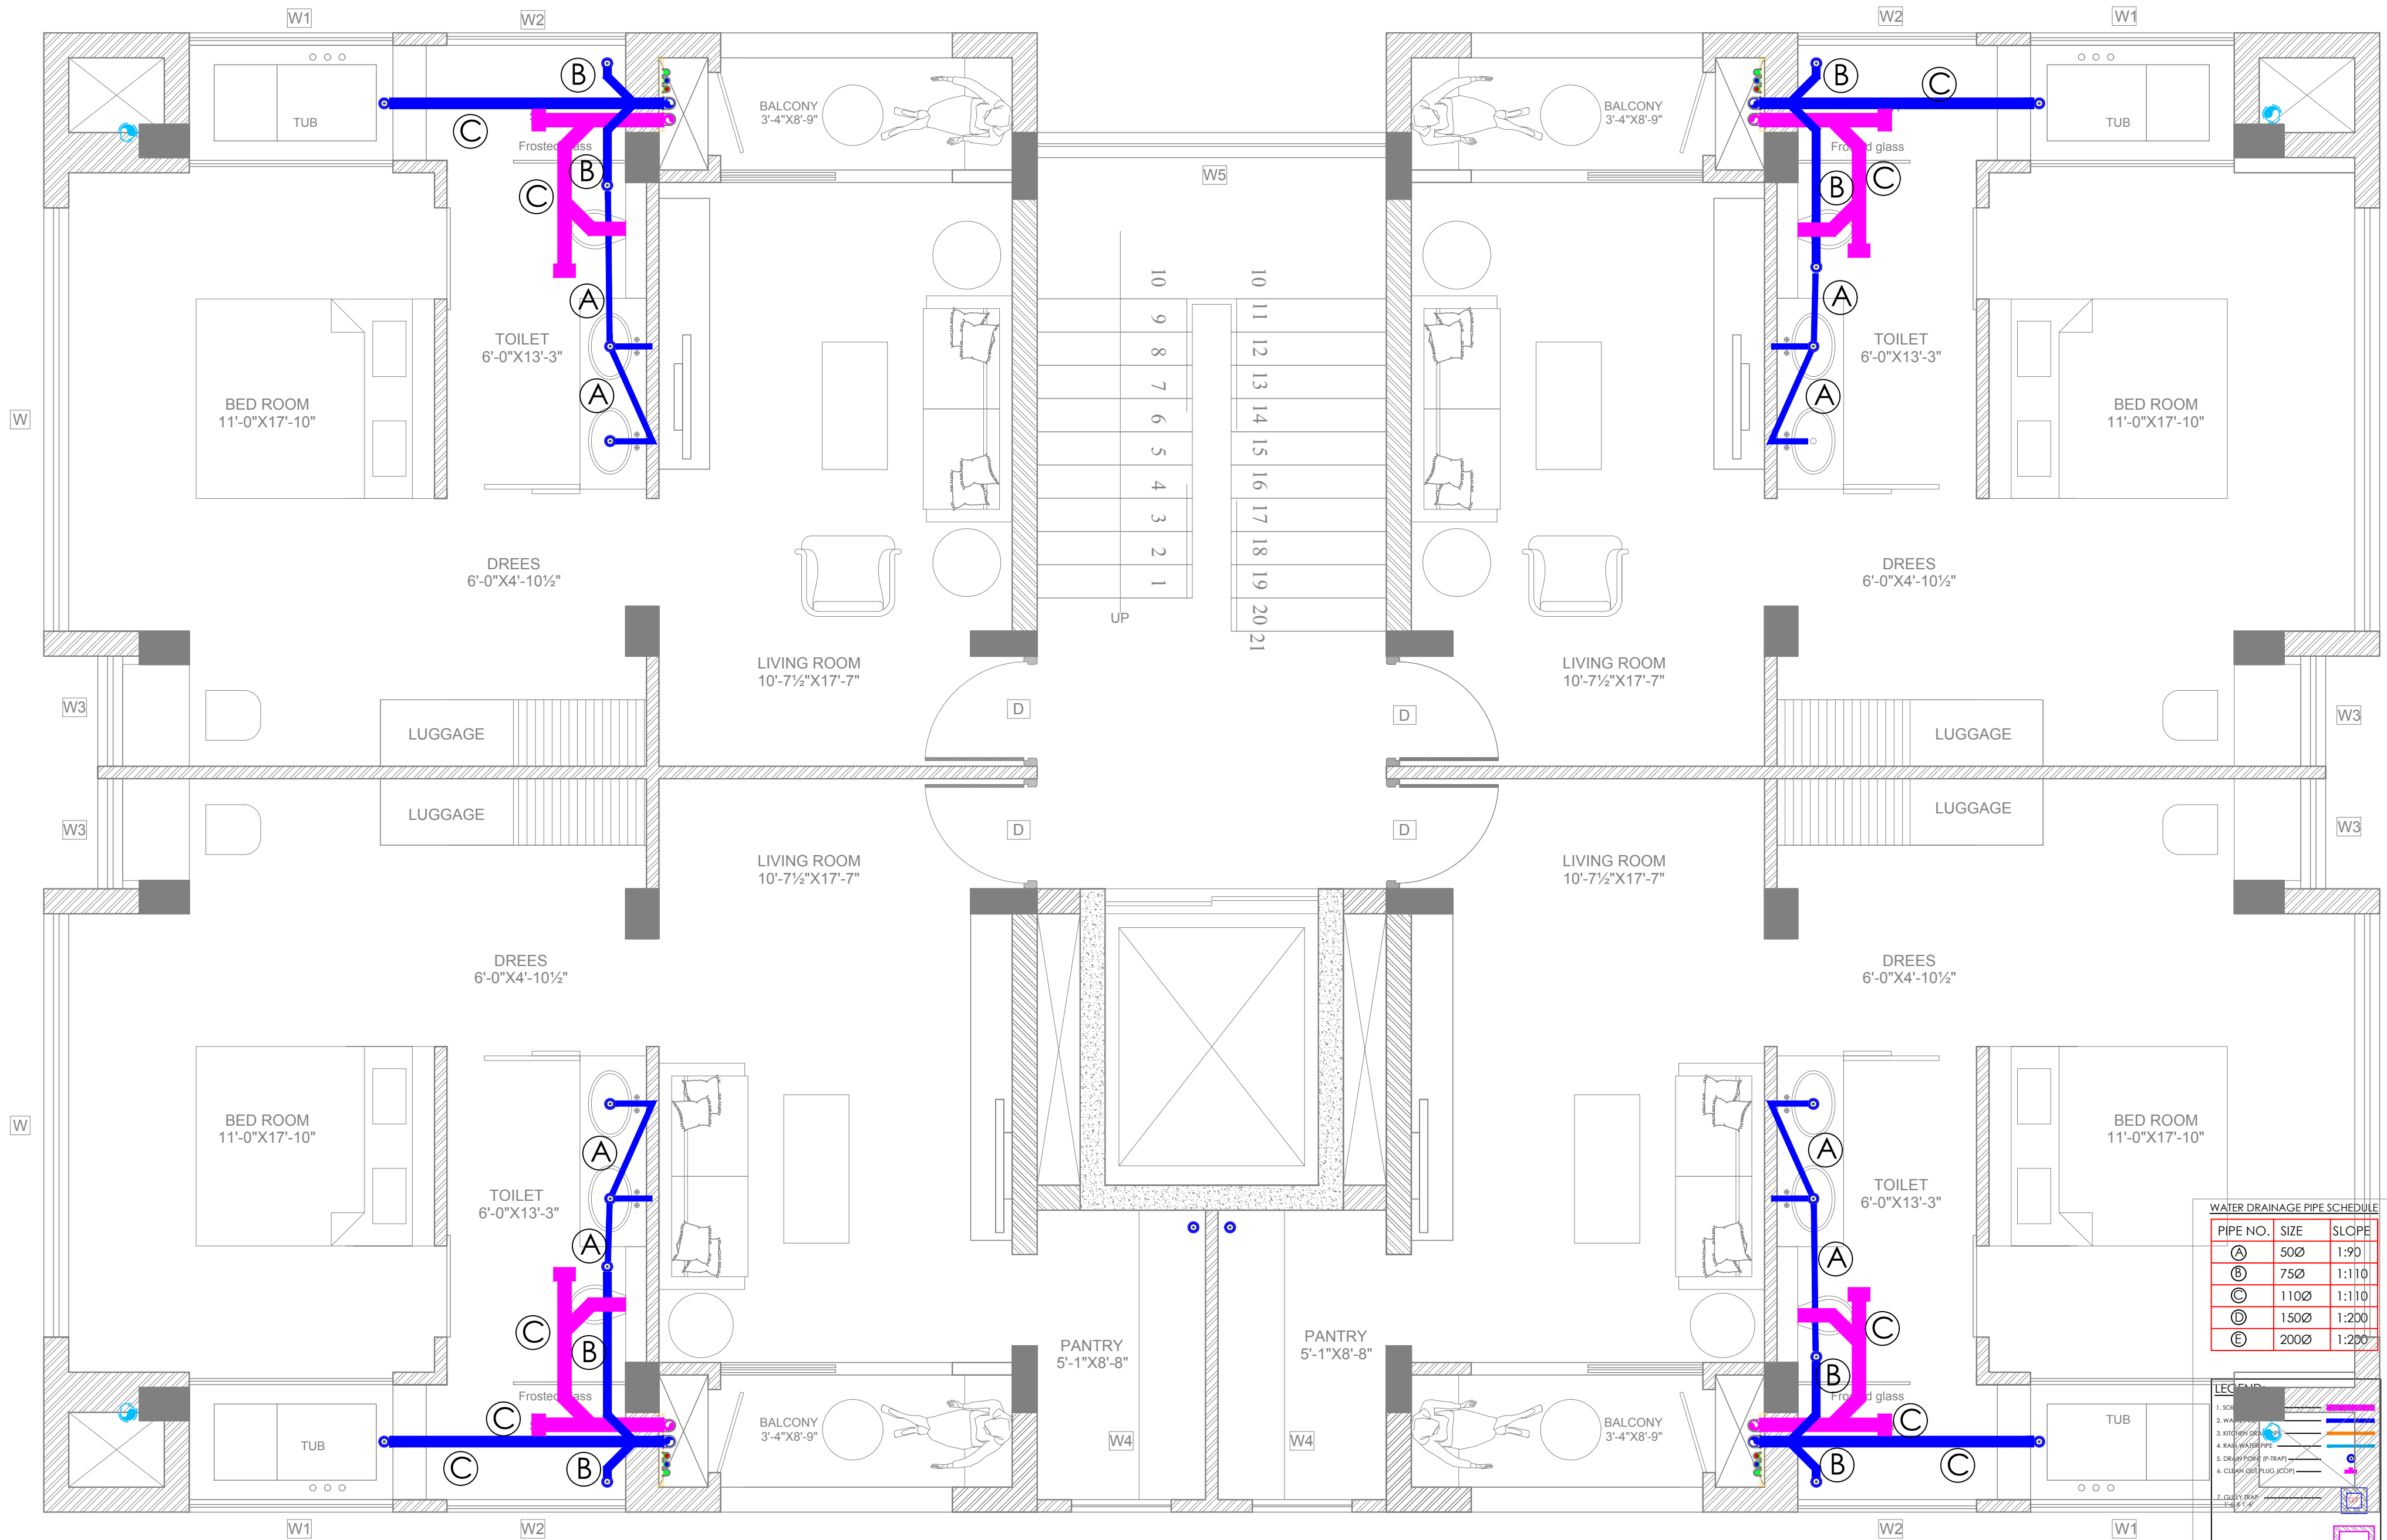

(R-11)-REVISED TYPICAL FLOOR PLAN

WATER DRAINAGE PIPE SCHEDULE		
PIPE NO.	SIZE	SLOPE
(A)	50Ø	1:90
(B)	75Ø	1:110
(C)	110Ø	1:110
(D)	150Ø	1:200
(E)	200Ø	1:200

LEGEND	
1. SINK	2. WASH BASIN
3. BATHTUB	4. RAINWATER
5. DRAINAGE (P-RAP)	6. CLEAN OUT PLUG (COP)
7. GUEST RAIN	8. MANHOLE FOR SEWER
9. MANHOLE FOR RAIN WATER	

 
HOTEL CLARKS,
JAIPUR

ARCHITECTS
NEERAV GUPTA
L-1, KRISHNA MARG, C- SCHEME,
JAIPUR (302001), RAJASTHAN.
PH.0141-2360825
E-Mail- architect_neeravgupta@yahoo.com

TYPICAL GUEST FLOOR
PLUMBING DRAINAGE
LAYOUT

SCALE: N.T.S.

PROJECT NO.42
DRAWING NO:
NGHC/PLU/03
REVISION NO.02
03.01.2019


SAN ENGINEERS & CONSULTANTS
G-2, 1855, CHITRA AKHAT SICHAR, NEAR PRATAP STADIUM,
OPPOSITE JAGORE FOUNDATION SCHOOL, VAISHALI NAGAR,
JAIPUR - 302021
E-mail: info@sancetl.com