


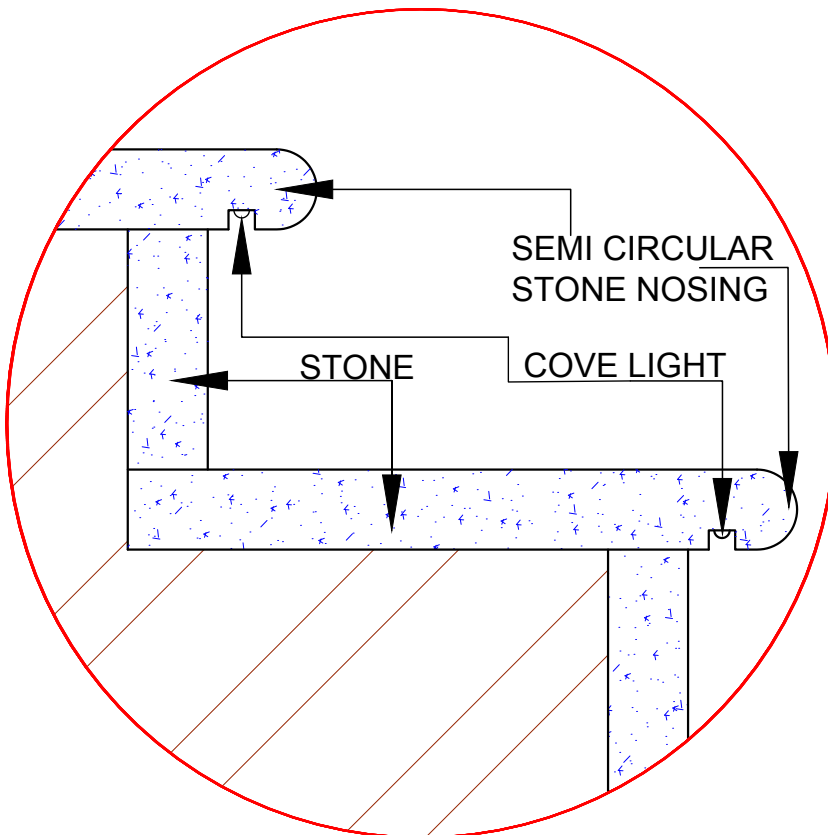

LIGHTING DETAIL FOR STAIRS AT BAVDI

LEGEND - ELECTRICAL

S.NO.	SYMBOL	DESCRIPTION OF ITEM
1		CEILING FAN
2		SWITCH BOARD
3		MASTER SWITCH
4		RETROFIT CFL INTEGRATED
5		BRACKET LIGHT +7'-0"
6		SWITCH SOCKET 6A.
7		SWITCH SOCKET 16A.
8		ANTENNA
9		TELEPHONE
10		Down Lighter 1W
11		WALL FAN
12		EXHAUST FAN
13		METALLIC SW. SOC 20A. IN MCB BOX
14		DISTRIBUTION BOX
15		TUBE LIGHT
16		MASHAL LIGHT
17		AC POINTS
18		UPLIGHTER
19		PAINTING LAMP
20		SPOT LIGHT
21		CHANDLER
22		HANGING LIGHT

NOTE: ALL BRACKET LIGHTS ARE AT 7'-0" LVL.

ARCHITECT:
NEERAV GUPTA
CA/2009/44766
L-1, KRISHNA MARG, C- SCHEME,
JAIPUR (302001), RAJASTHAN.
PH.0141-2360825 E-Mail-ravigupta_15@yahoo.com

PROJECT:
PROPOSED RESORT AT SAWAIMADHOPUR

DRAWING TITLE:
MAIN BUILDING BASEMENT FLOOR ELECTRICAL FLOOR LAYOUT

DRAWN BY: RISHABH	SCALE: NTS	DATE: 7-07-18
CHECKED BY: NEERAV GUPTA	NORTH	SHEET NO. >

NOTES:
THE COPYRIGHT AND PROPERTY OF THIS DESIGN AND DRAWING BELONGS TO **RAVI KUMAR GUPTA**. IT MUST NOT BE COPIED OR REPRODUCED IN ANY MANNER WITHOUT THEIR WRITTEN CONSENT. A LEGAL ACTION AS PER LAW MAY BE INITIATED AGAINST THE OFFENDER.

