


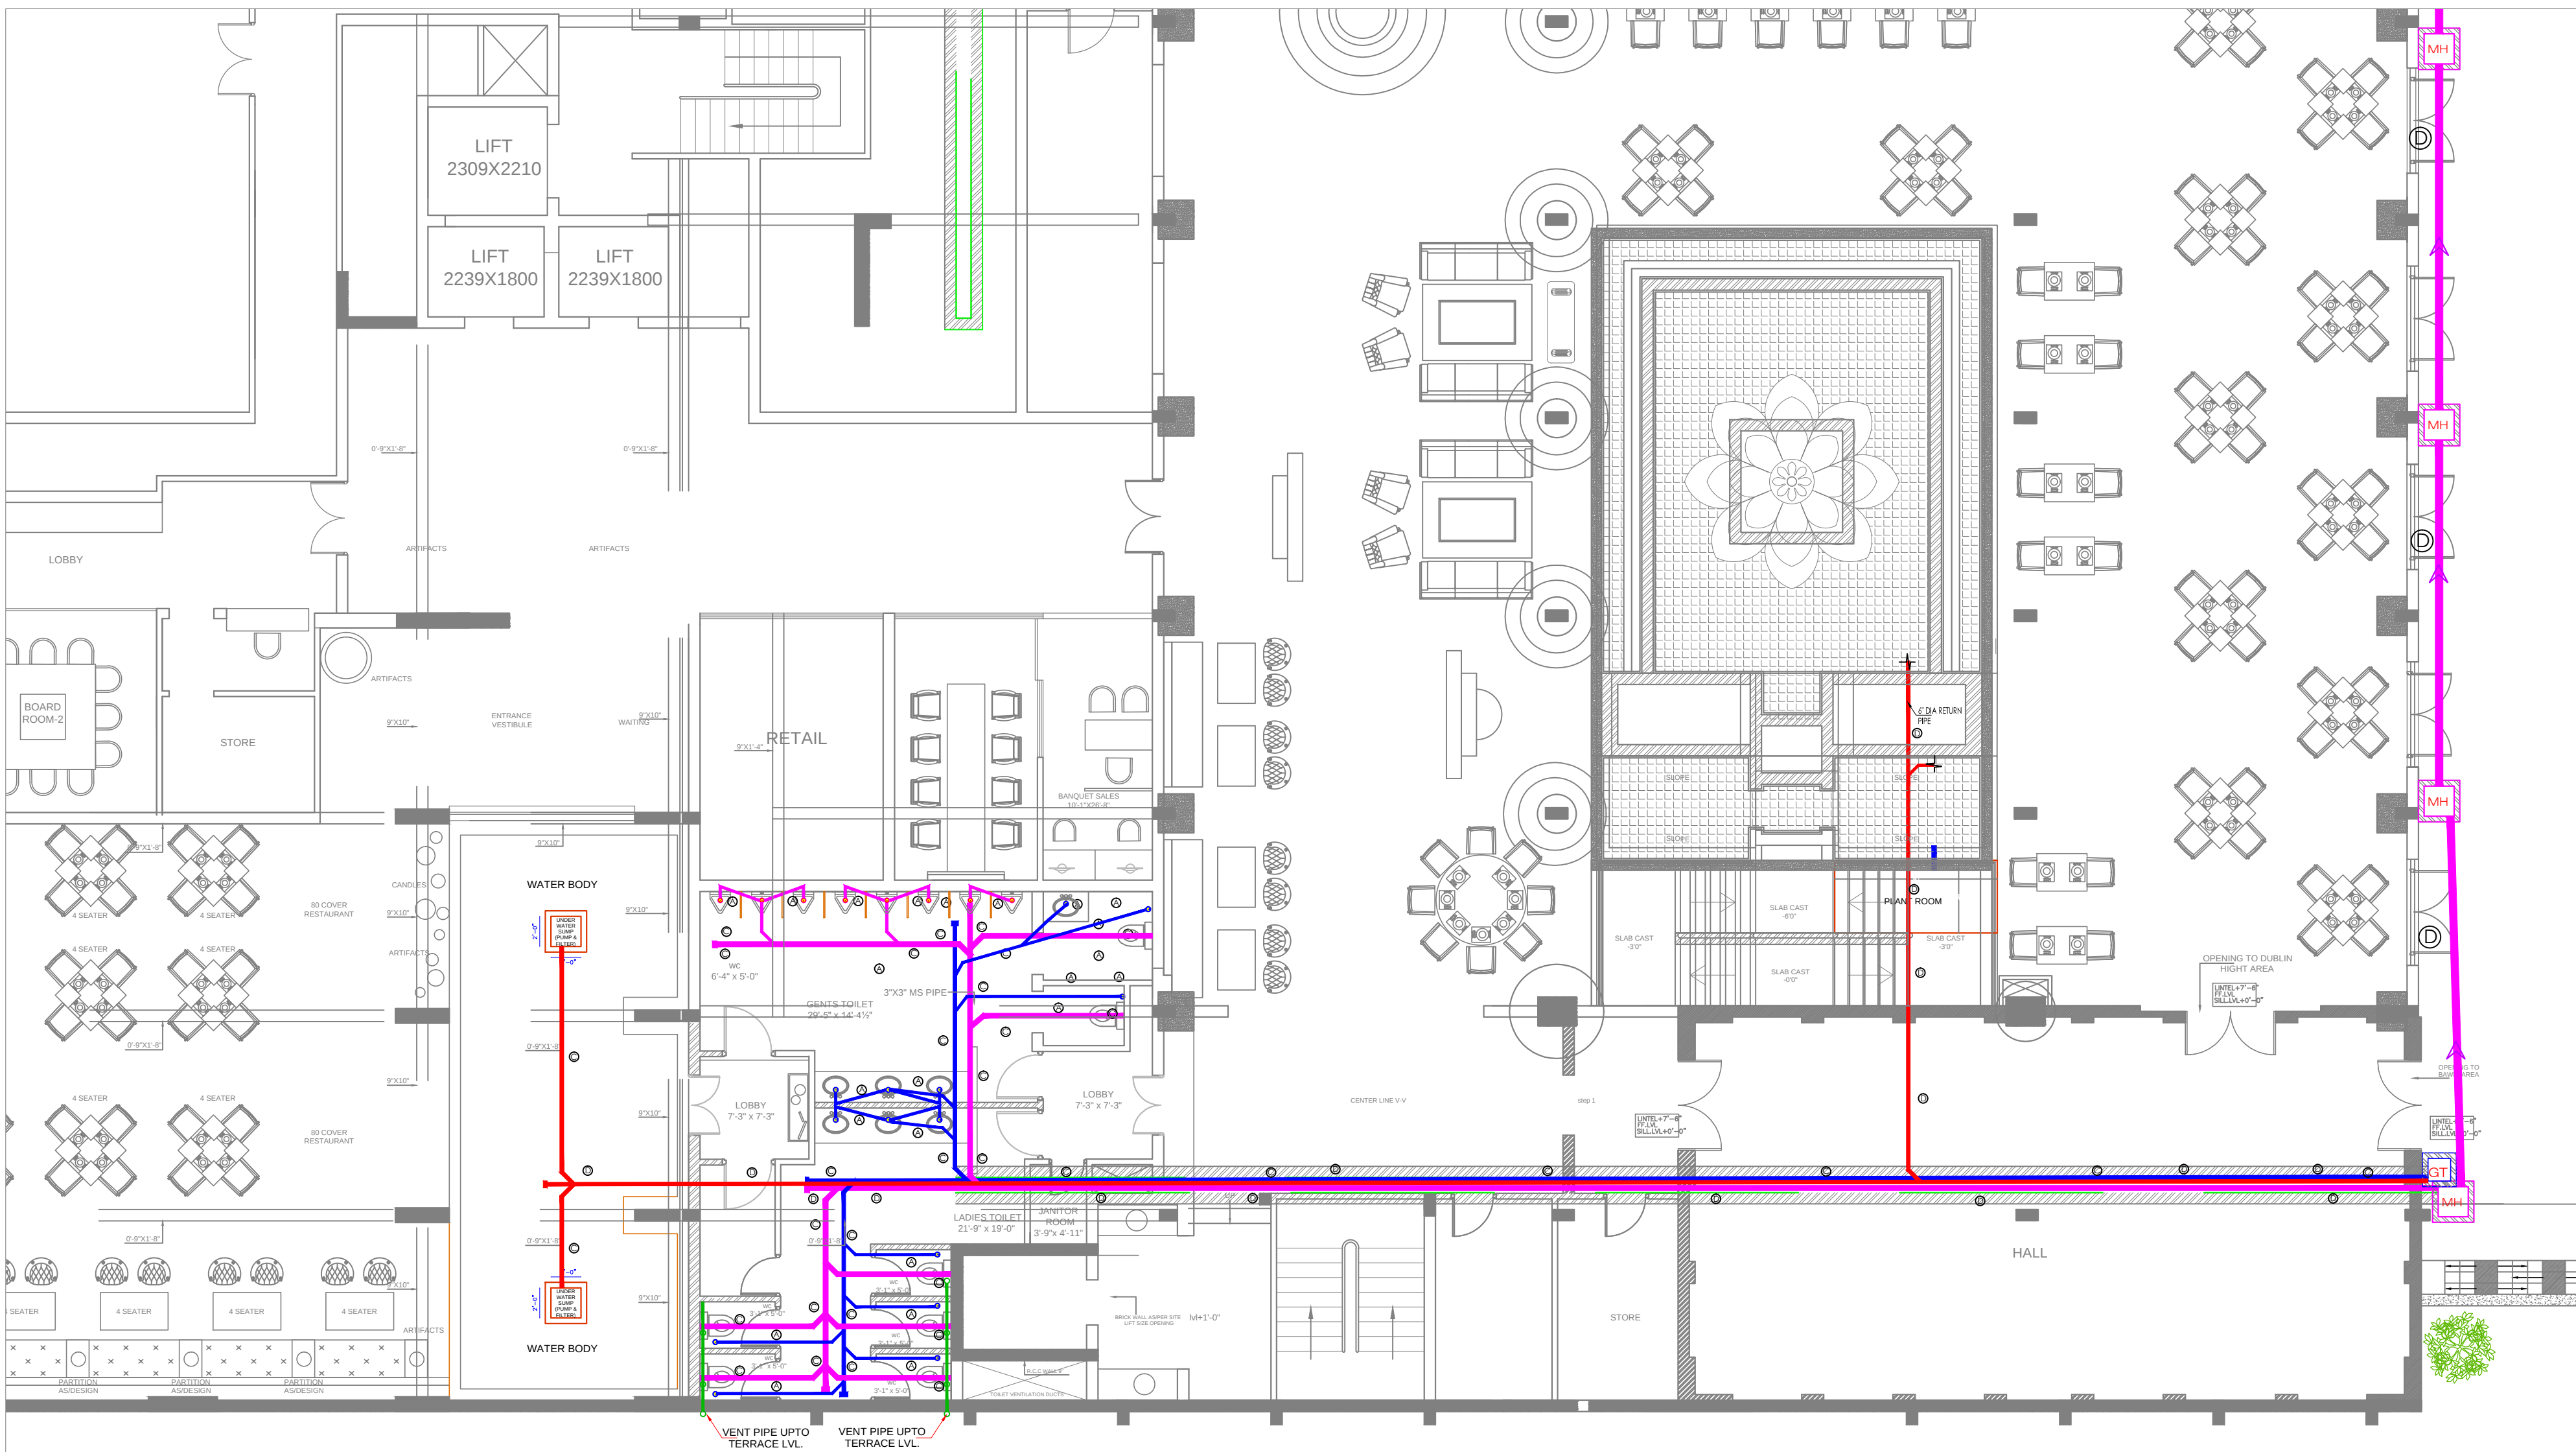

LEGEND:-

- 1. SDA PIPE
- 2. WASTE PIPE
- 3. KITCHEN DRAIN PIPE
- 4. P-TRAP
- 5. DRAIN FIGHT
- 6. COLD WATER SUPPLY
- 7. HOT WATER SUPPLY
- 8. HOT WATER RETURN
- 9. RAIN WATER PIPE LINE
- 10. AIR VENT PIPE
- 11. FLOOR CLEAN OUT PLUG (FCO)
- 12. CLEAN OUT PLUG (COP)
- 13. MANHOLE FOR SEWER LINE 2'-0" x 2'-0"
- 14. GILLY TRAP 1'-6" x 1'-6"
- 15. RAIN WATER COLLECTION MANHOLE 2'-0" x 2'-0"
- 16. KITCHEN DRAIN WATER MANHOLE 2'-0" x 2'-0"
- 17. WATER BODY DRAIN PIPE

RAIN WATER PVC PIPE SCHEDULE		
PIPE NO.	SIZE	SLOPE
①	150Ø	1:200
②	200Ø	1:250
③	300Ø	1:300

WATER DRAINAGE PIPE SCHEDULE		
PIPE NO.	SIZE	SLOPE
A	50Ø	1:90
B	75Ø	1:110
C	110Ø	1:110
D	150Ø	1:200

HOTEL CLARKS,
LUCKNOW

ARCHITECTS
NEERAV GUPTA
L-1, KRISHNA MARG, C-SCHEME,
JAIPUR (302001), RAJASTHAN.
PH.0141-2360825
E-Mail- architect_neeravgupta@yahoo.com

**BASEMENT FLOOR
WATER BODY AREA
DRAINAGE LAYOUT**

SCALE: N.T.S.
PROJECT NO-41
DRAWING NO-
NGHCLJ/P/L/05C
REVISION NO-03
27.06.2019

SAN ENGINEERS & CONSULTANTS
G-2, 1055, CHITRAKOOT SCHEME, NEAR PRATAP STADIUM,
VARHAULI NAGAR, BESIDE TAGORE FOUNDATION SCHOOL,
JAIPUR-302021, +91-141-405881
E-mail- info@san-e.com