


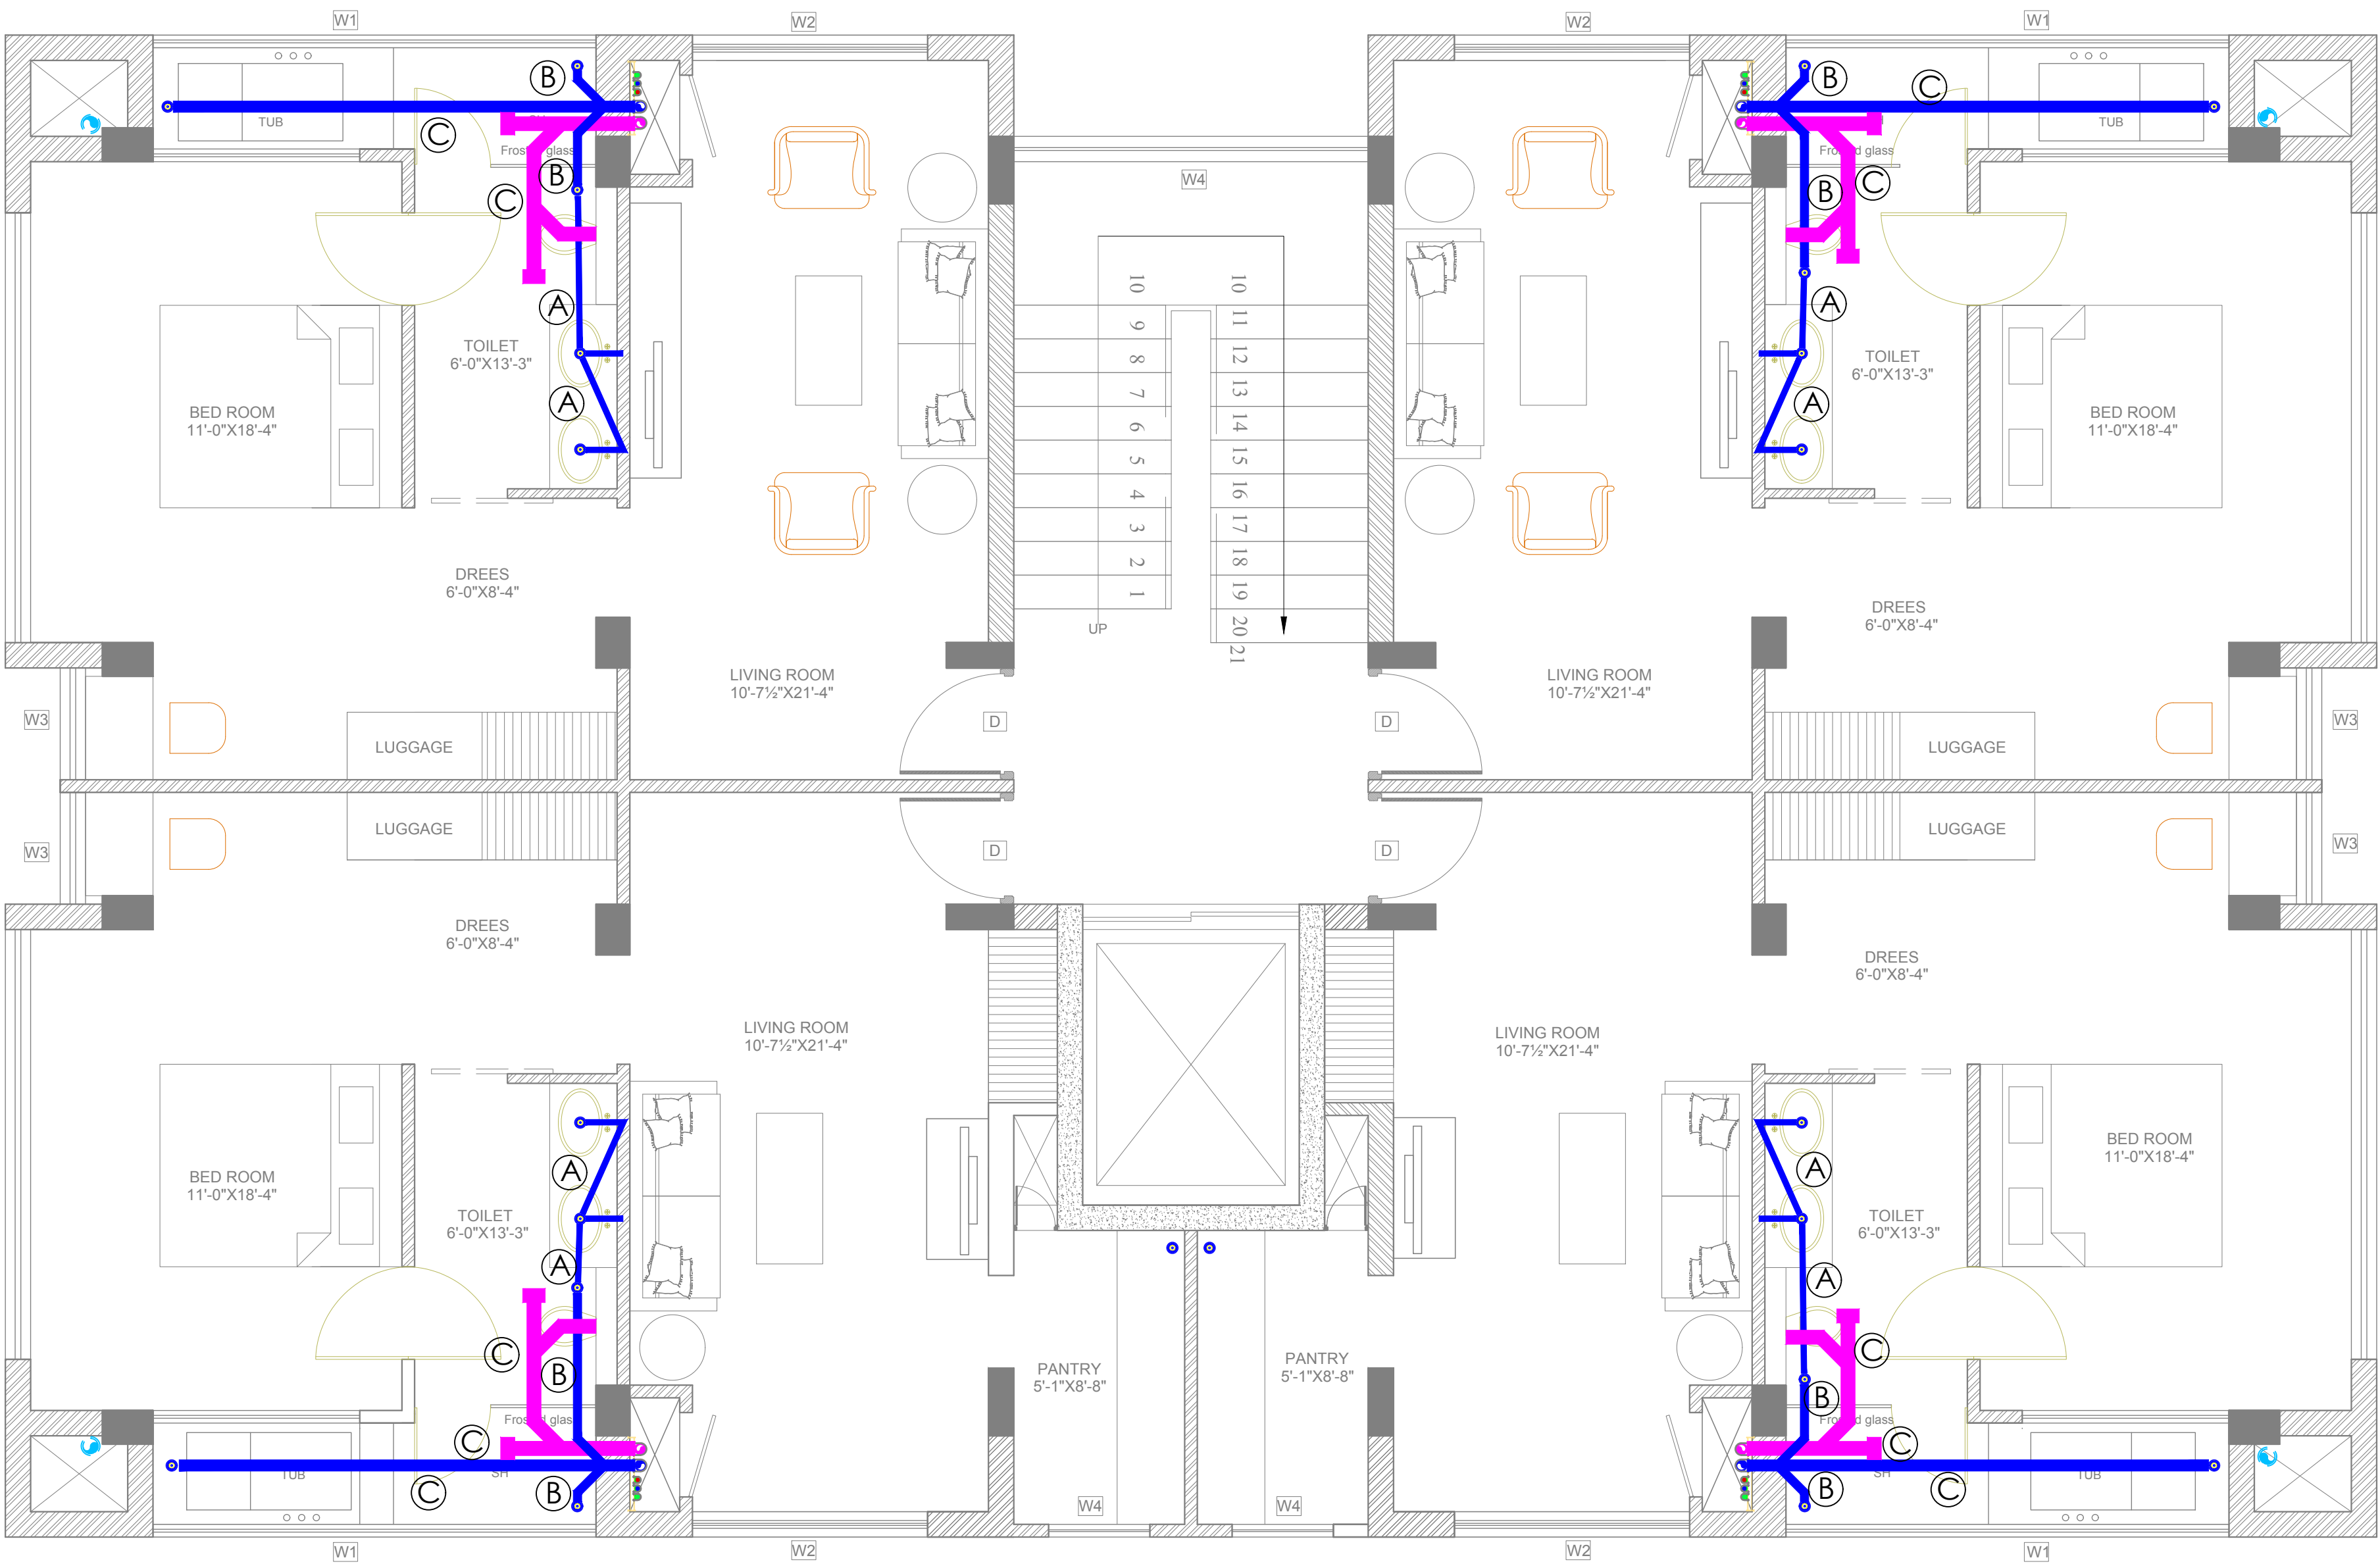

(R-12)-REVISED TYPICAL FLOOR PLAN
DATE-22-12-2018

WATER DRAINAGE PIPE SCHEDULE		
PIPE NO.	SIZE	SLOPE
(A)	50Ø	1:90
(B)	75Ø	1:110
(C)	110Ø	1:110
(D)	150Ø	1:200
(E)	200Ø	1:200

LEGEND:-	
1. SOL. PIPE	
2. WASTE PIPE	
3. KITCHEN DRAIN PIPE	
4. RAIN WATER PIPE	
5. DRAIN POINT (P-TRAP)	
6. CLEAN OUT PLUG (COP)	
7. GULLY TRAP 1'-6" X 1'-6"	
8. MANHOLE FOR SEWER LINE 2'-0" X 2'-0"	
9. MANHOLE FOR RAIN WATER 2'-0" X 2'-0"	

ARCHITECTS

NEERAV GUPTA
L-1, KRISHNA MARG, C- SCHEME,
JAIPUR (302001), RAJASTHAN.
PH-0141-2360825
E-Mail- architect_neeravgupta@yahoo.com

TYPICAL GUEST FLOOR
PLUMBING DRAINAGE
LAYOUT

SCALE: N.T.S.

PROJECT NO-42
DRAWING NO:
NG/HCI/PLU/03
REVISION NO-04
11.01.2019

SAN ENGINEERS & CONSULTANTS
G-2, JESS. CUTTACK ROAD, NEAR PRATAP STADIUM,
OPPPOSITE TAGORE PO, JAIPUR-30201
E-mail- info@sancpl.com

**HOTEL CLARKS,
JAIPUR**