


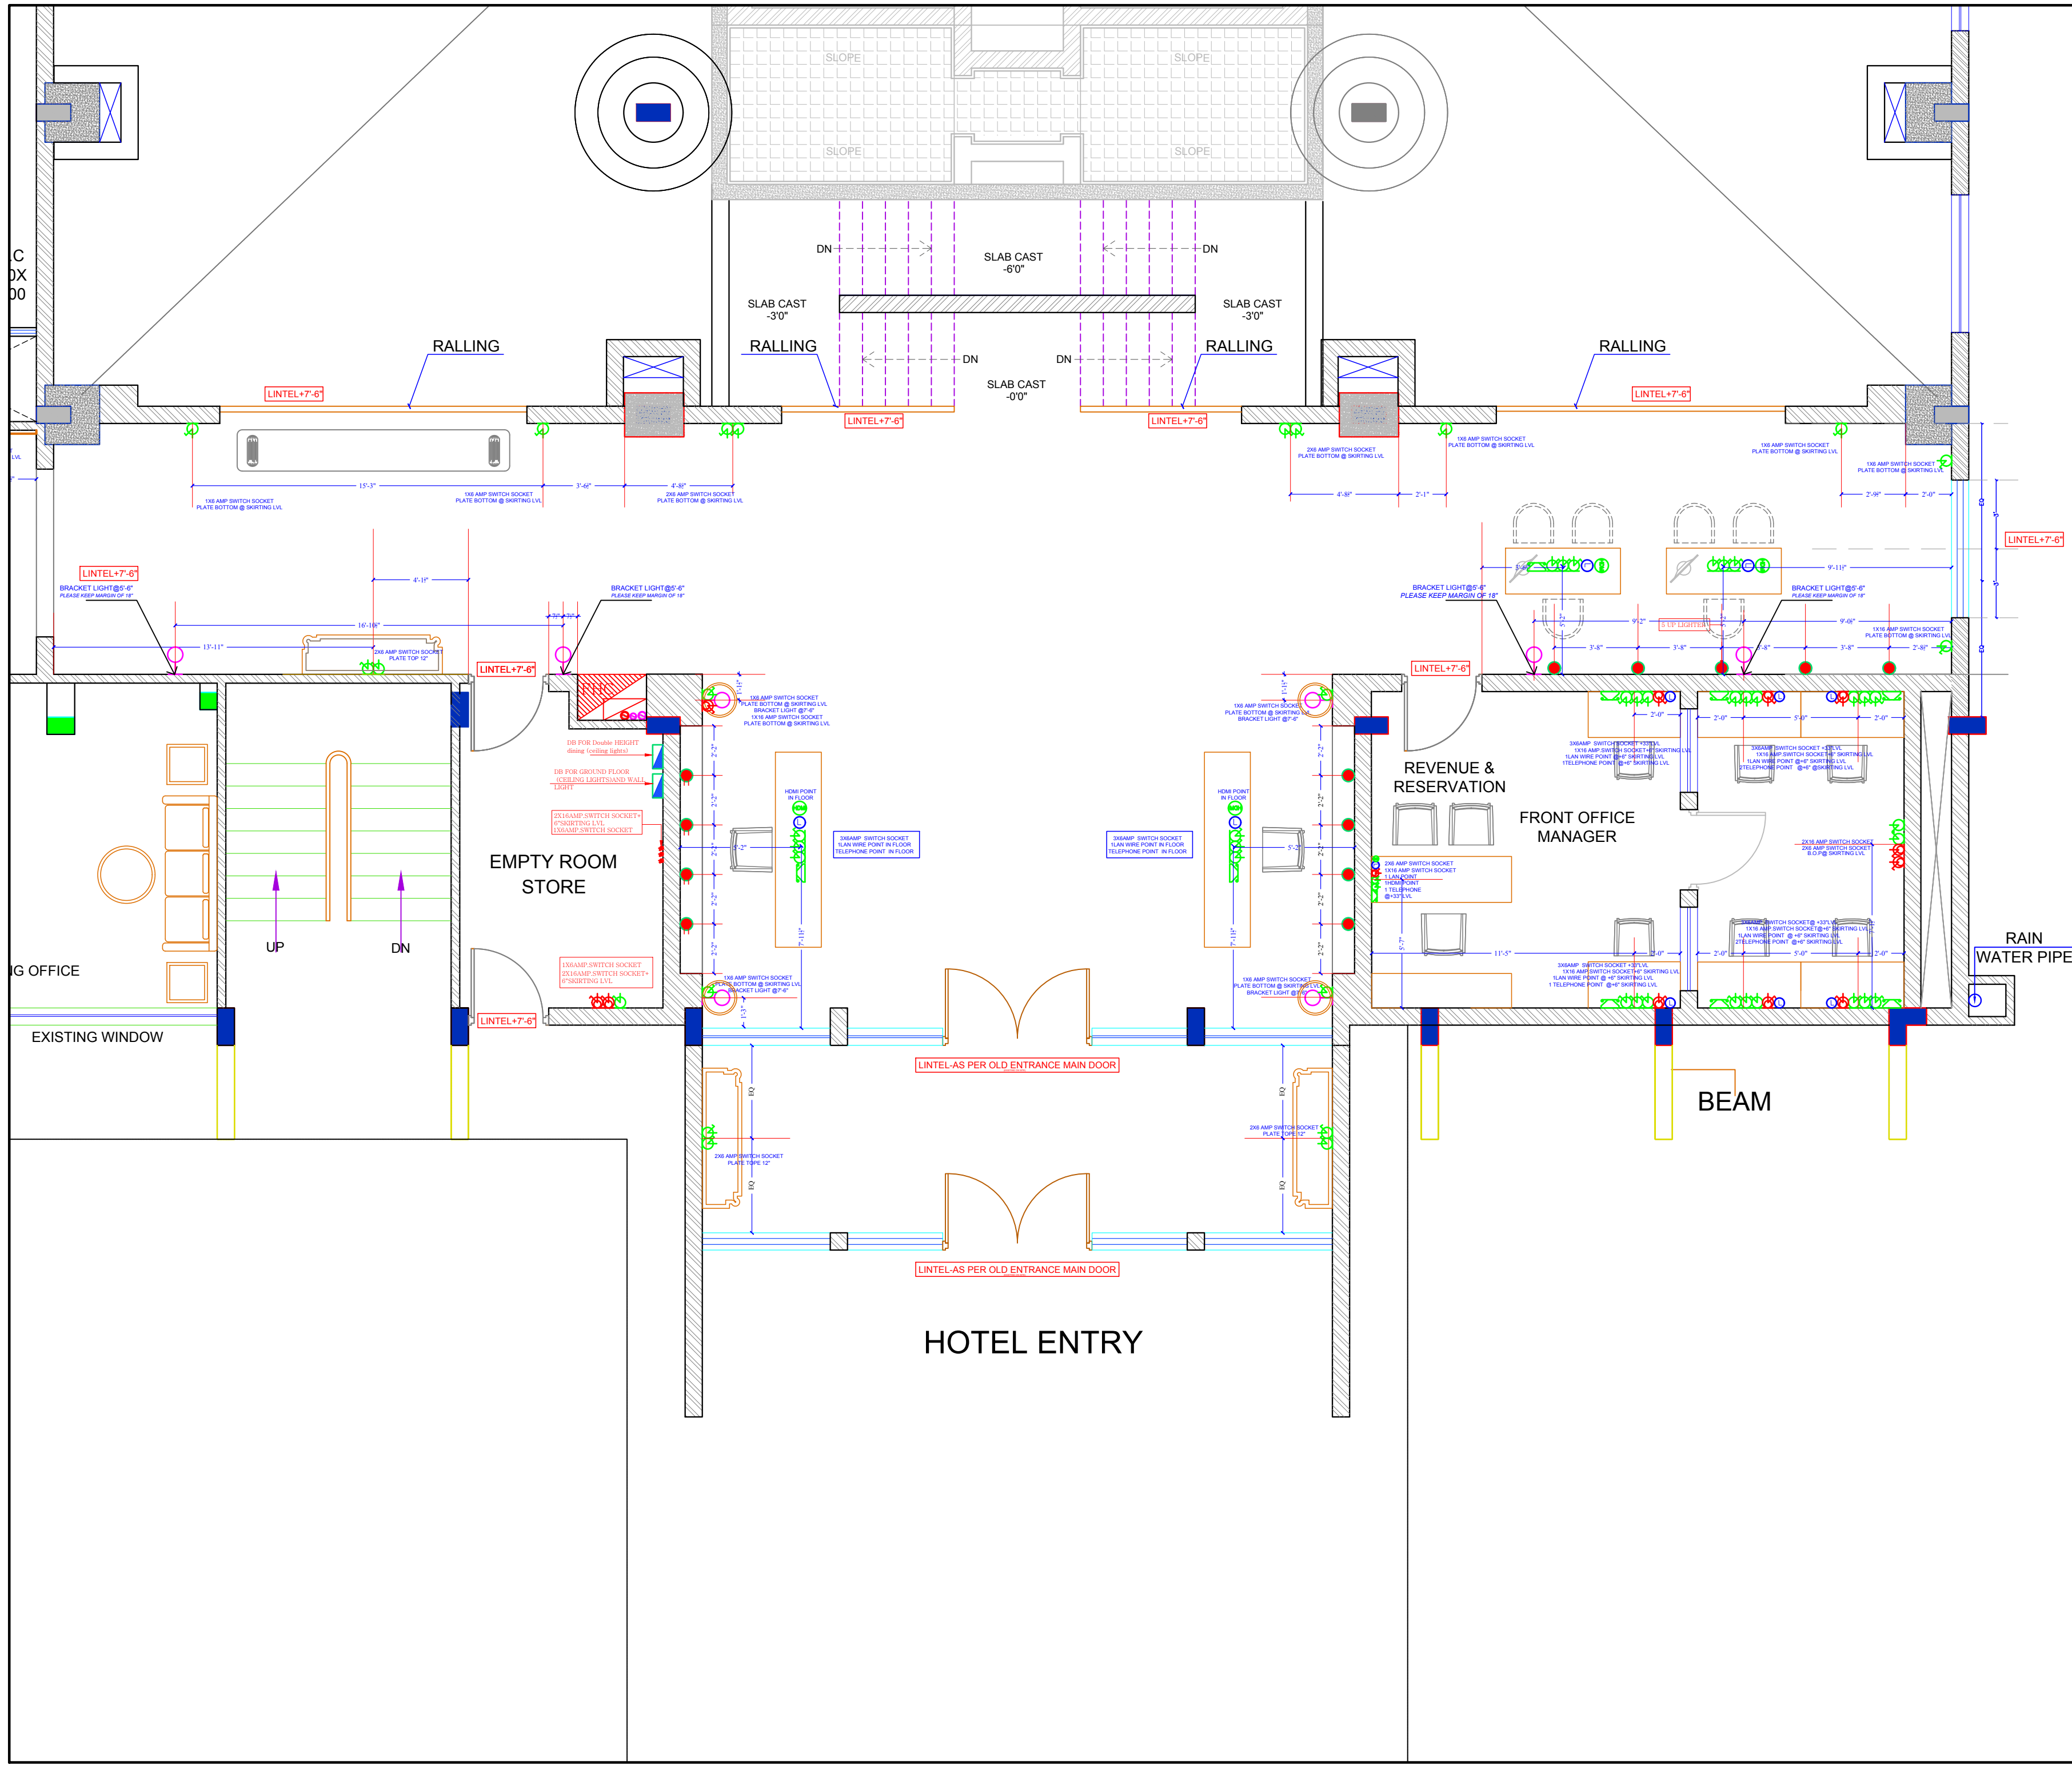

LEGEND - ELECTRICAL				
S.NO.	SYMBOL	DESCRIPTION OF ITEM	HT.	
1		CEILING FAN		
2		SWITCH BOARD		
3		BRACKET LIGHT	6'-0"	
4		RETROFIT CFL INTEGRATED		
5		SWITCH SOCKET 6A.		
6		SWITCH SOCKET 16A.		
7		ANTENNA		
8		CHANDELLIER		
9		DISTRIBUTION BOX		
10		PICTURE LIGHT		
11		HANGING LIGHT		
12		CHANDELLIER		
13		UPLIGHTERS		
14		DOWNLIGHTERS		
15		DON'T DISTURB (DND)		
16		CARD HOLDER		
17		AIR CONDITIONER		
18		FOOT LIGHT		
19		CEILING SPEAKER		
20				

ARCHITECT:
NEERAV GUPTA
L-1, KRISHNA MARG, C- SCHEME,
JAIPUR (302001), RAJASTHAN.
PH.0141-2360825
E-Mail-architect_neeravgupta@yahoo.com

PROJECT:
CLARKS
DRAWING TITLE:
GROUND FLOOR
WALL ELECTRICAL PLAN 1

DRAWN BY: RAHUL	SCALE: N.T.S.	DATE: 20-07-2019
CHECKED BY: NEERAV GUPTA	SHEET NO :-18 	C/AV/AR/WR/80

NOTES:
THE COPYRIGHT AND PROPERTY OF THIS DESIGN AND DRAWING BELONGS TO **NEERAV GUPTA**. IT MUST NOT BE COPIED OR REPRODUCED IN ANY MANNER WITHOUT THEIR WRITTEN CONSENT. A LEGAL ACTION AS PER LAW MAY BE INITIATED AGAINST THE OFFENDER.