




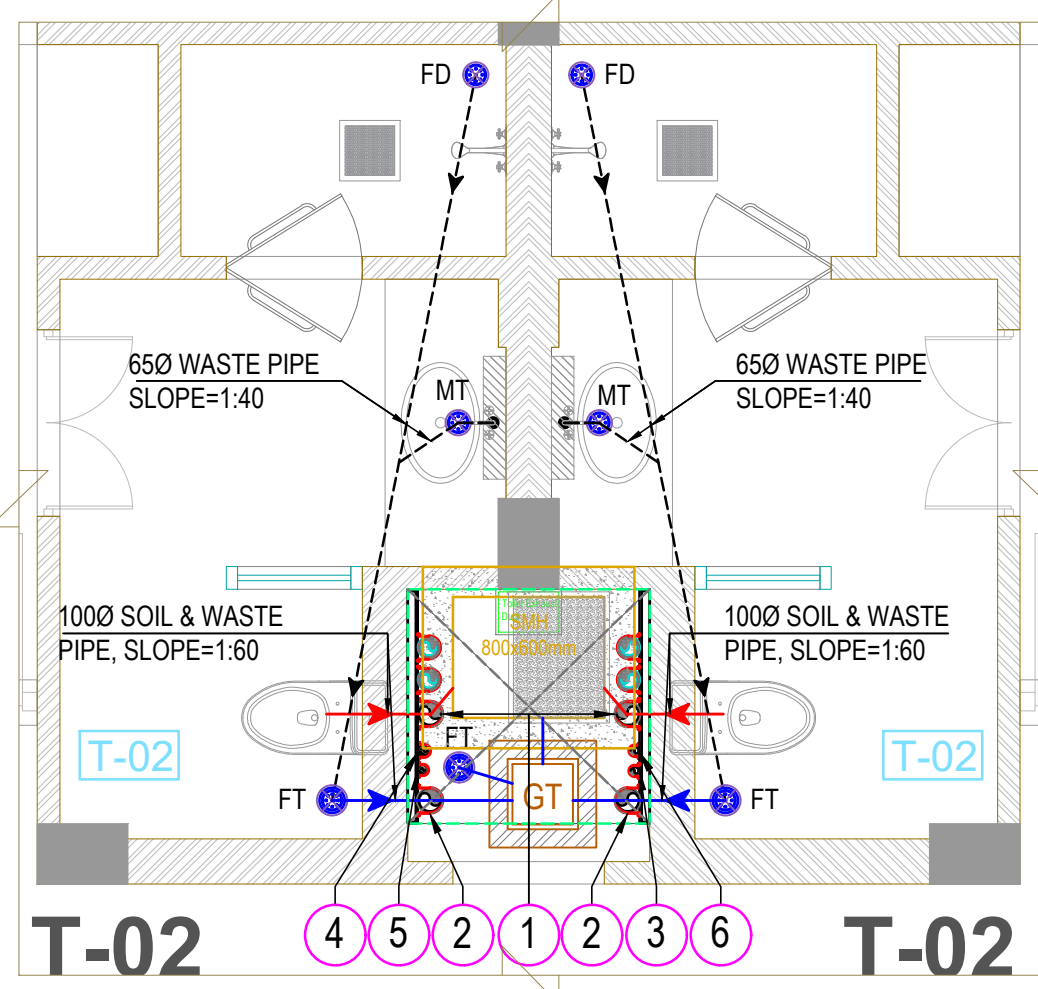


TOILET-02 FOR GROUND FLOOR  
(DRAINAGE LAYOUT)

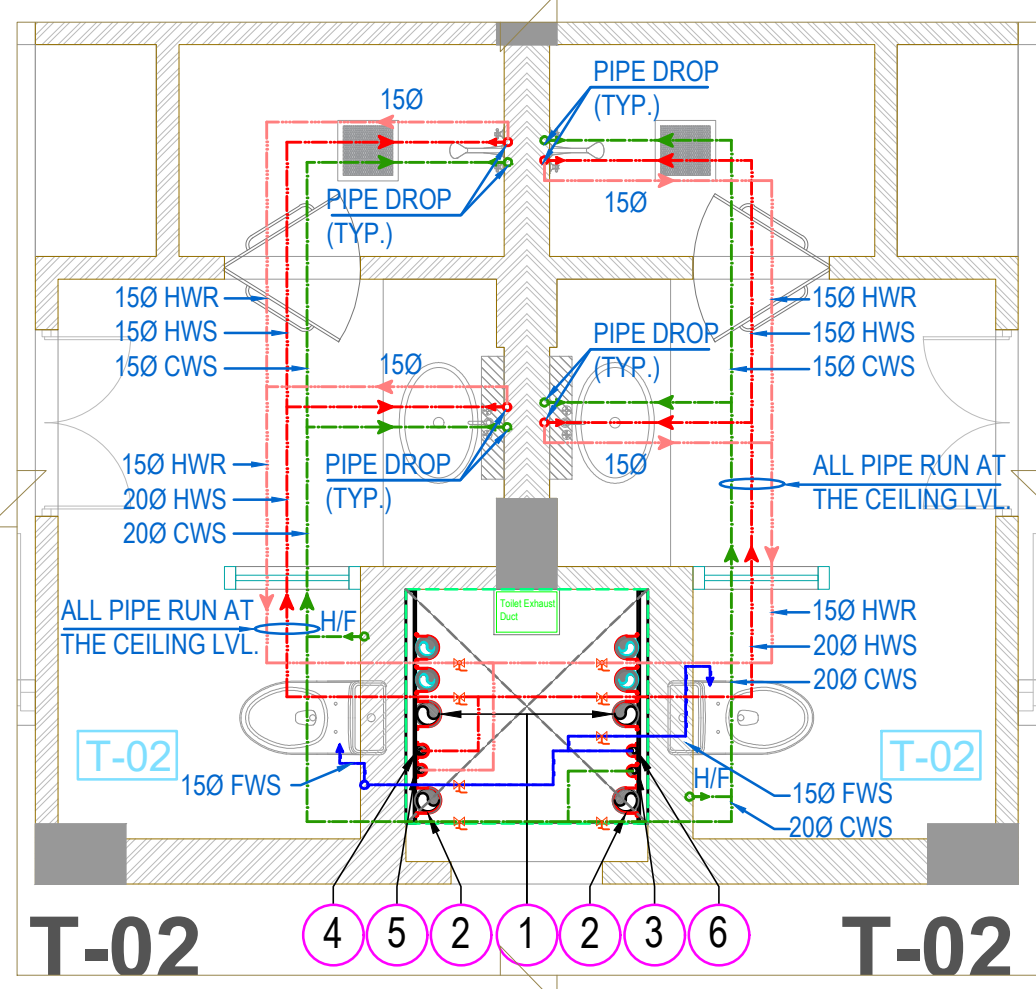

TOILET-02 FOR GROUND FLOOR  
(WATER SUPPLY LAYOUT)

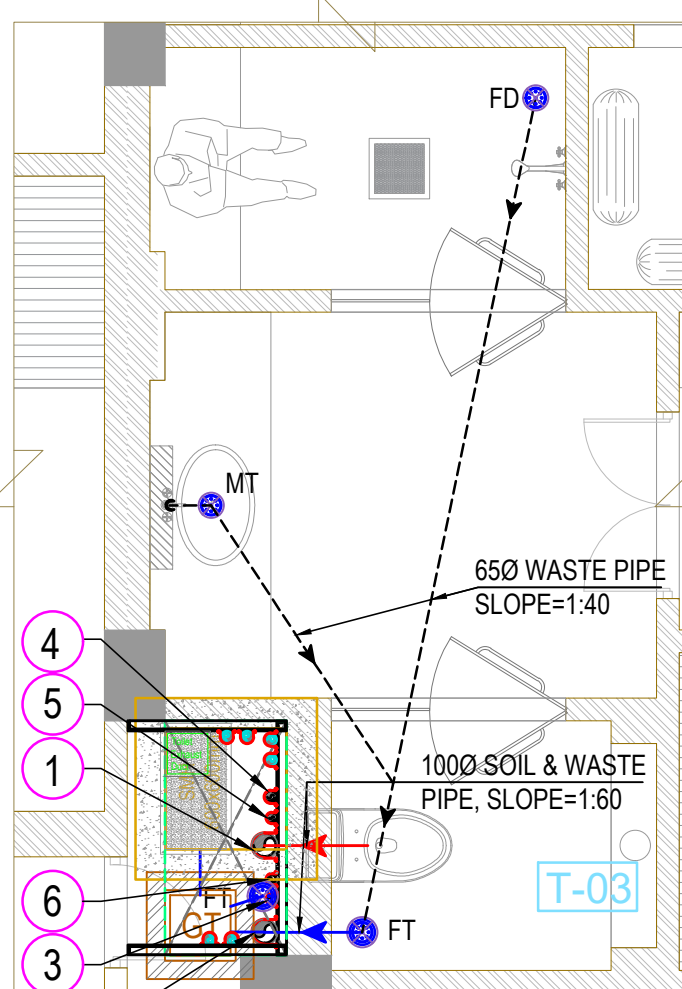

TOILET-03 FOR GROUND  
FLOOR (DRAINAGE LAYOUT)

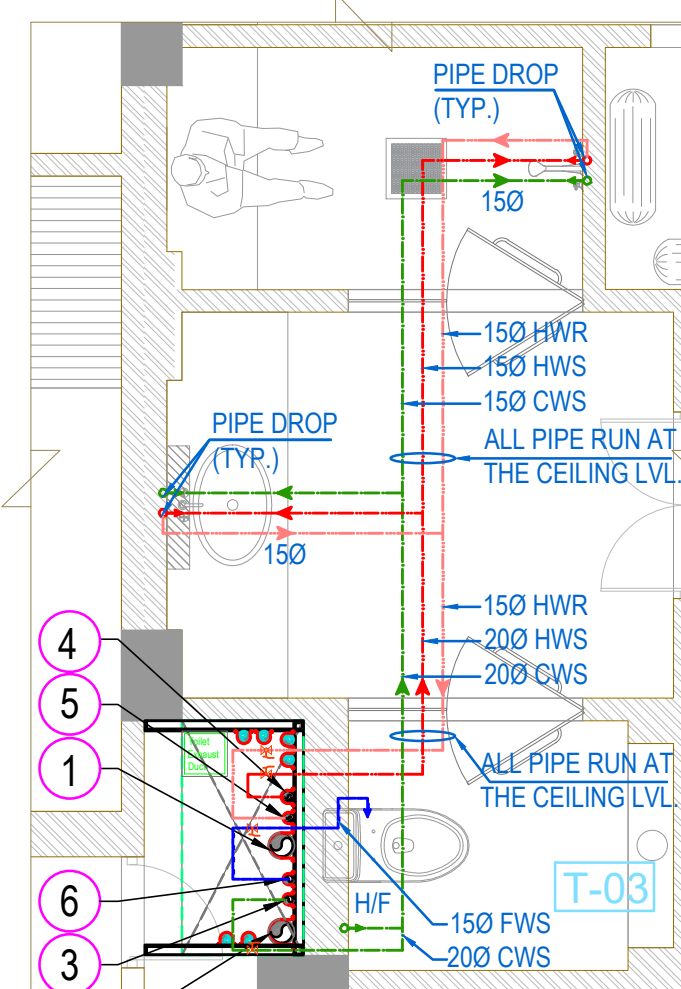


TOILET-03 FOR GROUND FLOOR  
(WATER SUPPLY LAYOUT)


#### PLUMBING LEGEND

| CWS | COLD WATER SUPPLY          |
|-----|----------------------------|
| FWS | FLUSHING WATER SUPPLY      |
| HWS | HOT WATER SUPPLY           |
| HWR | HOT WATER RETURN           |
|     | BALL VALVE                 |
|     | GLOBE VALVE                |
|     | COLD WATER SUPPLY PIPE     |
|     | FLUSHING WATER SUPPLY PIPE |
|     | HOT WATER SUPPLY PIPE      |
|     | HOT WATER RETURN PIPE      |


| PLUMBING LEGEND |                                                                                            |
|-----------------|--------------------------------------------------------------------------------------------|
| ①               | 1000 SOIL VERTICAL & VENT PIPE                                                             |
| ②               | 1000 WASTE VERTICAL & VENT PIPE                                                            |
| ③               | COLD WATER SUPPLY PIPE FROM W.T.P. PLANT ROOM (HYDRO-PNEUMATIC SYSTEM) FOR GR. & 1ST FLOOR |
| ③a              | COLD WATER SUPPLY PIPE FROM W.T.P. PLANT ROOM (HYDRO-PNEUMATIC SYSTEM) FOR 2ND & 3RD FLOOR |
| ③b              | COLD WATER SUPPLY PIPE TO PUBLIC TOILETS FROM O.H. TANK (BY GRAVITY)                       |
| ④               | HOT WATER SUPPLY PIPE FROM CENTRALISED HOT WATER SYSTEM FOR GR. & 1ST FLOOR                |
| ④a              | HOT WATER SUPPLY PIPE FROM CENTRALISED HOT WATER SYSTEM FOR 2ND & 3RD FLOOR                |
| ⑤               | HOT WATER RETURN PIPE TO CENTRALISED HOT WATER SYSTEM FOR GR. & 1ST FLOOR                  |
| ⑤a              | HOT WATER RETURN PIPE TO CENTRALISED HOT WATER SYSTEM FOR 2ND & 3RD FLOOR                  |
| ⑥               | FLUSHING WATER SUPPLY PIPE FROM O.H. TANK FOR GR. & 1ST FLOOR                              |
| ⑥a              | FLUSHING WATER SUPPLY PIPE FROM O.H. TANK FOR 2ND & 3RD FLOOR                              |
| ⑥b              | FLUSHING WATER SUPPLY PIPE TO PUBLIC TOILETS FROM O.H. TANK (BY GRAVITY)                   |
| ⑦               | COLD RISER PIPE FOR O.H. TANK FILLING                                                      |
| ⑧               | FLUSHING RISER PIPE FOR O.H. TANK FILLING                                                  |
| ⑨               | 1500 RAIN WATER VERTICAL PIPE                                                              |
| ⑩               | 1000 RAIN WATER VERTICAL PIPE                                                              |
|                 | SOIL PIPE (RUN IN SUNKEN / CEILING)                                                        |
|                 | WASTE PIPE (RUN IN SUNKEN / CEILING)                                                       |
|                 | FLOOR TRAP 100X100MM ('P' TRAP) WITH S.S GRATING                                           |
|                 | FLOOR DRAIN (100X50MM) WITH S.S GRATING                                                    |
|                 | MULTI TRAP (75X50MM) WITH S.S GRATING                                                      |
| WB TO FT        | 320 WASTE PIPE                                                                             |
| FD TO FT        | 500 / 650 WASTE PIPE                                                                       |
| FT TO MAIN PIPE | 1000 WASTE PIPE                                                                            |
| UT TO MAIN PIPE | 1000 SOIL PIPE                                                                             |
| WC TO MAIN PIPE | 1000 SOIL PIPE                                                                             |

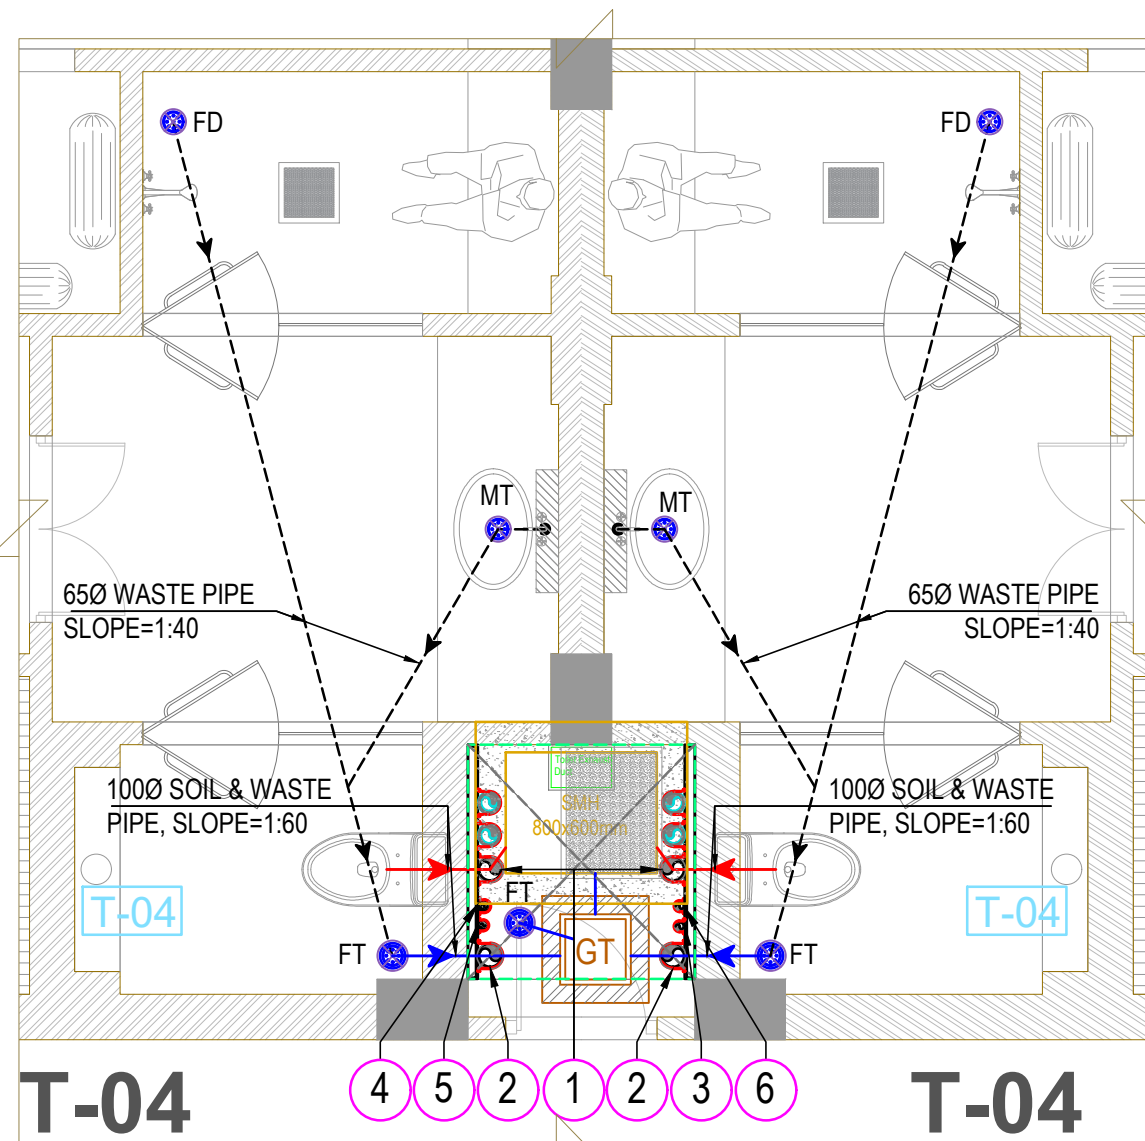


TOILET-04 FOR GROUND FLOOR  
(DRAINAGE LAYOUT)

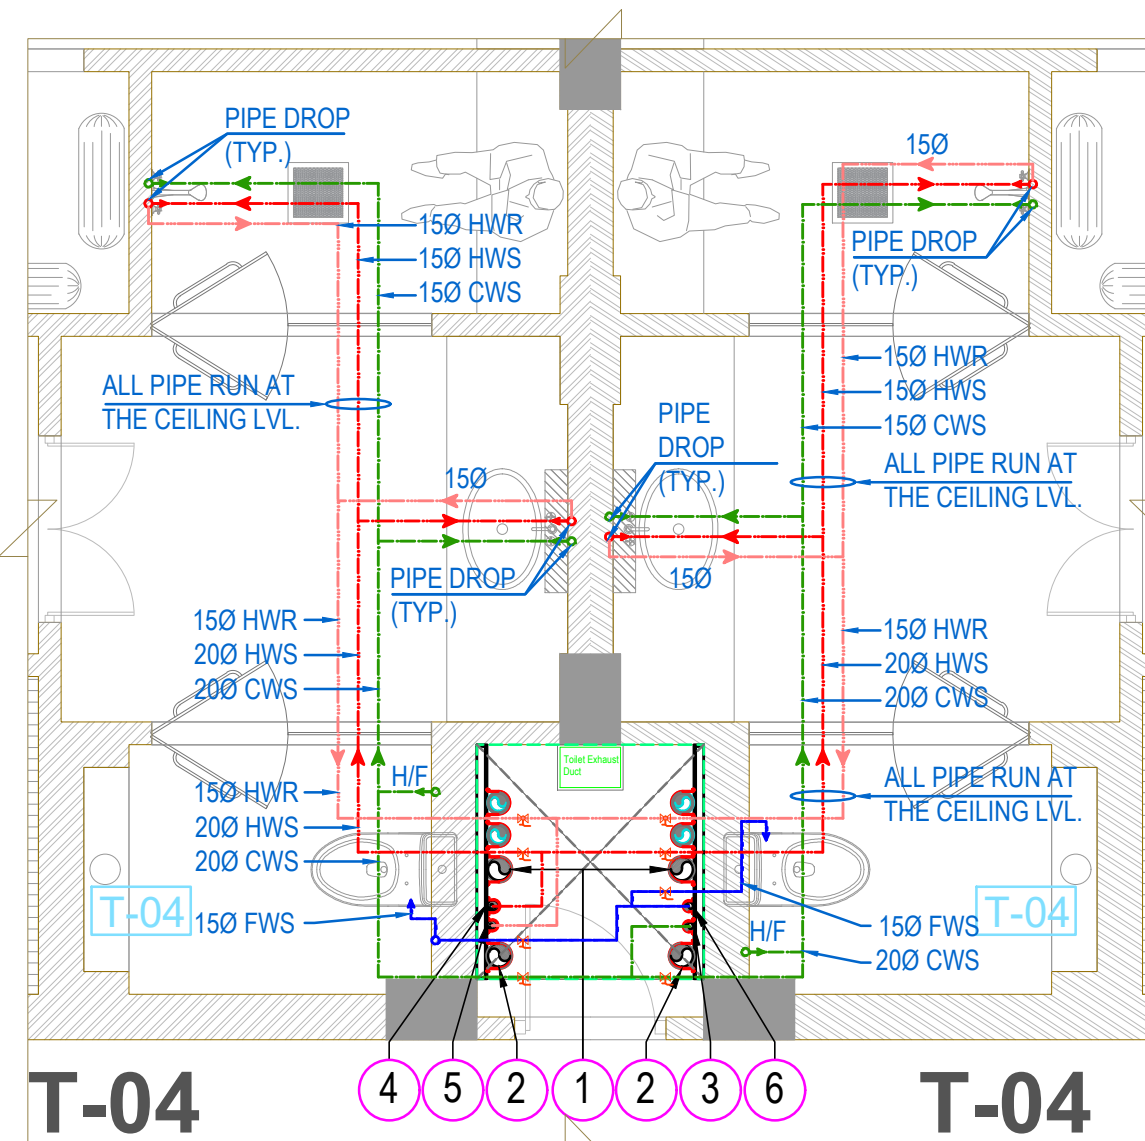


TOILET-04 FOR GROUND FLOOR  
(WATER SUPPLY LAYOUT)

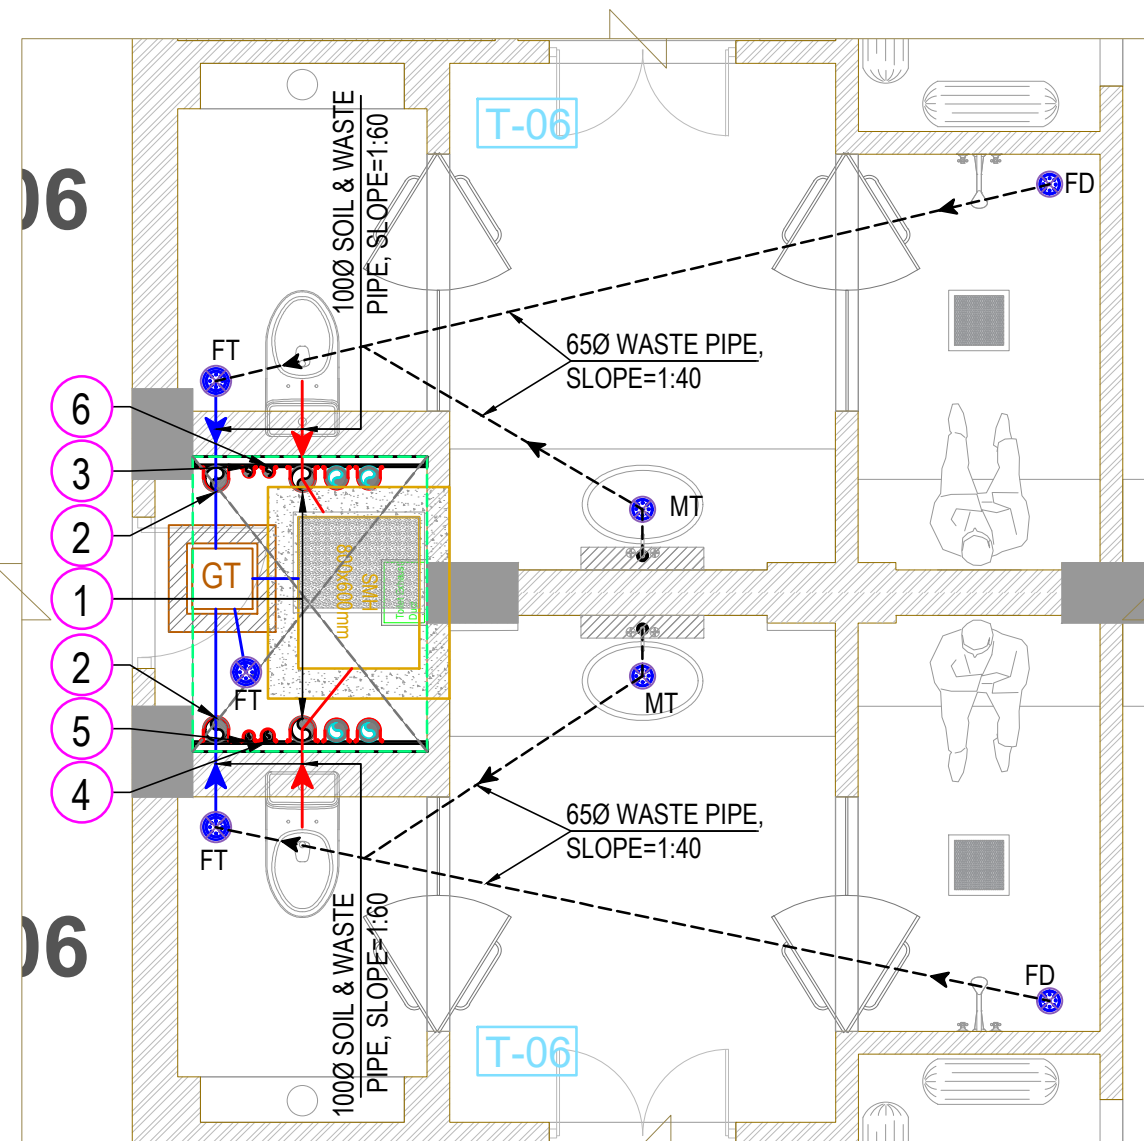


TOILET-06 FOR GROUND FLOOR  
(DRAINAGE LAYOUT)

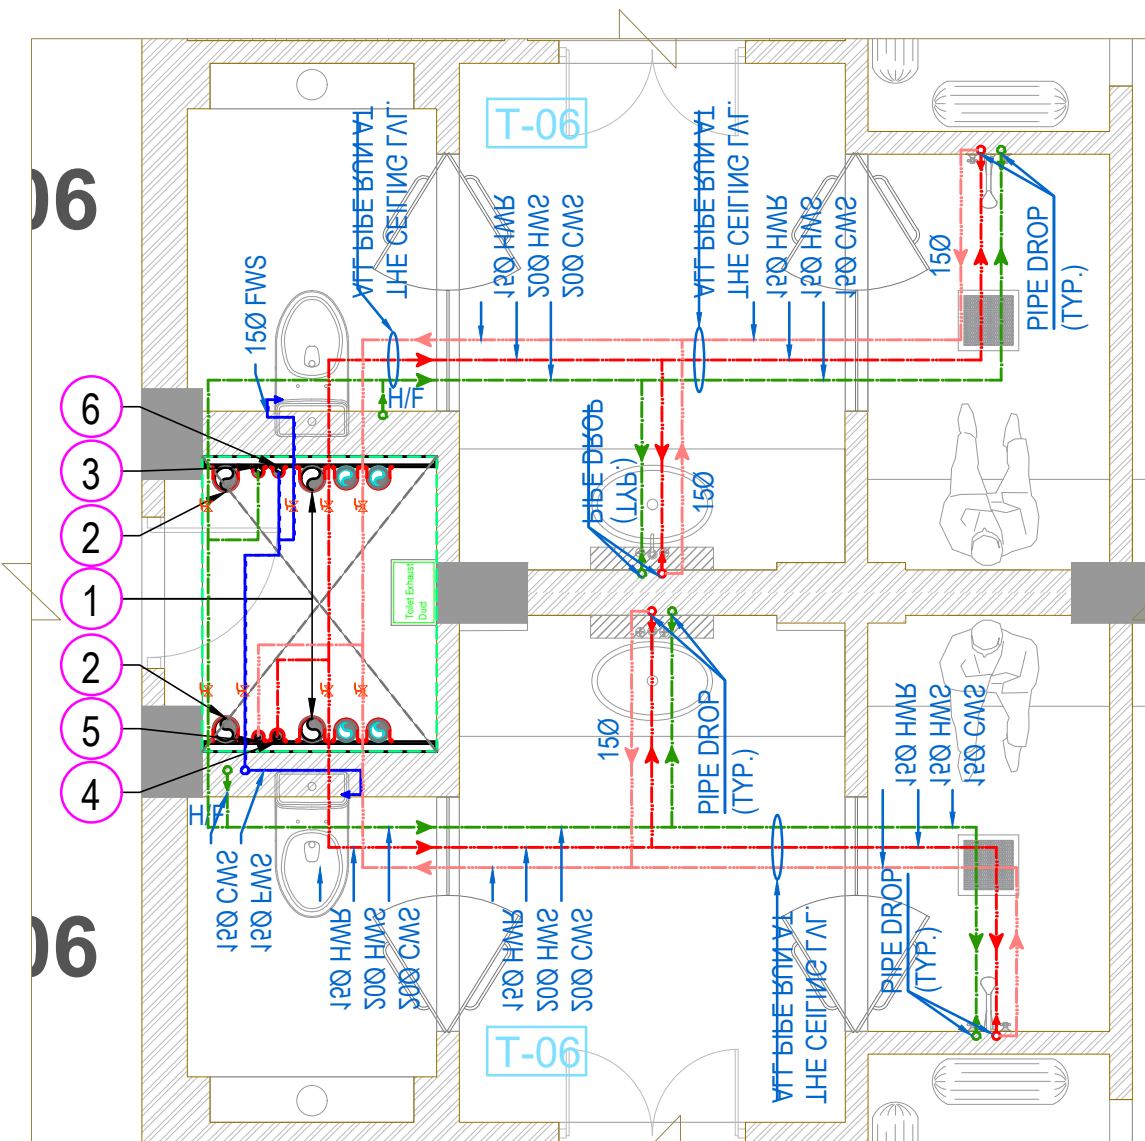

TOILET-06 FOR GROUND FLOOR  
(WATER SUPPLY LAYOUT)

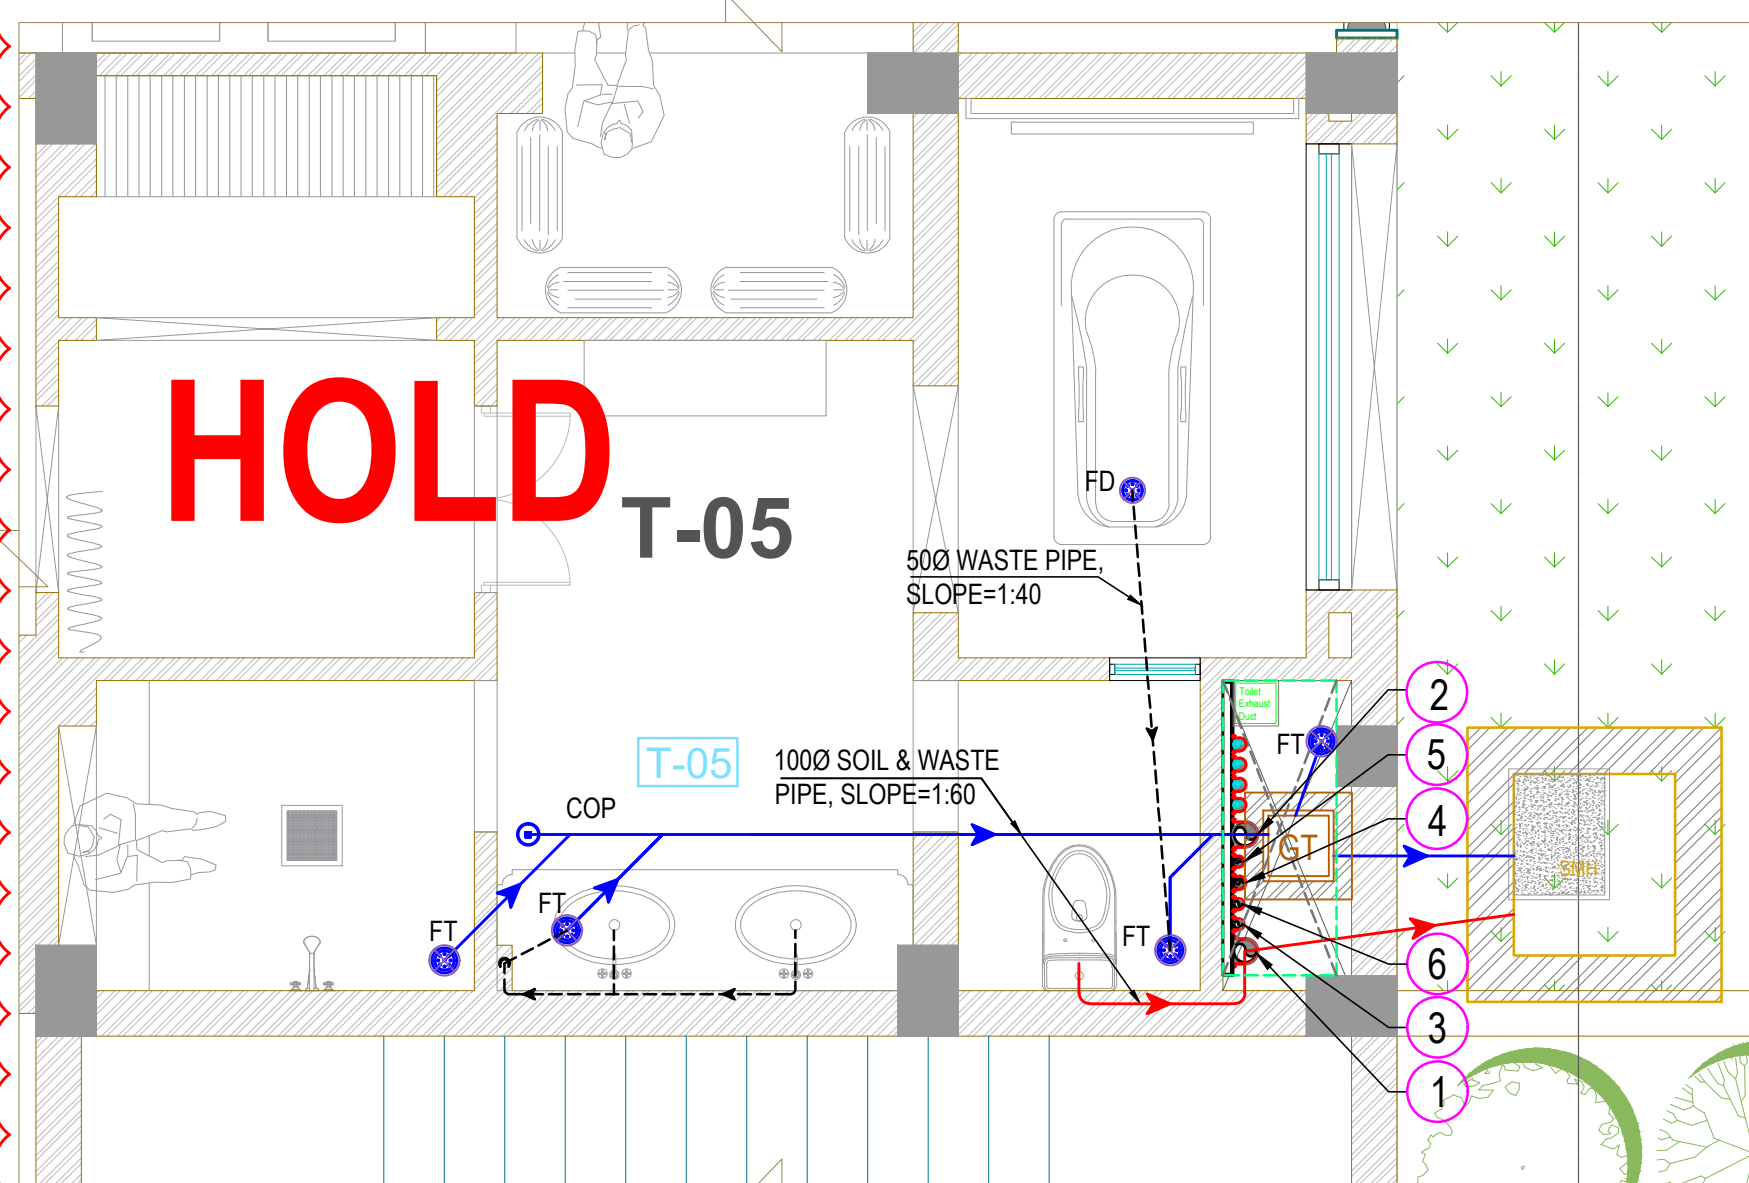

TOILET-05 FOR GROUND FLOOR (DRAINAGE LAYOUT)

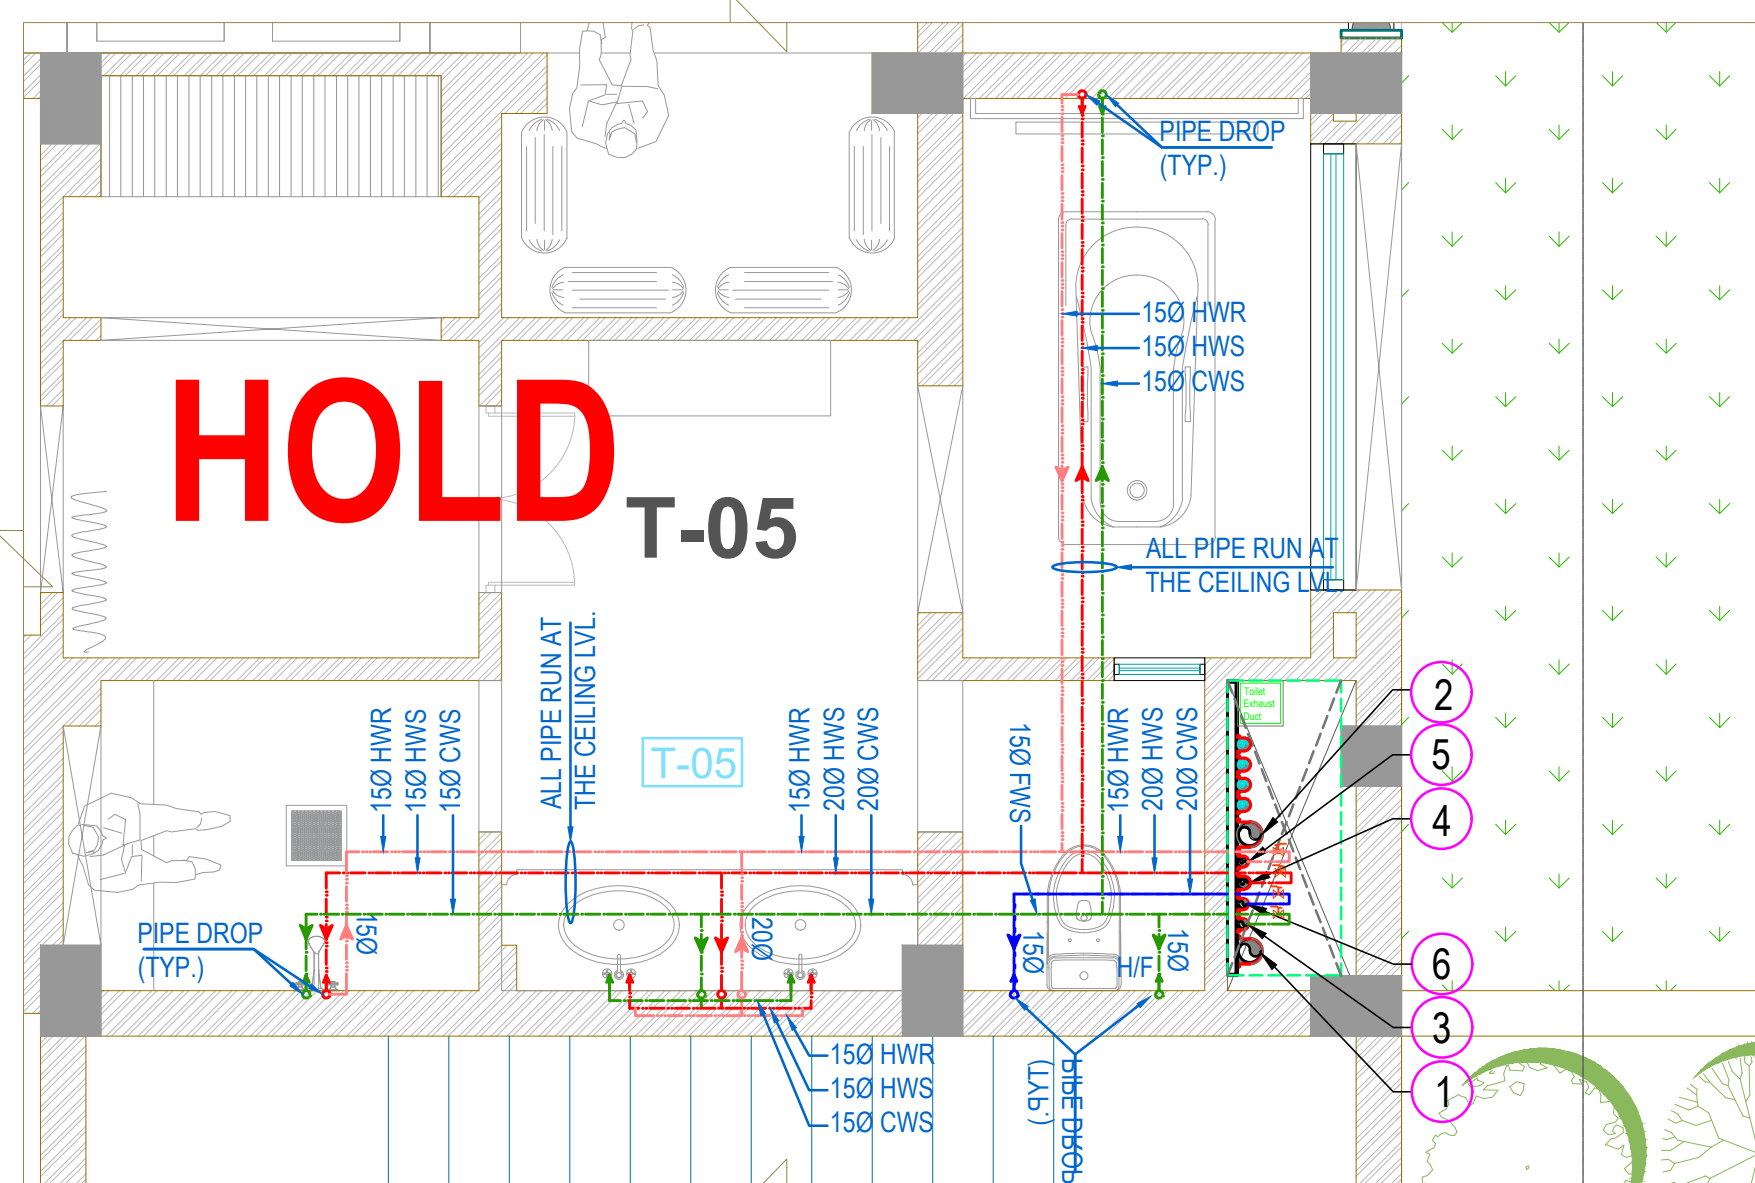

TOILET-05 FOR GROUND FLOOR (WATER SUPPLY LAYOUT)

G.F.C (ADVANCE COPY)

REVISION NO.- R0

MEPF CONSULTANT:  
NEWTECH CONSULTING ENGINEERS  
C-137/1, 3rd Floor, Vijay Vihar Phase - II  
(Rohini Sec.-1), New Delhi - 110085, (India)

ARCHITECT:  
**RAVI KUMAR GUPTA**  
CA/83/7739  
L-1, KRISHNA MARG, C-SCHEME,  
JAIPUR (302001), RAJASTHAN.  
PH.0141-2360825 E-Mail-ravigupta\_15@yahoo.com

DRAWING TITLE:  
**TOILET DETAILS FOR GROUND  
FLOOR (DRAINAGE & WATER  
SUPPLY LAYOUT)**

PROJECT:  
**LAXMI PALACE AT JAIPUR**

DRAWN BY:  
**SONU KUMAR**

CHECKED BY:  
**VIJAY KUMAR**

NOTES:  
THE COPYRIGHT AND PROPERTY OF THIS DESIGN AND DRAWING  
BELONGS TO RAVI KUMAR GUPTA. IT MUST NOT BE COPIED OR  
REPRODUCED IN ANY MANNER WITHOUT THEIR WRITTEN  
CONSENT. A LEGAL ACTION AS PER LAW MAY BE INITIATED  
AGAINST THE OFFENDER.

STRUCTURE CO. :  
**SANRACHANA**