


LEGEND - ELECTRICAL

S.NO.	SYMBOL	DESCRIPTION OF ITEM
1		CEILING FAN
2		SWITCH BOARD
3		MASTER SWITCH
4		CEILING LIGHT
6		SWITCH SOCKET 6A
7		SWITCH SOCKET 16A
9		TELEPHONE
14		DISTRIBUTION BOX
15		TUBE LIGHT
18		AC POINTS
19		UPLIGHTER (FLOOR LIGHT)
19		SPRINKLER
19		SMOKE DETECTOR
19		AC

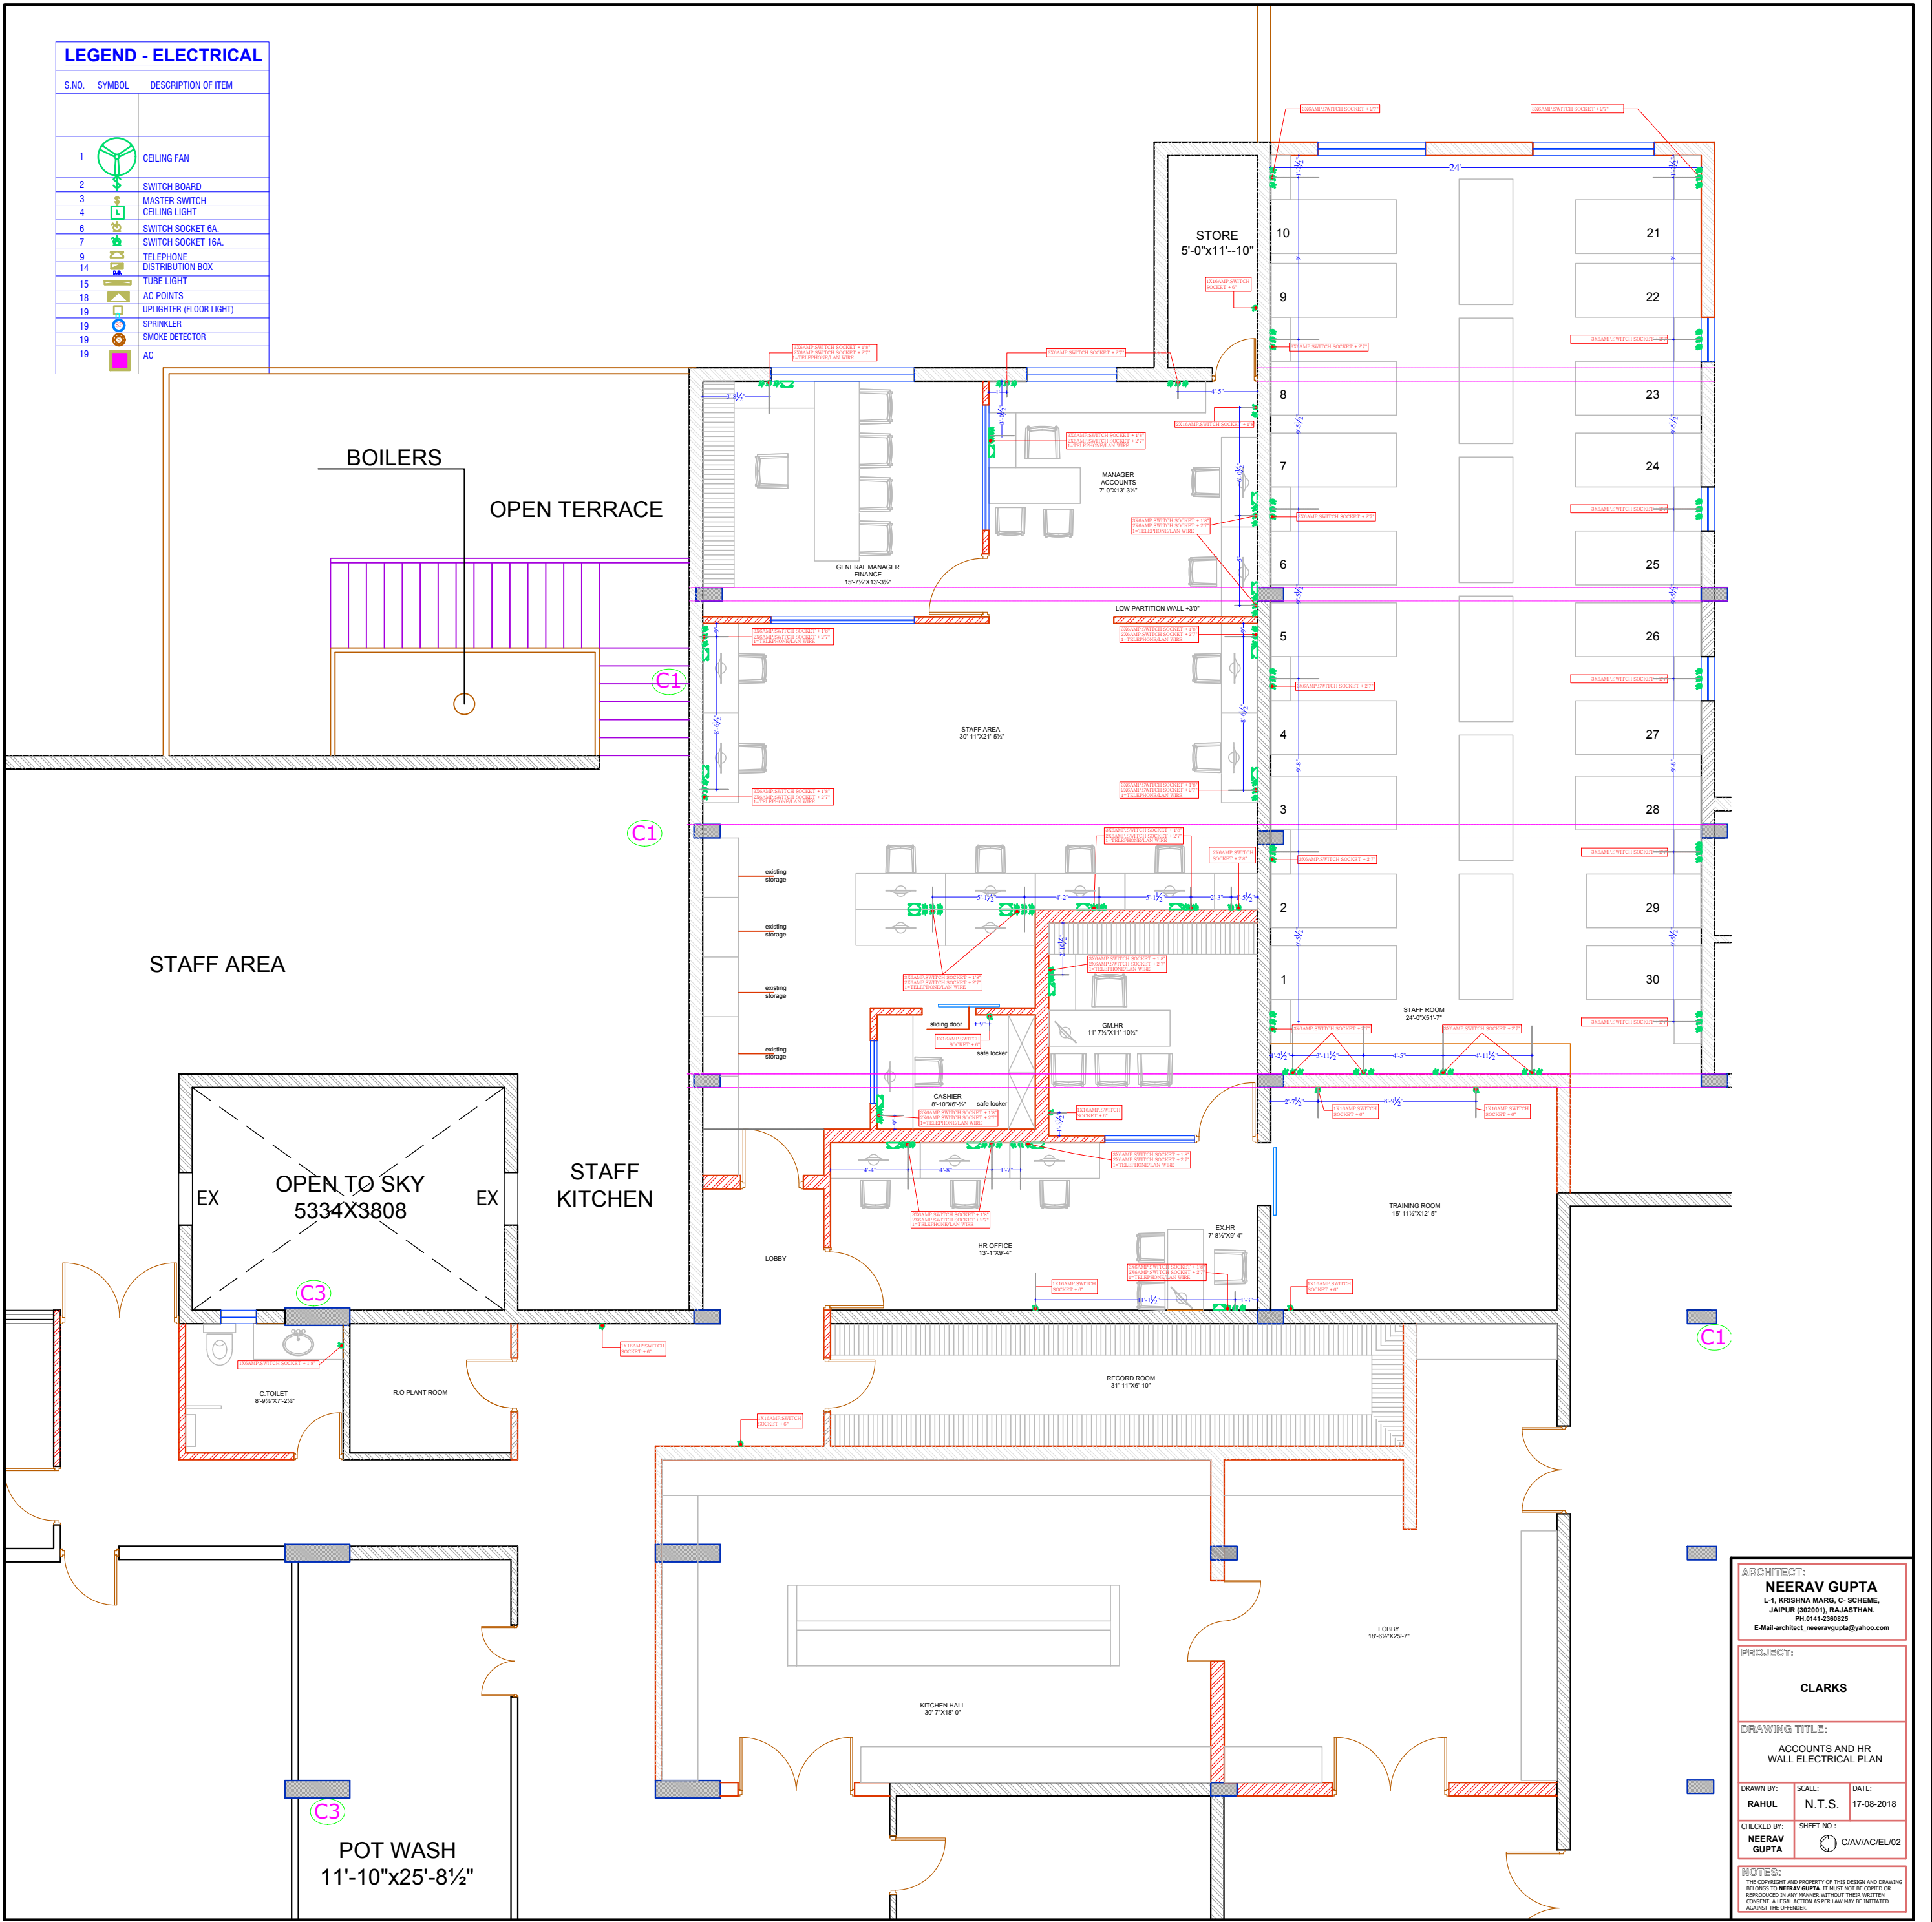

ARCHITECT:
NEERAV GUPTA
L-1, KRISHNA MARG, C-SCHEME,
JALPUR (302001), RAJASTHAN,
PH 0141-2380823
E-Mail-architect_neeravgupta@yahoo.com

PROJECT:

CLARKS

DRAWING TITLE:
**ACCOUNTS AND HR
WALL ELECTRICAL PLAN**

DRAWN BY:	SCALE:	DATE:
RAHUL	N.T.S.	17-08-2018
CHECKED BY:	SHEET NO.:	
NEERAV GUPTA	CI/AV/AC/EL/02	

NOTES:
THE COPYRIGHT AND PROPERTY OF THIS DESIGN AND DRAWING
BELONGS TO NEERAV GUPTA. IT MUST NOT BE COPIED OR
REPRODUCED IN ANY MANNER WITHOUT THEIR WRITTEN
CONSENT. A LEGAL ACTION AS PER LAW MAY BE INITIATED
AGAINST THE OFFENDER.