


LOBBY REFLECTED FLOOR ELECTRICAL PLAN

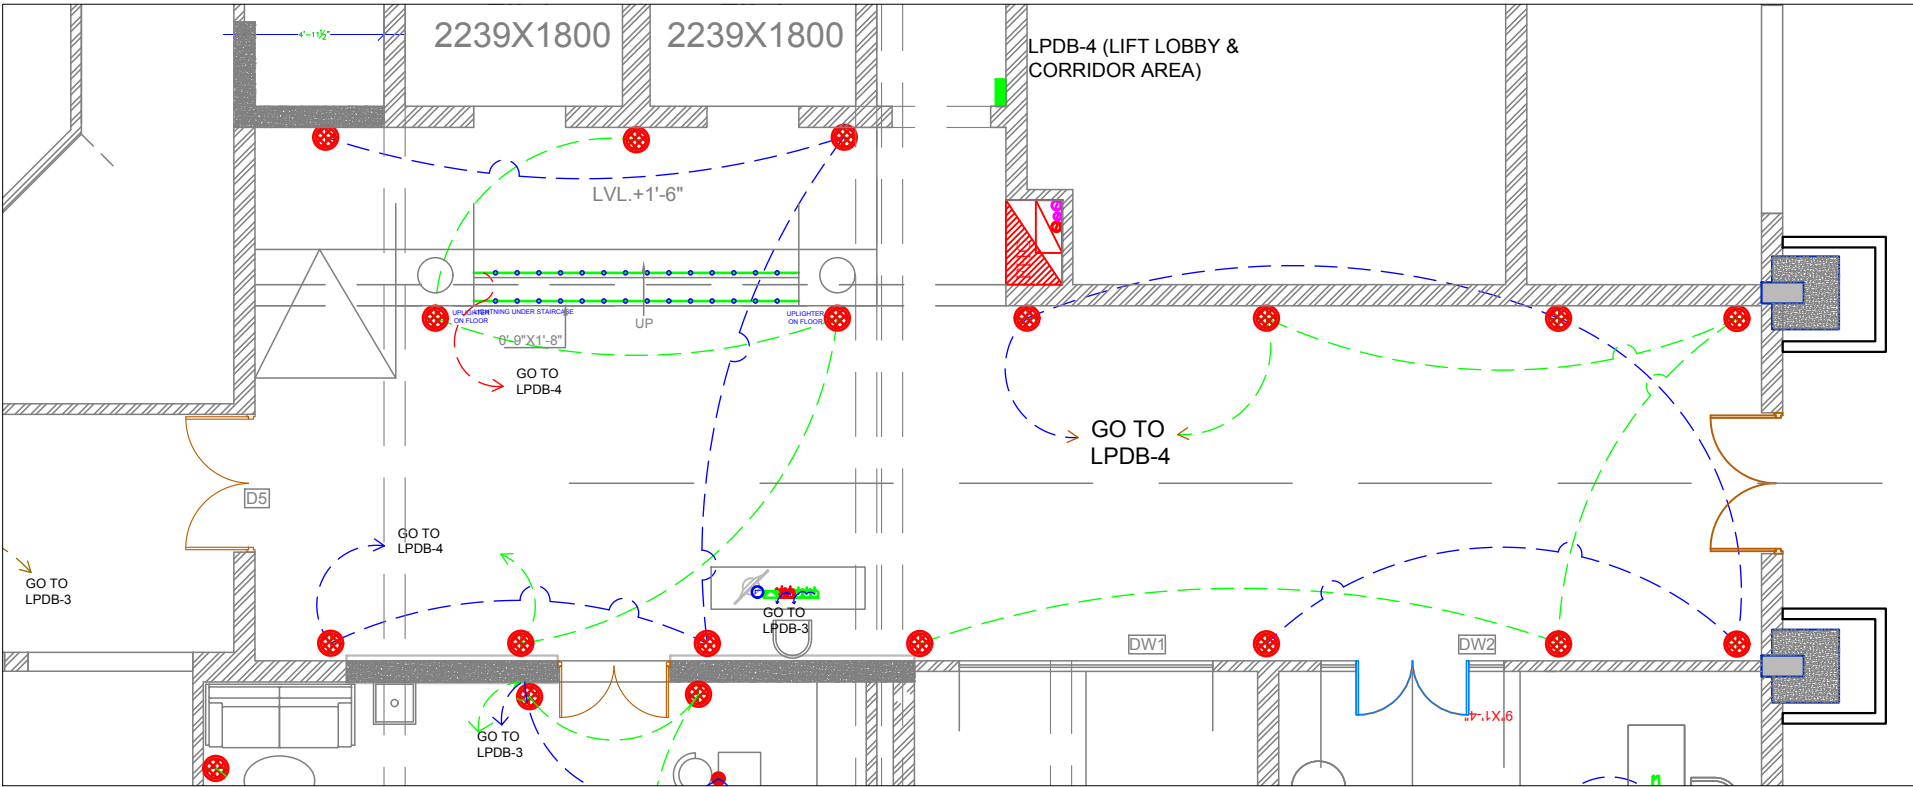

LOBBY REFLECTED FLOOR WIRE DIAGRAM

LEGEND - ELECTRICAL

S.NO.	SYMBOL	DESCRIPTION OF ITEM	HT.
1		CEILING FAN	
2		SWITCH BOARD	
3		BRACKET LIGHT	6'-0"
4		RETROFIT CFL INTEGRATED	
5		SWITCH SOCKET 6A.	
6		SWITCH SOCKET 16A.	
7		ANTENNA	
8		TELEPHONE	
9		CHANDELLIER	
10		DISTRIBUTION BOX	
11		PICTURE LIGHT	
12		HANGING LIGHT	
13		CHANDELLIER	
14		UPLIGHTERS	
15		DOWNLIGHTERS	
16		DONOT DISTURB (DND)	
17		CARD HOLDER	
18		AIR CONDITIONER	
19		FOOT LIGHT	

ARCHITECT:
NEERAV GUPTA
L-1, KOTHRIMA MARG, D-SCHEME,
JALPAIGIRI (B-2020), KOLKATA-700016
9840450000, neeravgupta@yahoo.com

PROJECT:
CLARKS

DRAWING TITLE:
LOBBY ELECTRICAL

DRAWN BY: DEEPIKA SCALE: N.T.S. DATE: 13-3-2019

CHECKED BY: NEERAV GUPTA NORTH: CABA/LO/EL/01

NOTES:
THE CORRECTNESS AND DEPENDENCY OF THIS DESIGN AND DRAWING
BELOUNG TO NEERAV GUPTA. IT MUST NOT BE COPIED OR
REPRODUCED IN ANY MANNER WITHOUT THEIR WRITTEN
CONSENT. ALL C.A.T.W. NO. PER C.A.T.W. MAY BE DETACHED
WITHOUT THE OWNER'S PERMISSION.