


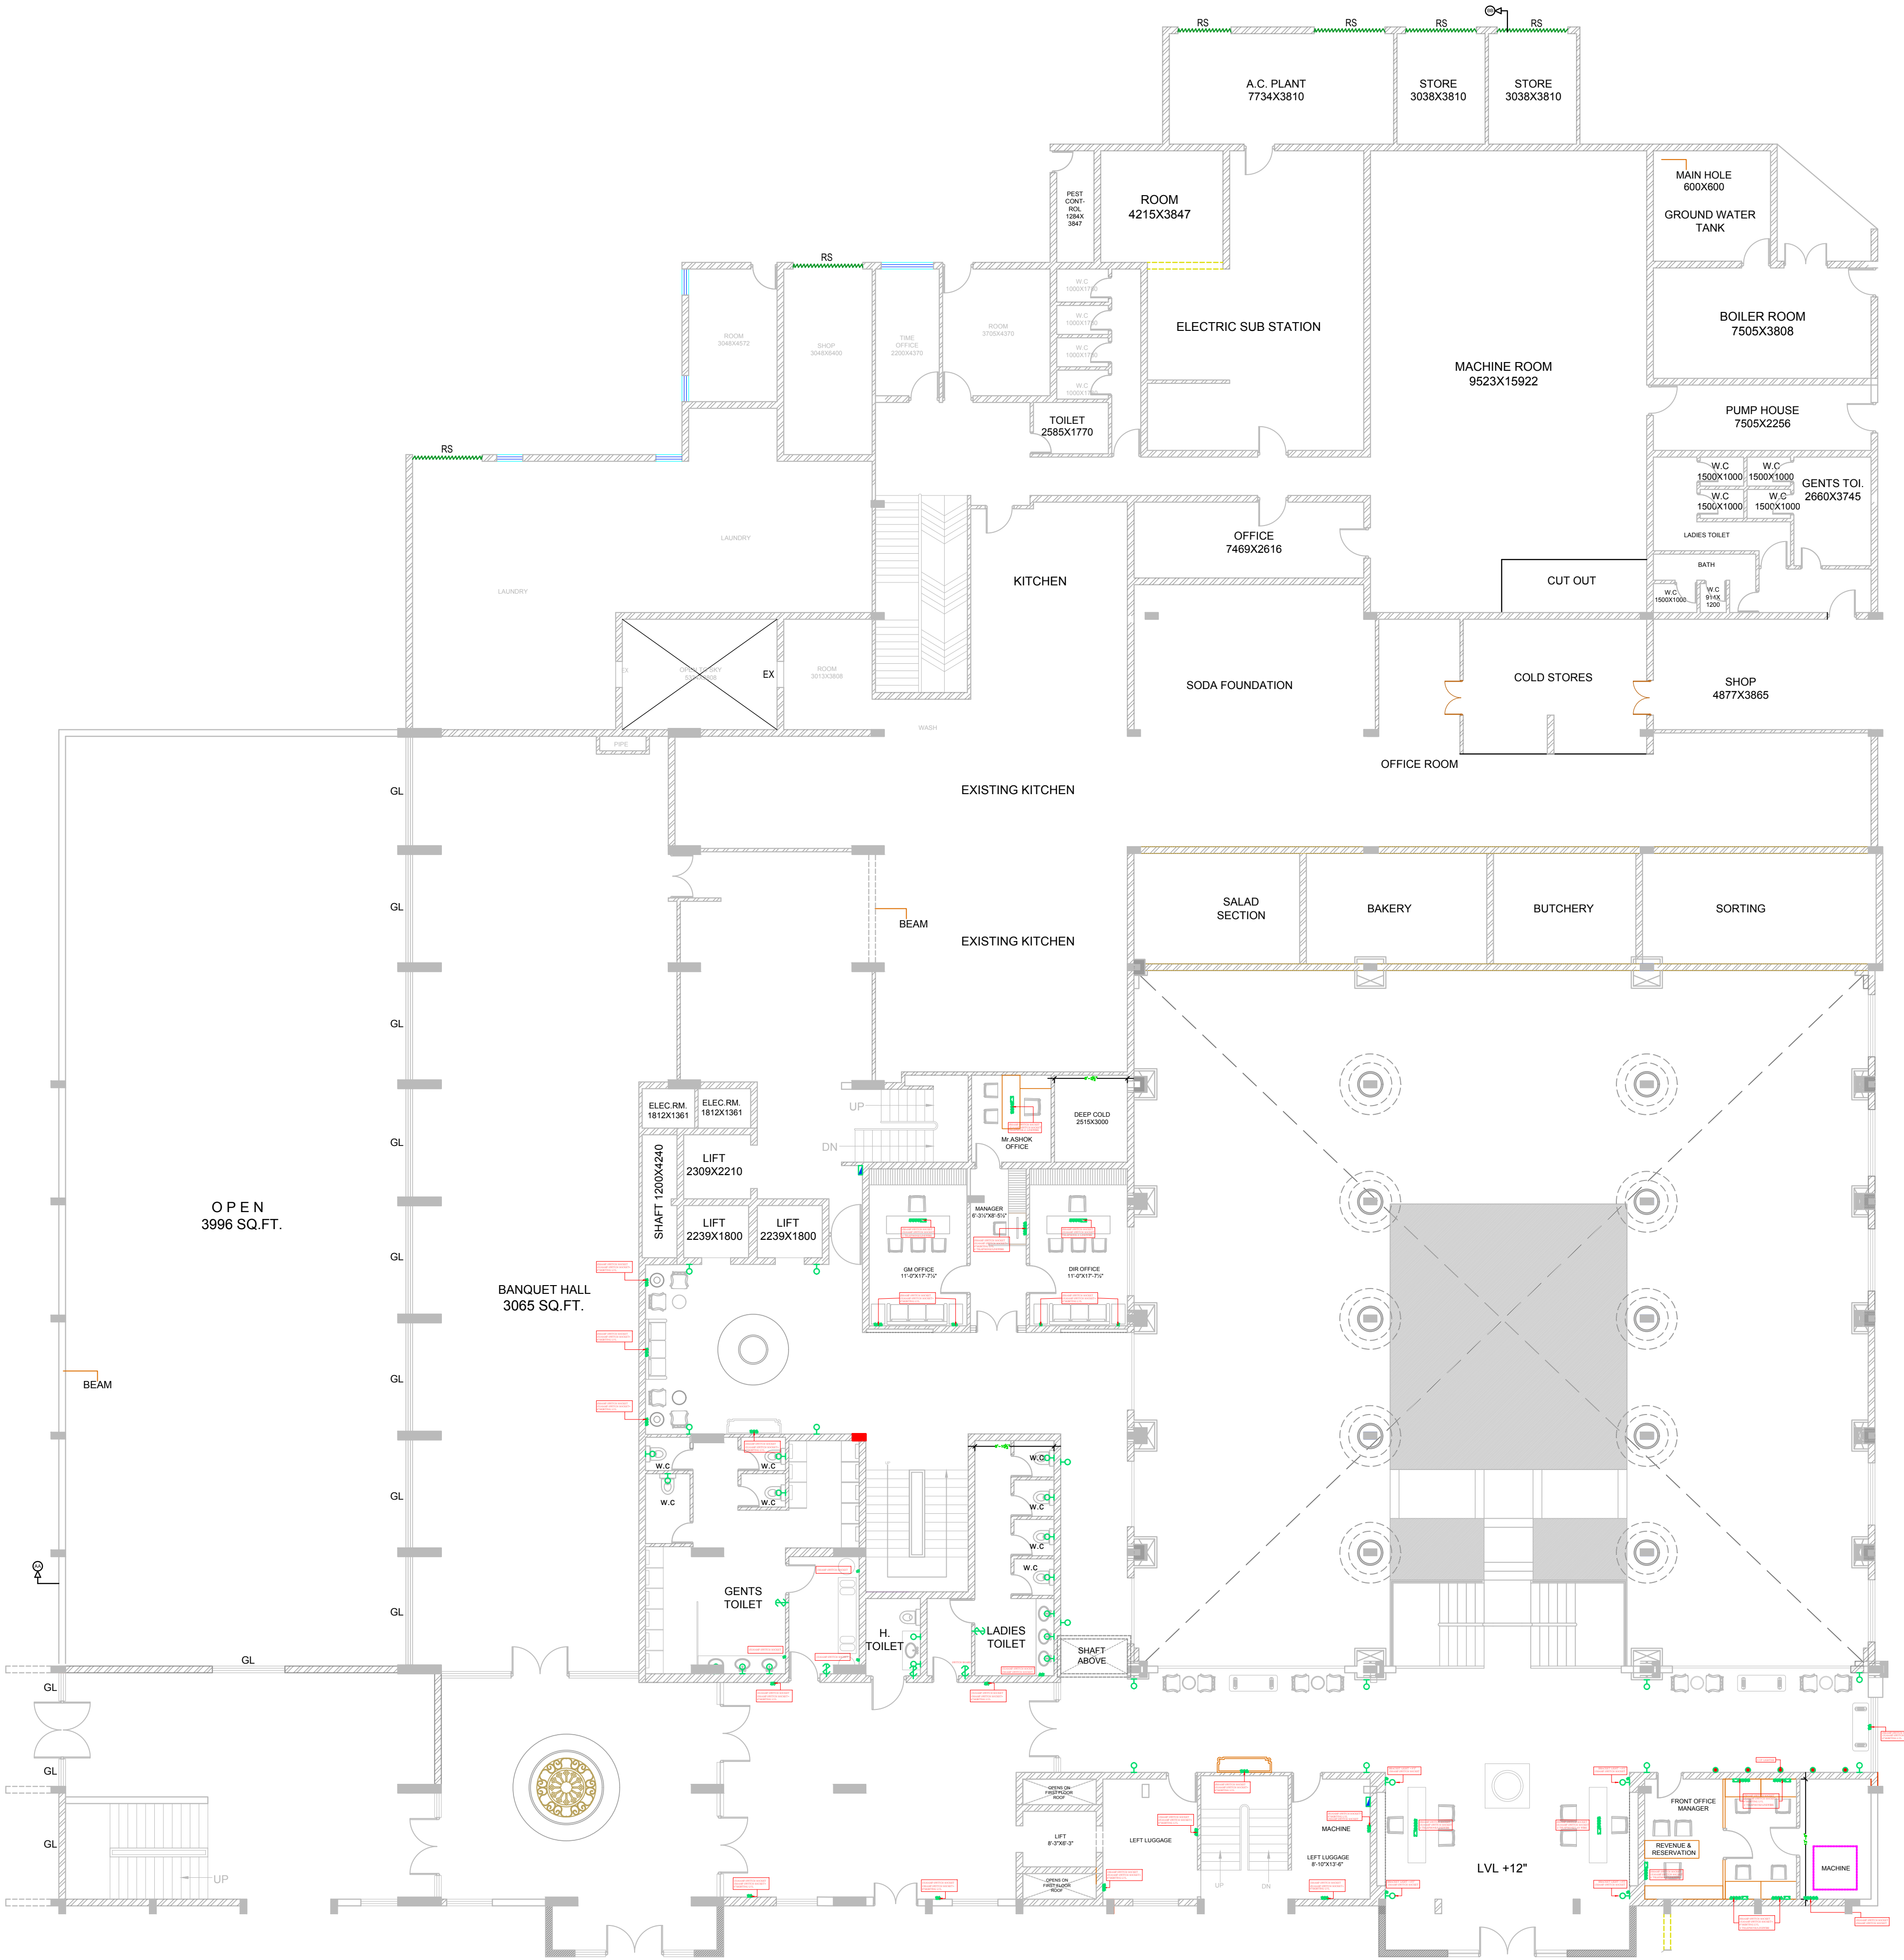

LEGEND - ELECTRICAL		
S.NO.	SYMBOL	DESCRIPTION OF ITEM
1		CHANDWLIER
2		CEILING FAN
3		SWITCH BOARD
4		CEILING LIGHT
5		BRACKET LIGHT H 8' FROM FINISH FLOOR LVL
6		SWITCH SOCKET 6A.
7		SWITCH SOCKET 16A.
8		ANTENNA
9		TELEPHONE/LINEWIRE
10		EXHAUST FAN
11		DISTRIBUTION BOX
12		TUBE LIGHT
13		PICTURE LIGHT
14		AC POINTS
15		UPLIGHTER

PROJECTED BY NEERAV GUPTA L1, NEERAV GUPTA, C. SINGH, GATEWAY, GATEWAY, GATEWAY			
PROJECTED BY CLARKS			
DRAWING TITLE: GROUND FLOOR WALL ELECTRICAL PLAN			
DRAWN BY: RAHUL	SCALE: N.T.S.	DATE: 25-08-2018	
CHECKED BY: NEERAV GUPTA	DATE: 25-08-2018	PROJECTED BY: CLARKS	
NOTES: 1. ALL ELECTRICAL WORKS TO BE DONE AS PER THE DRAWING. 2. ALL ELECTRICAL WORKS TO BE DONE AS PER THE DRAWING. 3. ALL ELECTRICAL WORKS TO BE DONE AS PER THE DRAWING.			